


- SEMI GLAZED PARTITION
  - LOW HEIGHT PARTITION
  - FULL GLAZED PARTITION
  - FULL HEIGHT SOLID PARTITION
- ARM MGR - 1
  - AGM - 2
  - SM - 8
  - MGR - 8
  - OFFICER - 43

CARPET AREA  
 SECOND FLOOR - 7845.10 SQ.FT  
 THIRD FLOOR - 8129.10 SQ.FT  
 TOTAL AREA - 15974.20 SQ.FT  
 (EXCLUDED TOILET & STAIRCASE)

JOB NO <b>1739</b>	PROJECT TITLE : <b>PROPOSED INTERIOR DESIGN FOR CANARA BANK CIRCLE OFFICE SAMBAKULAM ROAD, MADURAI.</b>	DRAWING TITLE :	SECOND FLOOR INTERIOR LAYOUT	DESIGN STAGE	SCHEME LEVEL	SCALE	N.T.S	REV NO	REV - 19	ORIENTATION	ARCHITECTS <b>TSO DESIGN COMMUNE PVT. LTD.</b> Architects ■ Planners ■ Interior designers
		DRAWING TYPE :	SCHEMATIC DRAWING		FINAL COPY	DATE	29-04-2025	DRN	K.D	CHKD	


NEW NO.16,(OLD NO.42), Ground floor, South West Boag Road,  
 T.Nagar, Chennai - 600017. Ph : 044 - 4212 9252  
 Telefax : 044 - 2435 0490 E-mail : info@tsodc.com

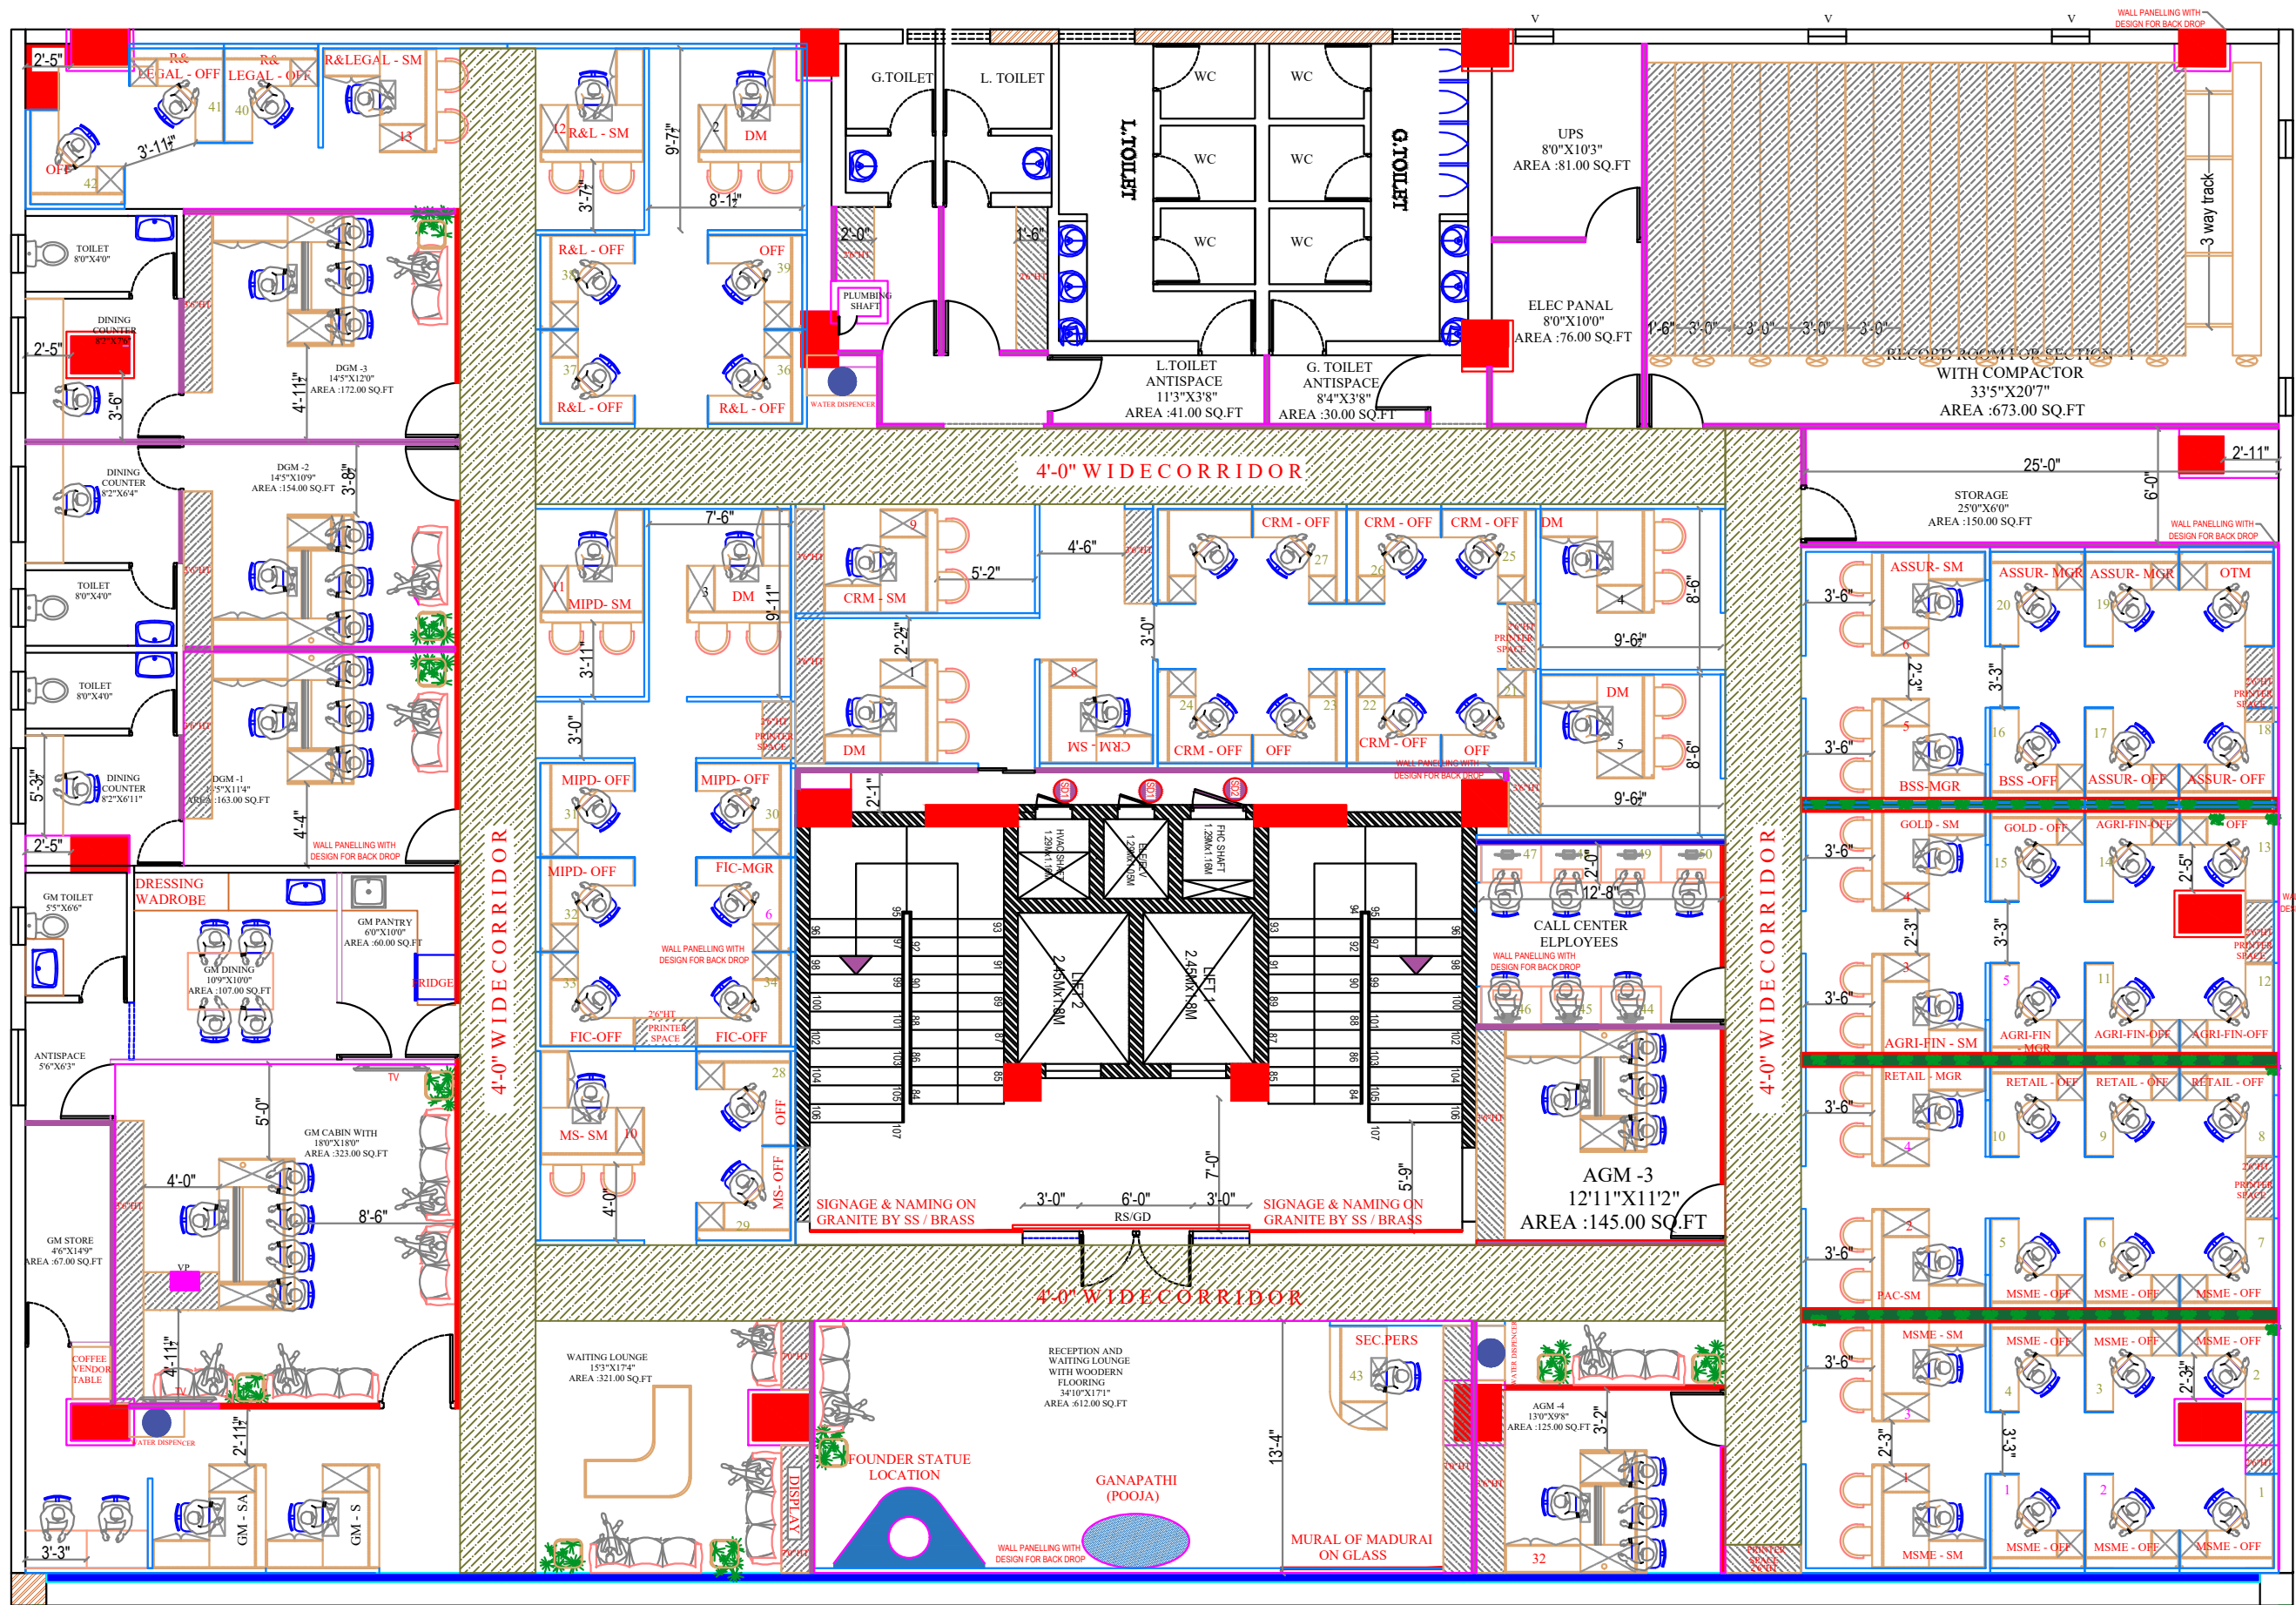

- ▬ SEMI GLAZED PARTITION
  - ▬ LOW HEIGHT PARTITION
  - ▬ FULL GLAZED PARTITION
  - ▬ FULL HEIGHT SOLID PARTITION
- |         |      |
|---------|------|
| GM      | - 1  |
| DGM     | - 3  |
| DM      | - 5  |
| AGM     | - 2  |
| SM      | - 12 |
| MGR     | - 6  |
| OFFICER | - 52 |

CARPET AREA - 7845.10 SQ.FT  
 SECOND FLOOR - 7845.10 SQ.FT  
 THIRD FLOOR - 8129.10 SQ.FT  
 TOTAL AREA - 15974.20 SQ.FT  
 (EXCLUDED TOILET & STAIRCASE)


JOB NO <b>1739</b>	PROJECT TITLE : <b>PROPOSED INTERIOR DESIGN FOR          CANARA BANK CIRCLE OFFICE</b> SAMBAKULAM ROAD, MADURAI.	DRAWING TITLE : <b>THIRD FLOOR INTERIOR LAYOUT</b>  DRAWING TYPE : SCHEMATIC DRAWING	DESIGN STAGE <div style="display: flex; gap: 5px;"> <div style="width: 15px; height: 10px; border: 1px solid black; background-color: white;"></div> SCHEME LEVEL  <div style="width: 15px; height: 10px; border: 1px solid black; background-color: gray;"></div> FINAL COPY         </div>	SCALE N.T.S DATE 29-04-2025 R.DATE 25.10.2025	REV NO REV - 19 ORIENTATION <div style="text-align: center;"> </div>	ARCHITECTS <b>TSO DESIGN COMMUNE PVT. LTD.</b> Architects ■ Planners ■ Interior designers <small>NEW NO.16,(OLD NO.42), Ground floor, South West Boag Road,          T.Nagar, Chennai - 600017. Ph : 044 - 4212 9252          Telefax : 044 - 2435 0490 E-mail : info@tdoc.com</small>
-----------------------	--	--	---	---	---	---

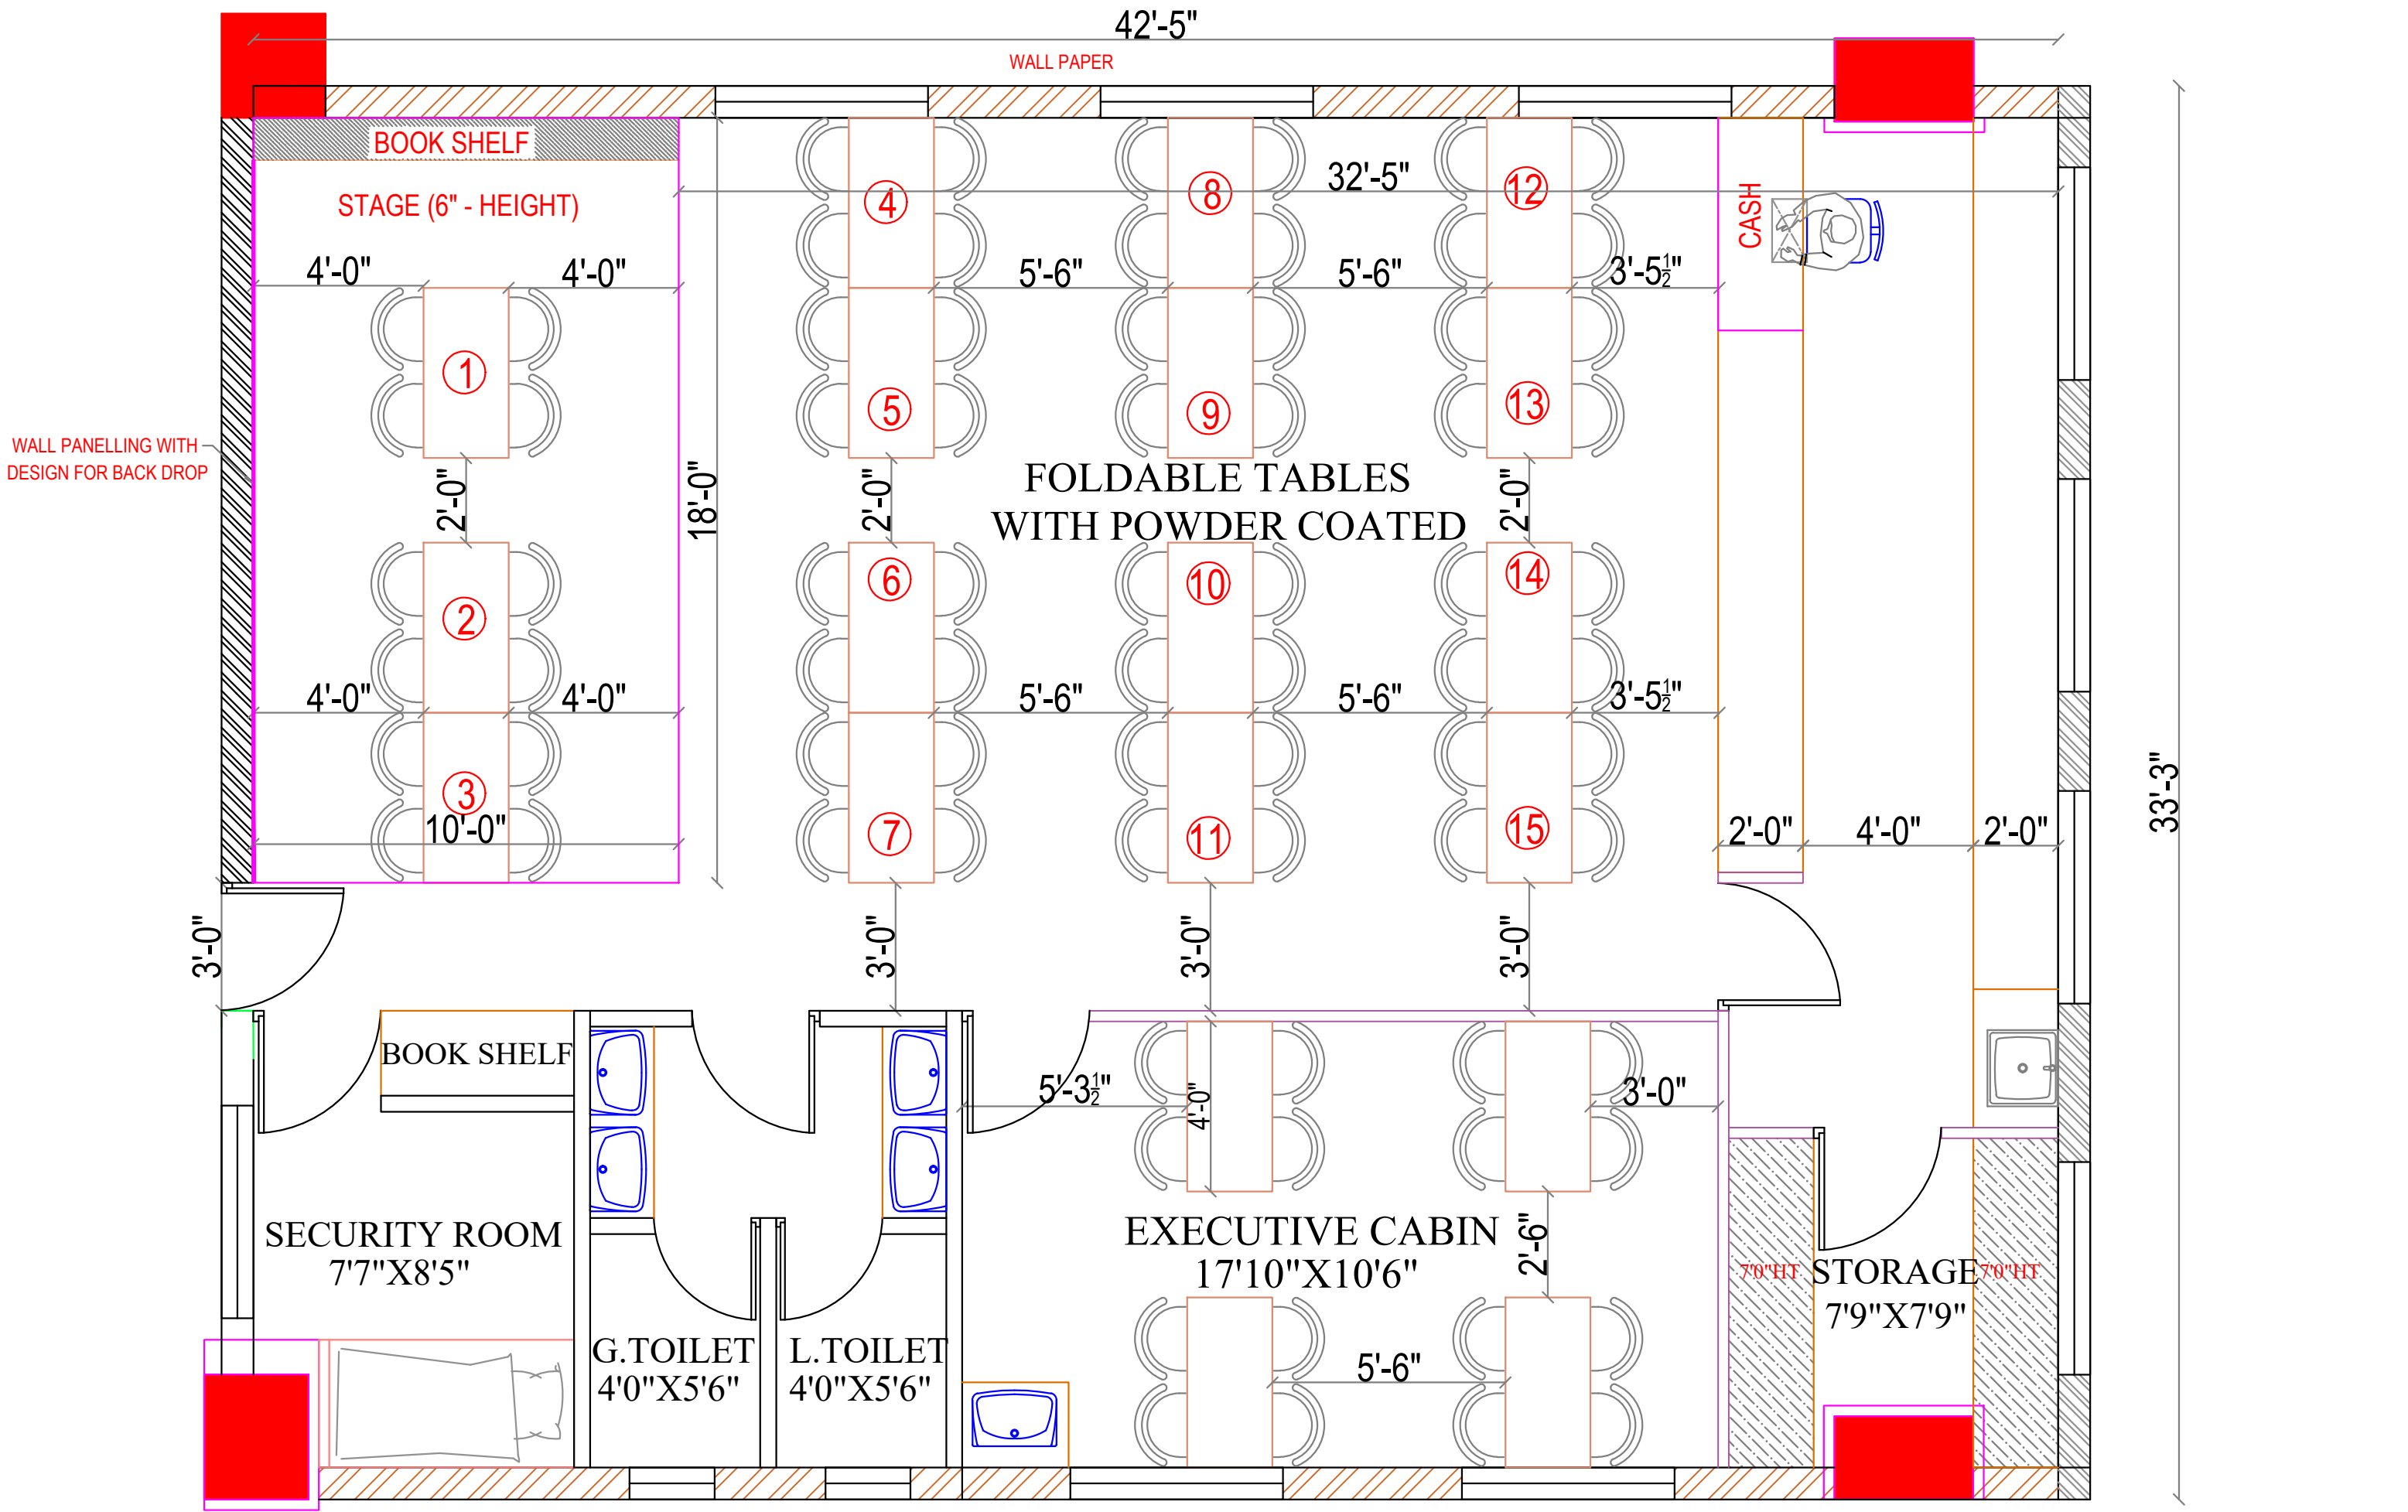

JOB NO	PROJECT TITLE :	PROPOSED INTERIOR DESIGN FOR	DRAWING TITLE :	DESIGN STAGE	SCALE	N.T.S	REV NO	TERR.F-18	ORIENTATION	ARCHITECTS
1739	CANARA BANK CIRCLE OFFICE SAMBAKULAM ROAD, MADURAI.	TERRACE FLOOR DINING LAYOUT	SCHEMATIC DRAWING	SCHEME LEVEL	DATE	29-04-2025	DRN	K.D		
		FINAL COPY		R.DATE	03.10.2025	CHKD	K.S			

**TSO DESIGN COMMUNE PVT. LTD.**  
Architects ■ Planners ■ Interior designers  
NEW NO.16,(OLD NO.42), Ground floor, South West Boag Road,  
T.Nagar, Chennai - 600017. Ph : 044 - 4212 9252  
Telefax : 044 - 2435 0493 E-mail : info@tsodc.com

25'-6"

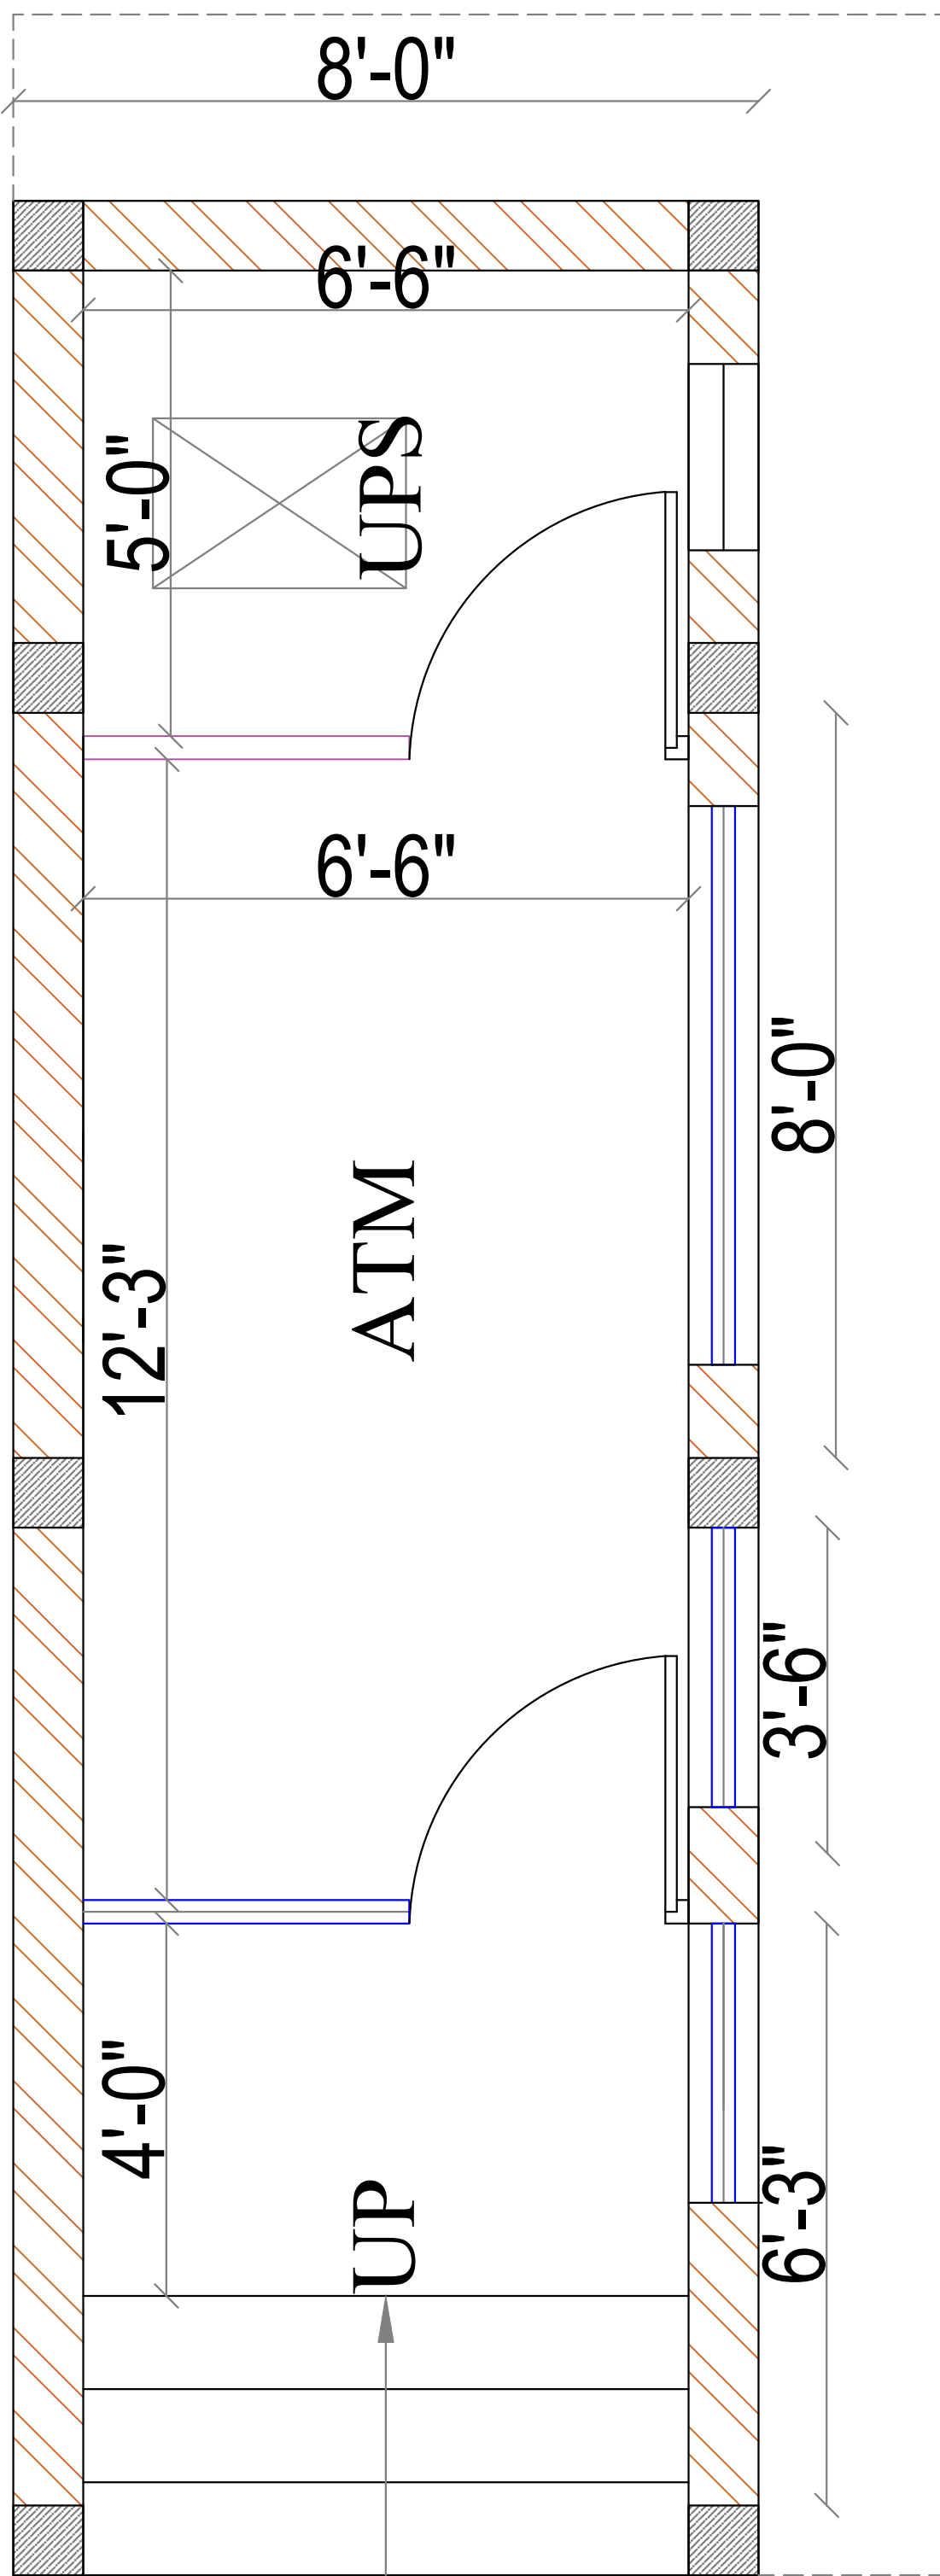

JOB NO

1739

PROJECT TITLE :

PROPOSED INTERIOR DESIGN FOR  
**CANARA BANK CIRCLE OFFICE**  
SAMBAKULAM ROAD, MADURAI.

DRAWING TITLE :

ATM

DRAWING TYPE :

SCHEMATIC DRAWING

DESIGN STAGE

SCHEME LEVEL

FINAL COPY

SCALE

DATE

R.DATE

REV/NO

DRN

CHKD

TERR.F-04

 
M.G

K.S


ORIENTATION



ARCHITECTS



**TSO DESIGN COMMUNE PVT. LTD.**  
Architects • Planners • Interior designers  
NEW NO.16, GILD NO.43, Ground floor, South West Bang Road,  
Madrasi, Chennai - 600 026.  
Tel: 044-245 9493 E-mail: info@tsocorp.com

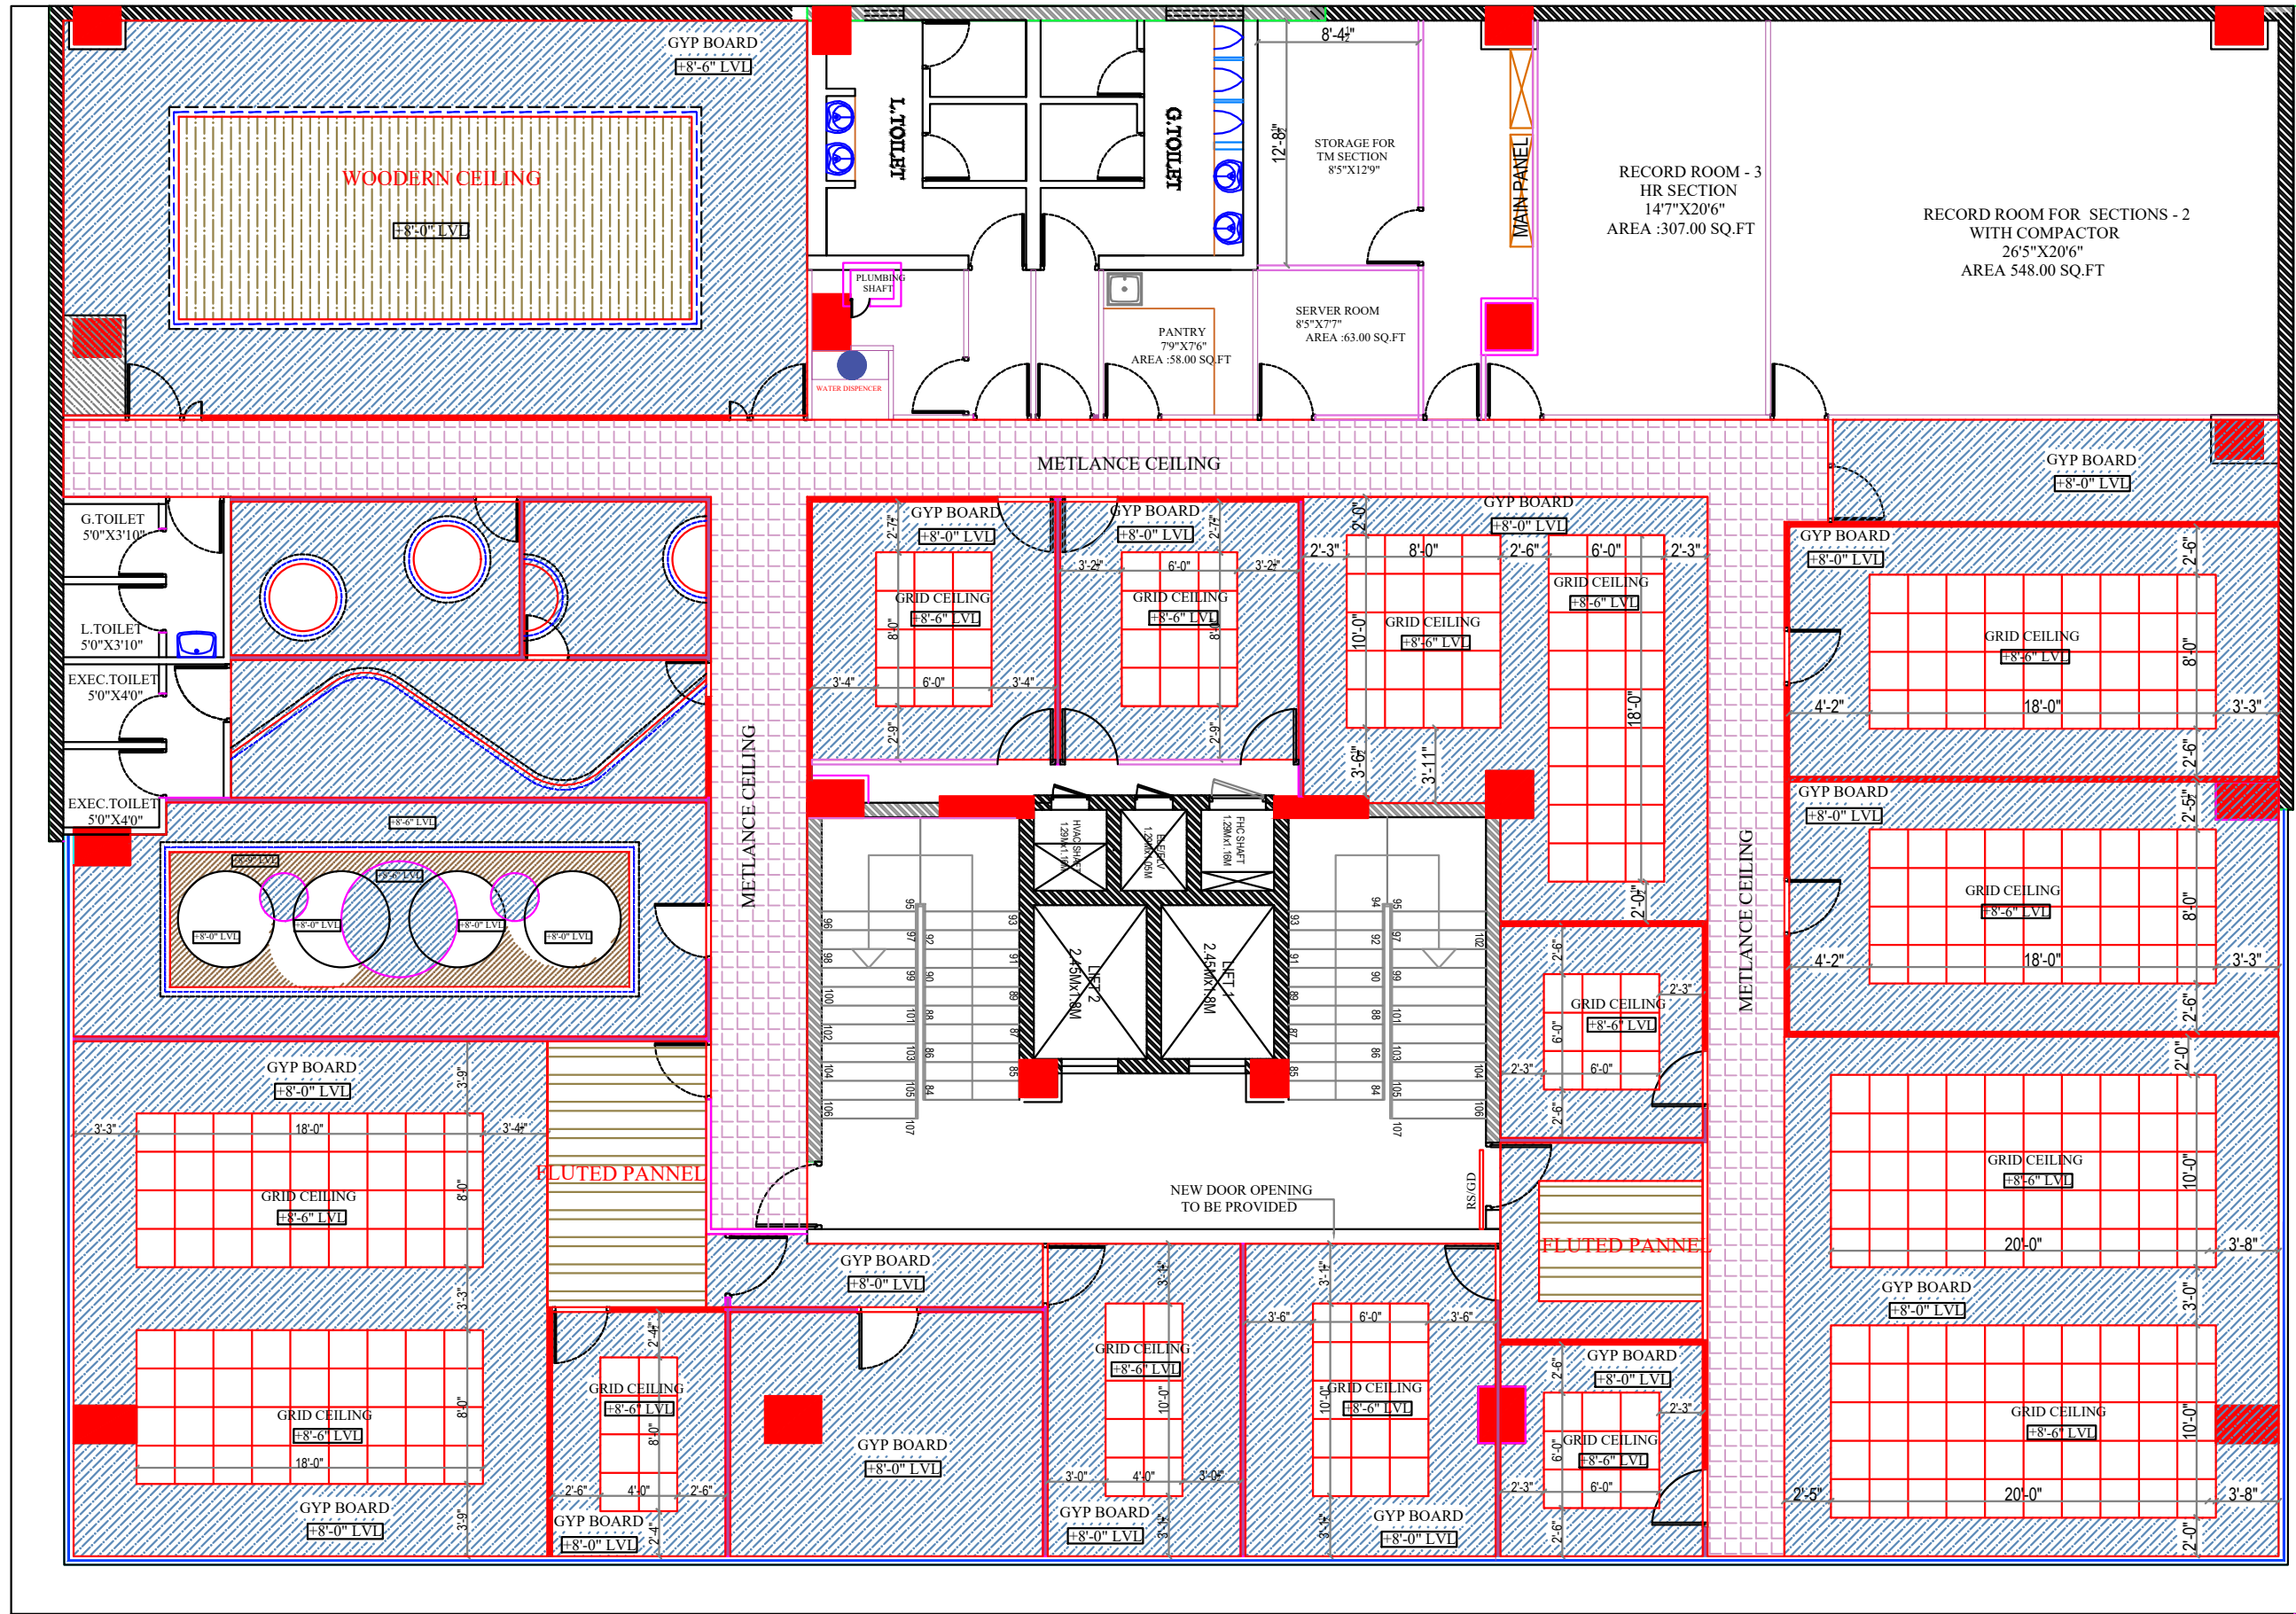


- LOW HEIGHT PARTITION
  - FULL GLAZED PARTITION
  - FULL HEIGHT SOLID PARTITION
- ARM MGR - 1  
 AGM - 2  
 SM - 8  
 MGR - 8  
 OFFICER - 43

CARPET AREA  
 SECOND FLOOR - 7845.10SQ.FT  
 THIRD FLOOR - 8129.10 SQ.FT  
 TOTAL AREA - 15974.20 SQ.FT  
 (EXCLUDED TOILET & STAIRCASE)

JOB NO	PROJECT TITLE : <b>PROPOSED INTERIOR DESIGN FOR CANARA BANK CIRCLE OFFICE</b> SAMBAKULAM ROAD, MADURAI.	DRAWING TITLE : SECOND FLOOR INTERIOR LAYOUT	DRAWING TYPE : SCHEMATIC DRAWING	DESIGN STAGE	SCALE	N.T.S	REV NO	REV - 18	ORIENTATION	ARCHITECTS
<b>1739</b>				<ul style="list-style-type: none"> <li><span style="border: 1px solid black; display: inline-block; width: 15px; height: 10px; margin-right: 5px;"></span> SCHEME LEVEL</li> <li><span style="background-color: gray; display: inline-block; width: 15px; height: 10px; margin-right: 5px;"></span> FINAL COPY</li> </ul>	DATE	29-04-2025	DRN	K.D		
				R.DATE	03.10.2025	CHKD	K.S			

**TSO DESIGN COMMUNE PVT. LTD.**  
 Architects ■ Planners ■ Interior designers  
NEW NO.16,(OLD NO.42), Ground floor, South West Boag Road,  
 T.Nagar, Chennai - 600017. Ph : 044 - 4212 9252  
 Telefax : 044 - 2435 0493 E-mail : info@tsodc.com

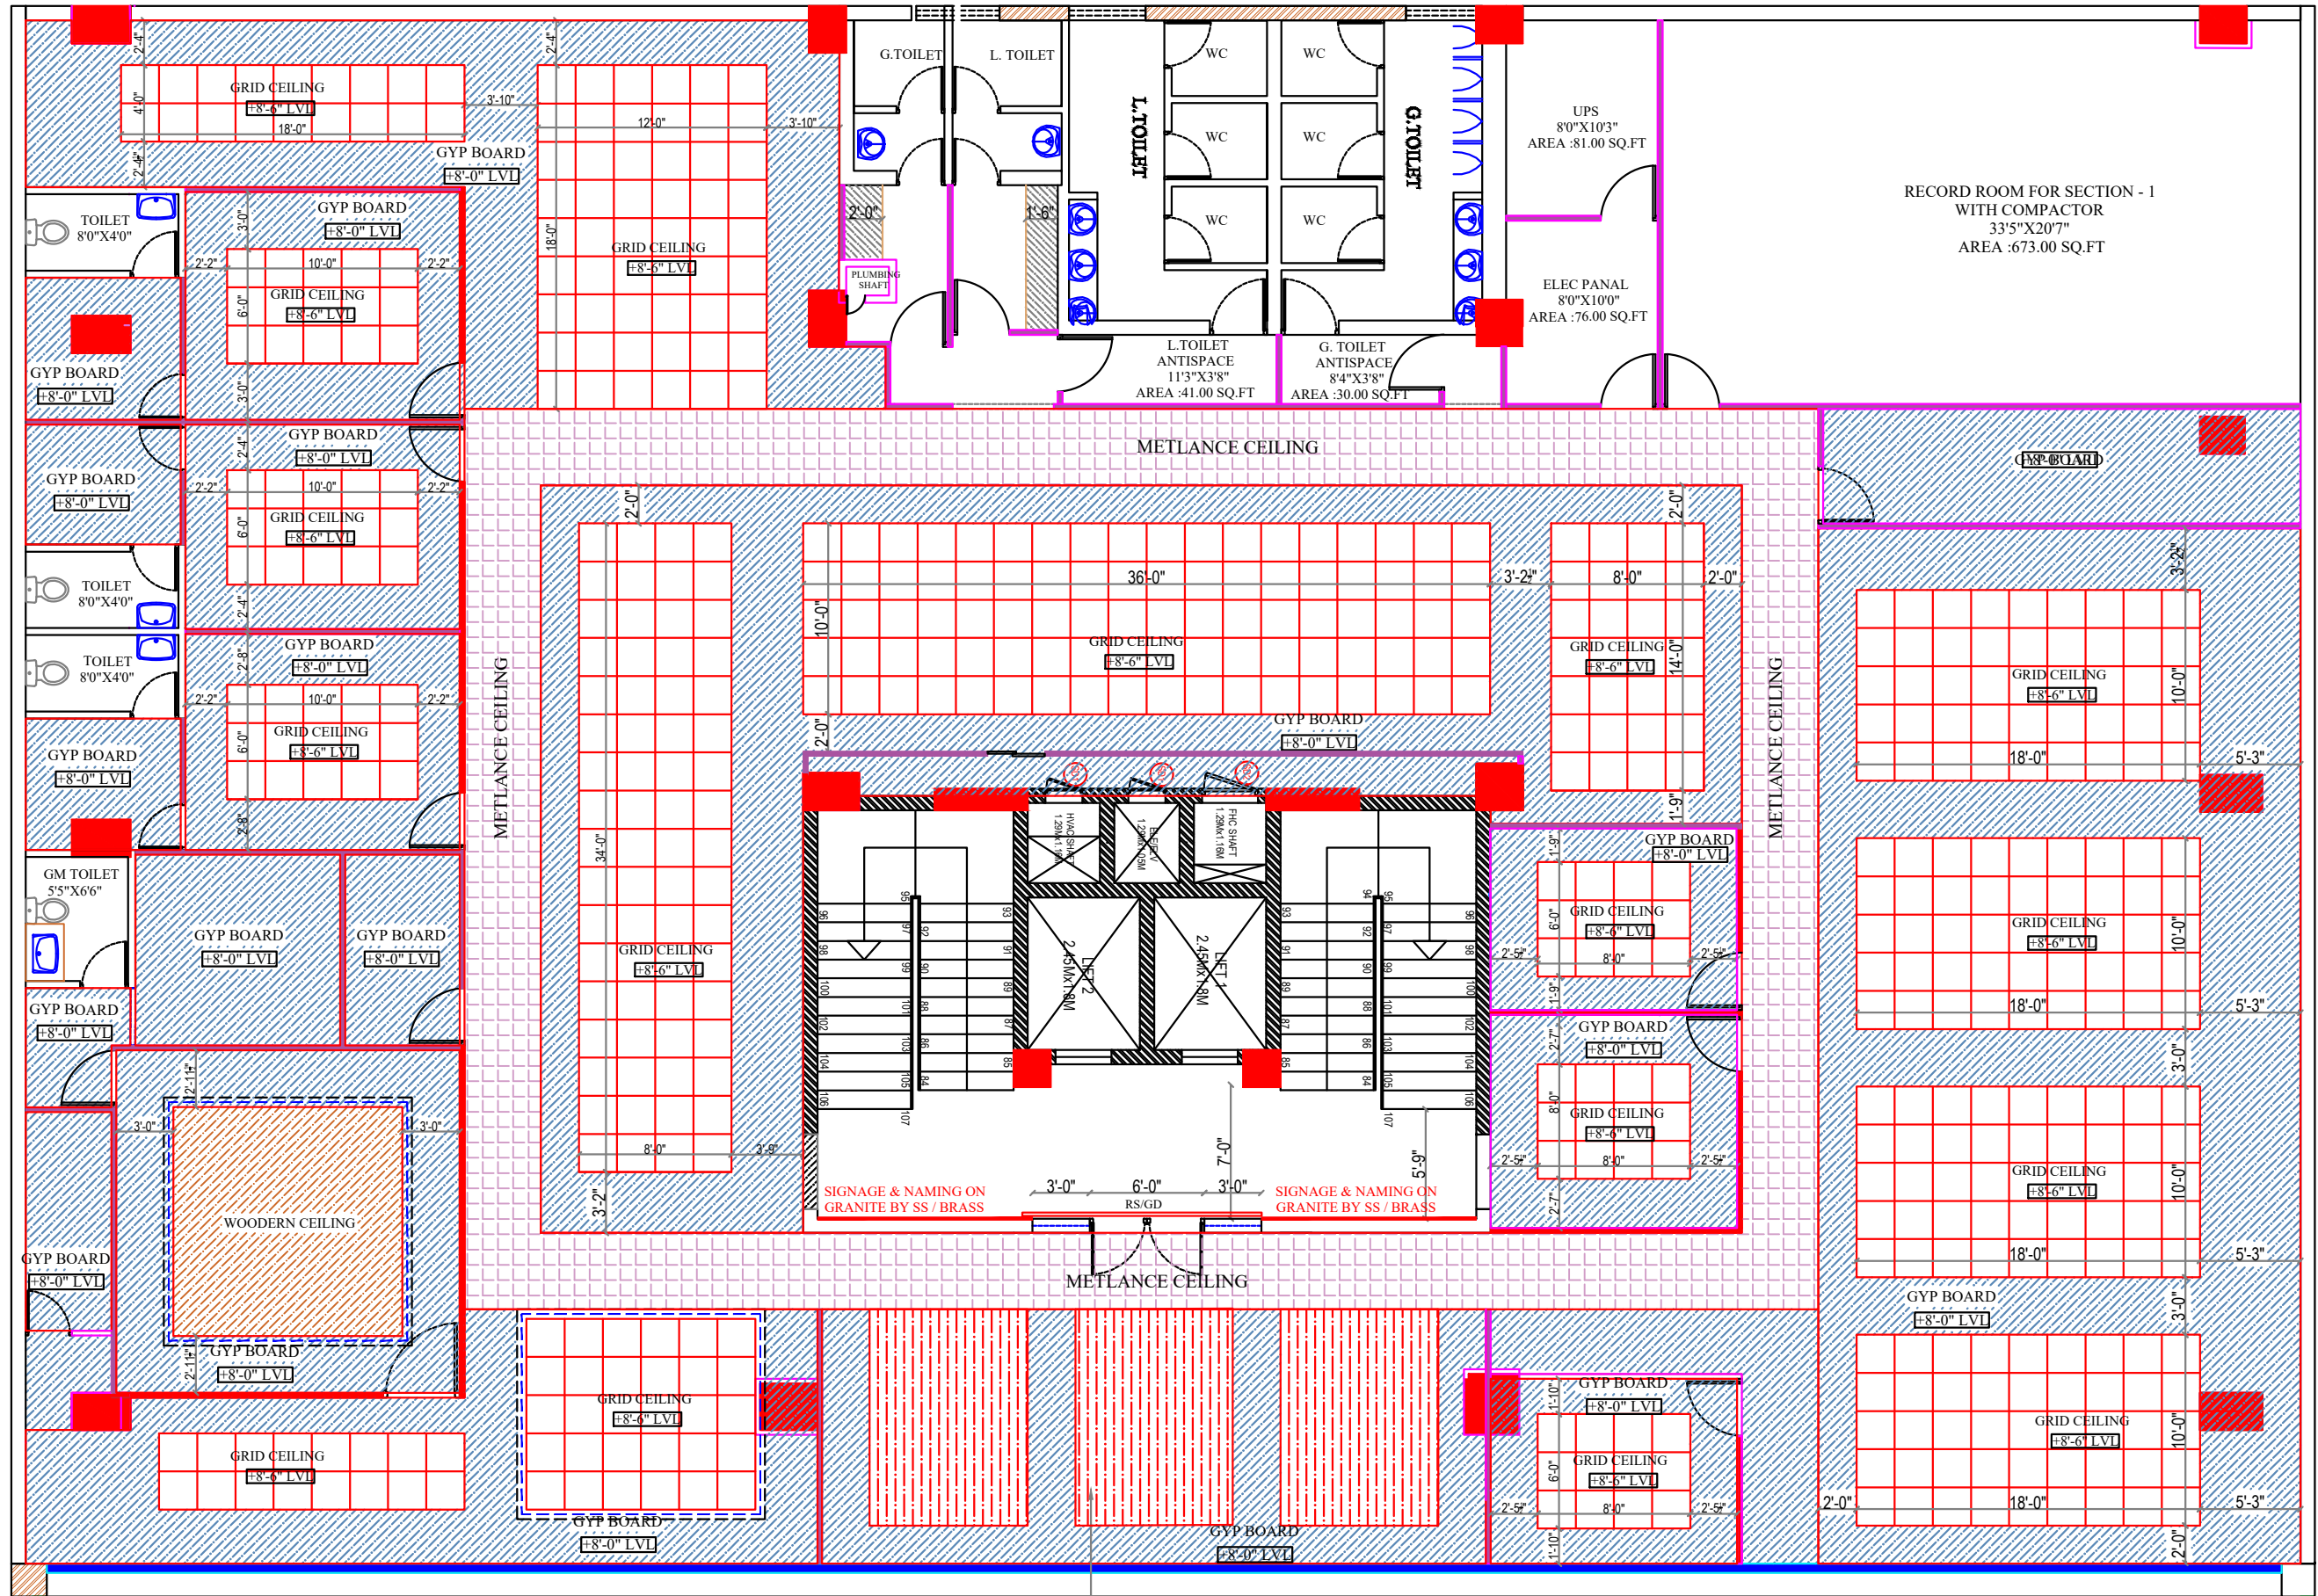

RECORD ROOM FOR SECTION - 1  
WITH COMPACTOR  
33'5"X20'7"  
AREA : 673.00 SQ.FT

UPS  
8'0"X10'3"  
AREA : 81.00 SQ.FT

ELEC PANAL  
8'0"X10'0"  
AREA : 76.00 SQ.FT

L.TOILET ANTISPAC  
11'3"X3'8"  
AREA : 41.00 SQ.FT


G. TOILET ANTISPAC  
8'4"X3'8"  
AREA : 30.00 SQ.FT


- ▬ LOW HEIGHT PARTITION
- ▬ FULL GLAZED PARTITION
- ▬ FULL HEIGHT SOLID PARTITION

- GM - 1
- DGM - 3
- DM - 5
- AGM - 2
- SM - 12
- MGR - 6
- OFFICER - 52

CARPET AREA  
SECOND FLOOR - 7845.10SQ.FT  
THIRD FLOOR - 8129.10 SQ.FT  
TOTAL AREA - 15974.20 SQ.FT  
(EXCLUDED TOILET & STAIRCASE)

STRETCH CEILING WITH  
BACK LED LIGHT

JOB NO <b>1739</b>	PROJECT TITLE : <b>PROPOSED INTERIOR DESIGN FOR CANARA BANK CIRCLE OFFICE SAMBAKULAM ROAD, MADURAI.</b>	DRAWING TITLE :	THIRD FLOOR INTERIOR LAYOUT	DESIGN STAGE	SCALE	N.T.S	REV NO	REV - 18	ORIENTATION	ARCHITECTS <b>T.S.O DESIGN COMMUNE PVT. LTD.</b> Architects ■ Planners ■ Interior designers
		DRAWING TYPE :	SCHEMATIC DRAWING	SCHEME LEVEL	DATE	29-04-2025	DRN	K.D		
				FINAL COPY	R.DATE	03.10.2025	CHKD	K.S		

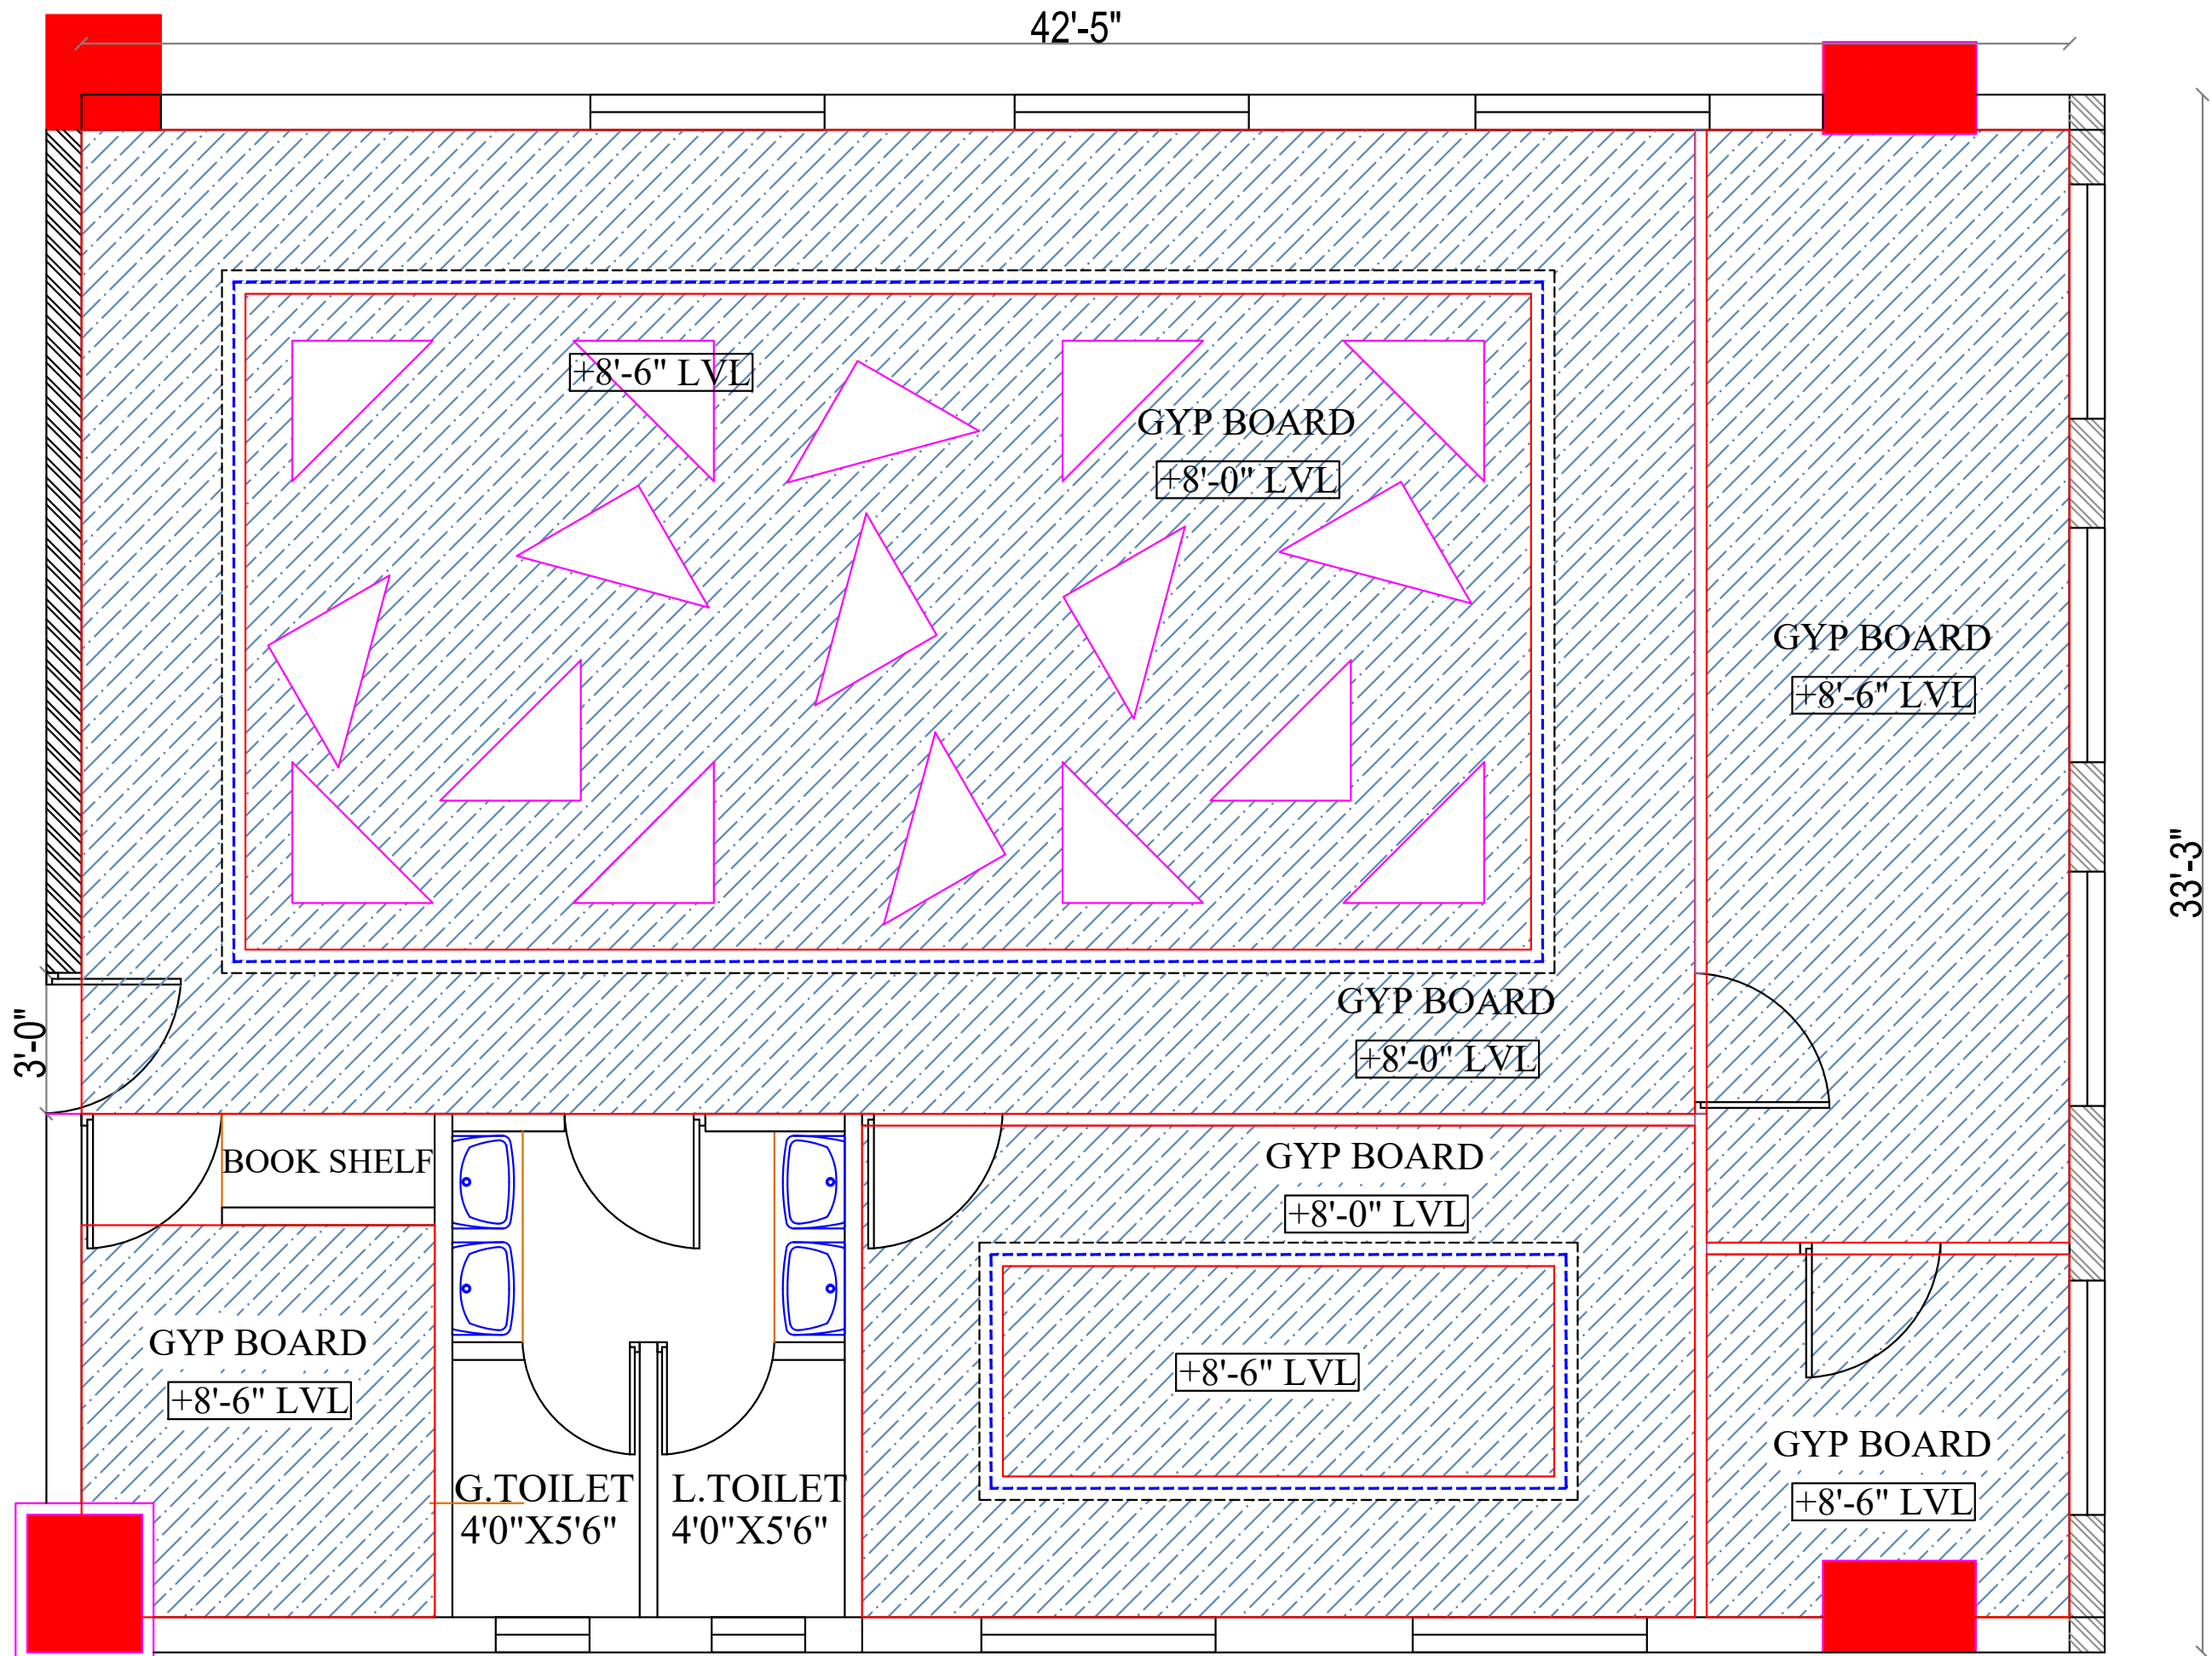


JOB NO	PROJECT TITLE :	PROPOSED INTERIOR DESIGN FOR	DRAWING TITLE :	DESIGN STAGE	SCALE	N.T.S	REV NO	TERR.F-18	ORIENTATION	ARCHITECTS
1739	CANARA BANK CIRCLE OFFICE SAMBAKULAM ROAD, MADURAI.	TERRACE FLOOR DINING LAYOUT	SCHMATIC DRAWING	SCHEME LEVEL	DATE	29-04-2025	DRN	K.D		
			FINAL COPY	R.DATE	03.10.2025	CHKD	K.S			

**TSO DESIGN COMMUNE PVT. LTD.**  
Architects ■ Planners ■ Interior designers  
NEW NO.16,(OLD NO.42), Ground floor, South West Boag Road,  
T.Nagar, Chennai - 600017. Ph : 044 - 4212 9252  
Telefax : 044 - 2435 0493 E-mail : info@tsodc.com

25'-6"

8'-0"

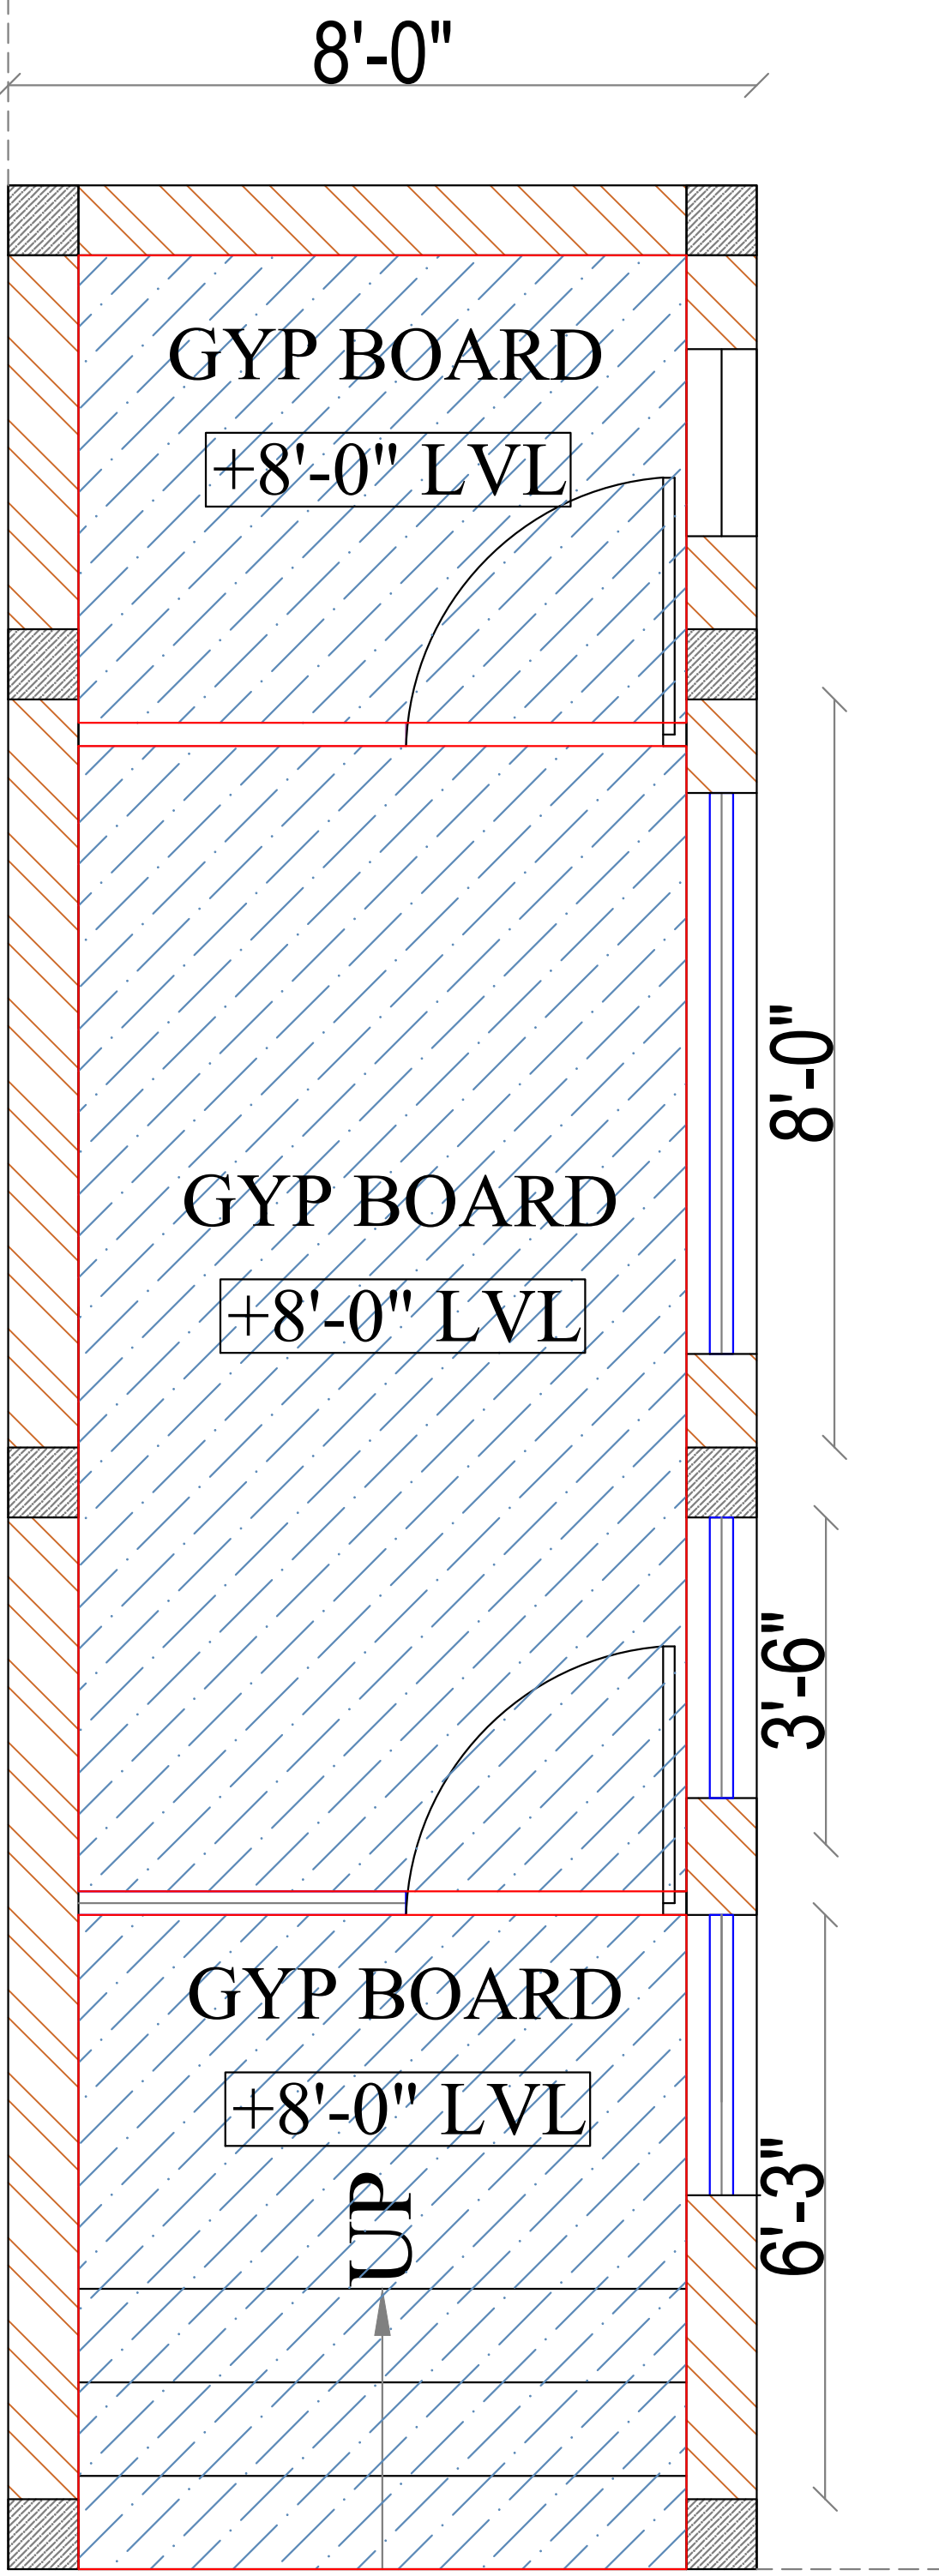

JOB NO

1739

PROJECT TITLE :

PROPOSED INTERIOR DESIGN FOR  
**CANARA BANK CIRCLE OFFICE**  
SAMBAKULAM ROAD, MADURAI.

DRAWING TITLE :

ATM

DRAWING TYPE :

SCHEMATIC DRAWING

DESIGN STAGE

SCHEME LEVEL

FINAL COPY

SCALE

DATE

R.DATE

N.T.S

29-04-2025

03.10.2025

REV/NO

DRN

CHKD

TERR.F-04

 
M.G

K.S


ORIENTATION



ARCHITECTS




**TSO DESIGN COMMUNE PVT. LTD.**  
Architects • Planners • Interior designers  
NEW NO.16, OLD NO.43, Ground floor, South West Bang Road,  
Madrasi, Chennai - 600 026.  
Tel: 044-245 9495 E-mail: info@tsocorp.com

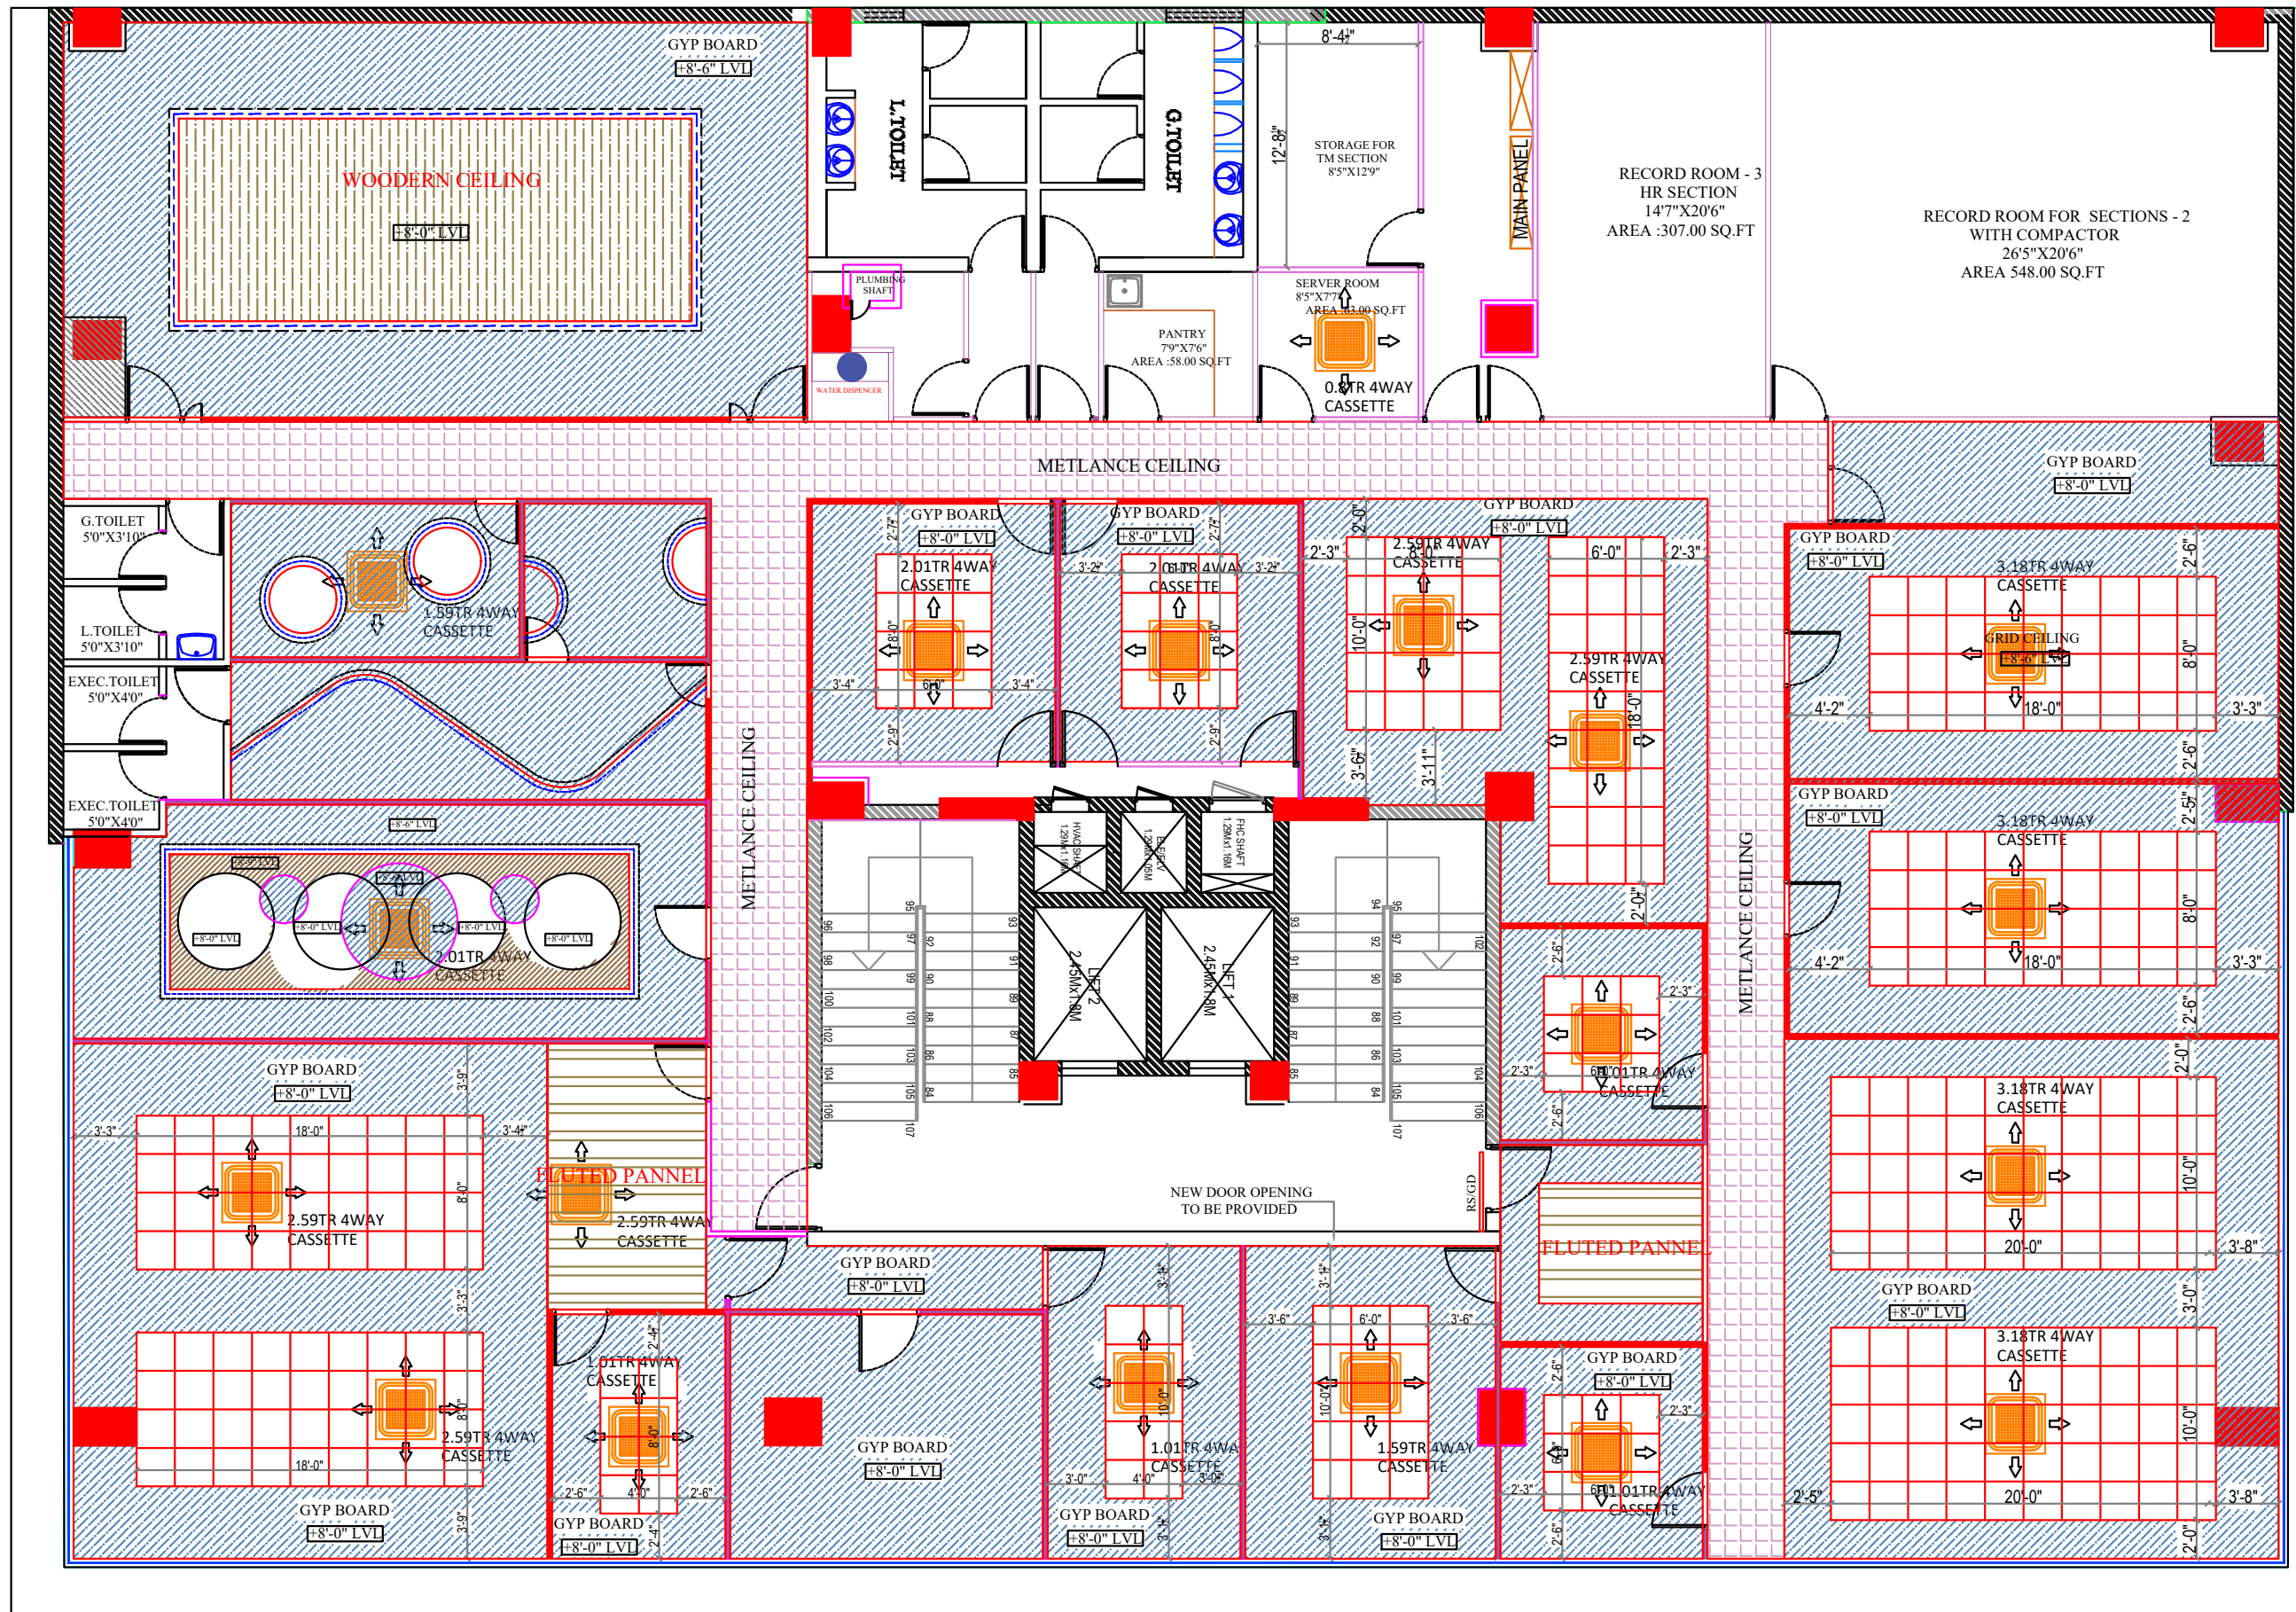

- LOW HEIGHT PARTITION
  - FULL GLAZED PARTITION
  - FULL HEIGHT SOLID PARTITION
- |         |      |
|---------|------|
| ARM MGR | - 1  |
| AGM     | - 2  |
| SM      | - 8  |
| MGR     | - 8  |
| OFFICER | - 43 |

CARPET AREA  
 SECOND FLOOR - 7845.10SQ.FT  
 THIRD FLOOR - 8129.10 SQ.FT  
 TOTAL AREA - 15974.20 SQ.FT  
 (EXCLUDED TOILET & STAIRCASE)

<b>JOB NO</b>	<b>PROJECT TITLE :</b>	PROPOSED INTERIOR DESIGN FOR <b>CANARA BANK CIRCLE OFFICE</b> SAMBAKULAM ROAD, MADURAI.	<b>DRAWING TITLE :</b>	SECOND FLOOR - AC LAYOUT	<b>DESIGN STAGE</b>	SCALE	N.T.S	REV NO	REV - 18	ORIENTATION	<b>ARCHITECTS</b>
<b>1739</b>			<b>DRAWING TYPE :</b>	WORKING DRAWING	<div style="border: 1px solid black; width: 20px; height: 10px; display: inline-block;"></div> SCHEME LEVEL <div style="border: 1px solid black; width: 20px; height: 10px; background-color: gray; display: inline-block;"></div> FINAL COPY	DATE	29-04-2025	DRN	K.D	N	
						R.DATE	03.10.2025	CHKD	K.S		

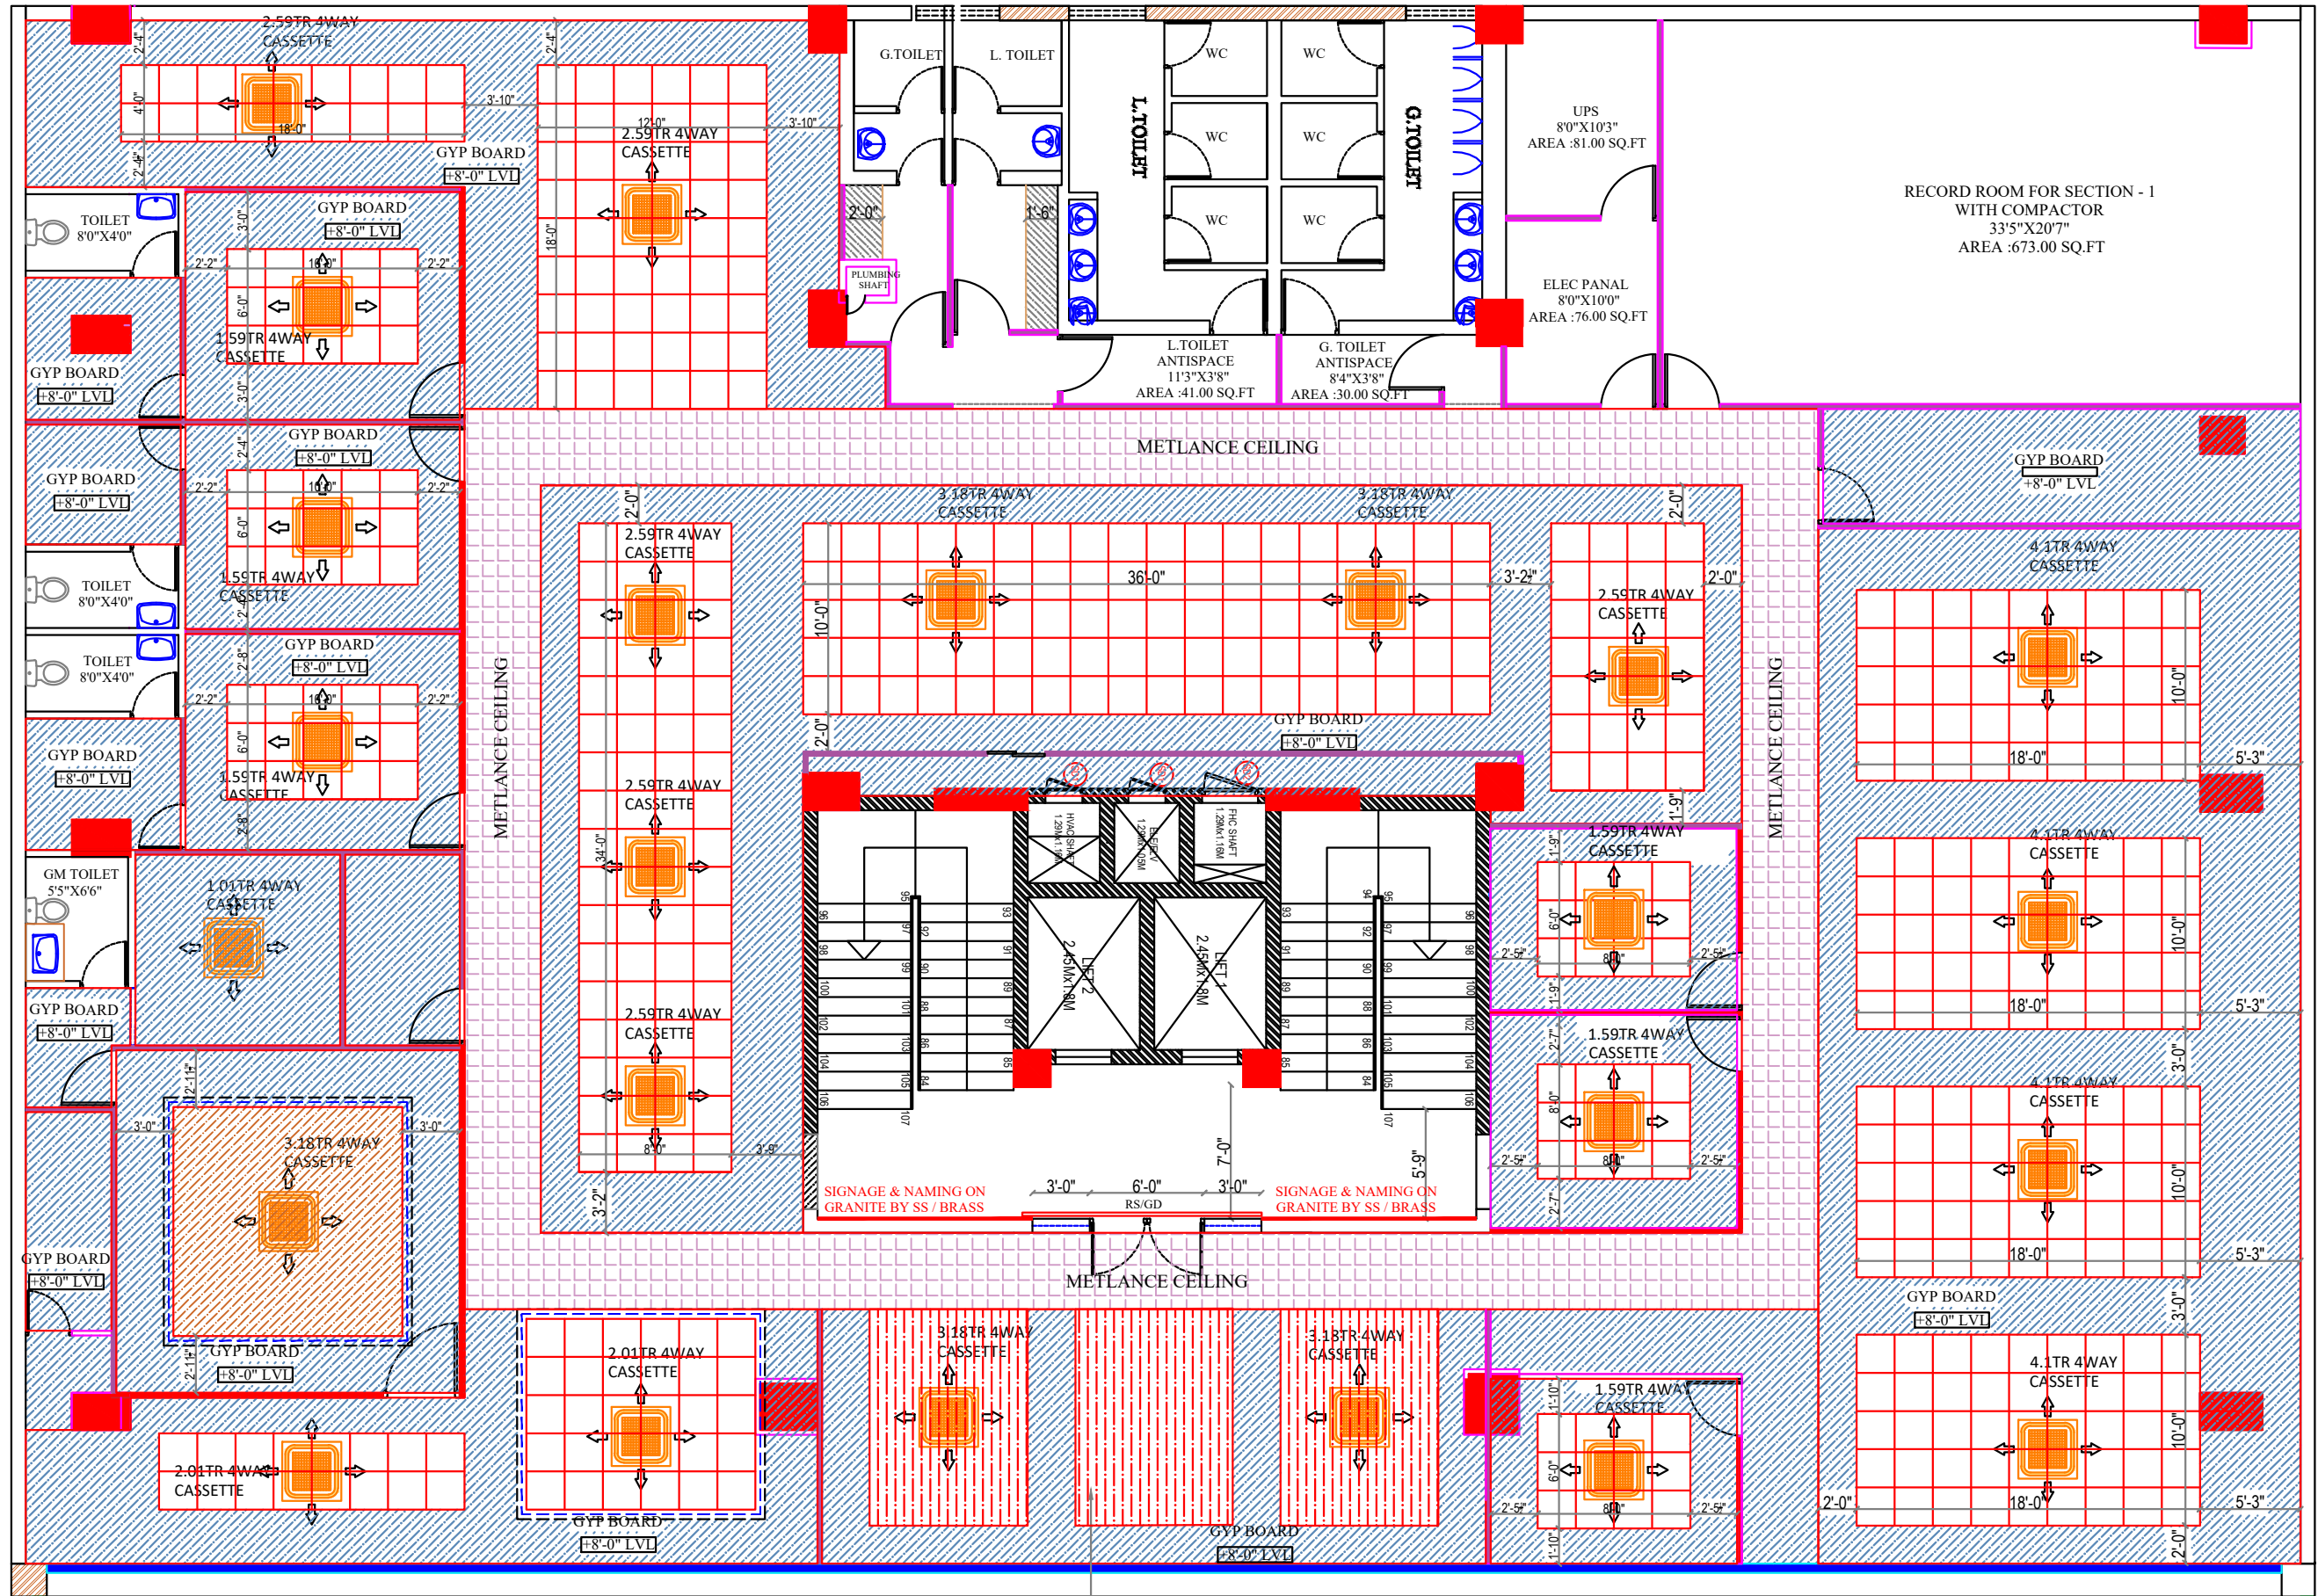

RECORD ROOM FOR SECTION - 1  
WITH COMPACTOR  
33'5"X20'7"  
AREA : 673.00 SQ.FT

UPS  
8'0"X10'3"  
AREA : 81.00 SQ.FT

ELEC PANAL  
8'0"X10'0"  
AREA : 76.00 SQ.FT

METLANCE CEILING

METLANCE CEILING

STRETCH CEILING WITH  
BACK LED LIGHT

- ▬ LOW HEIGHT PARTITION
- ▬ FULL GLAZED PARTITION
- ▬ FULL HEIGHT SOLID PARTITION

GM	- 1
DGM	- 3
DM	- 5
AGM	- 2
SM	- 12
MGR	- 6
OFFICER	- 52

CARPET AREA  
SECOND FLOOR - 7845.10SQ.FT  
THIRD FLOOR - 8129.10 SQ.FT  
TOTAL AREA - 15974.20 SQ.FT  
(EXCLUDED TOILET & STAIRCASE)

JOB NO <b>1739</b>	PROJECT TITLE : <b>PROPOSED INTERIOR DESIGN FOR CANARA BANK CIRCLE OFFICE SAMBAKULAM ROAD, MADURAI.</b>	DRAWING TITLE :	THIRD FLOOR - AC LAYOUT	DESIGN STAGE	SCALE	N.T.S	REV NO	REV - 18	ORIENTATION	ARCHITECTS <b>T.S.O DESIGN COMMUNE PVT. LTD.</b> Architects ■ Planners ■ Interior designers
		DRAWING TYPE :	WORKING DRAWING		DATE	29-04-2025	DRN	K.D		
					R.DATE	03.10.2025	CHKD	K.S		



25'-6"

8'-0"

GYP BOARD

+8'-0" LVL

0.8TR NONVRV  
SPLIT

GYP BOARD

+8'-0" LVL

0.8TR NONVRV  
SPLIT

GYP BOARD

+8'-0" LVL

UP

8'-0"

3'-6"

6'-3"

JOB NO

1739

PROJECT TITLE :

CANARA BANK CIRCLE OFFICE

SAMBAKULAM ROAD, MADURAI.

PROPOSED INTERIOR DESIGN FOR

DRAWING TITLE : ATM

DRAWING TYPE : SCHEMATIC DRAWING

DESIGN STAGE

SCHEME LEVEL

FINAL COPY

SCALE

DATE

R.DATE

REV/NO

DRN

 
CHKD

TERR.F-04


M.G

K.S

ORIENTATION



ARCHITECTS

 

**TSO DESIGN COMMUNE PVT. LTD.**  
Architects • Planners • Interior designers  
NEW NO.16, OLD NO.43, Ground floor, South West Bang Road,  
Chennai - 600 026.  
Phone: 044-245 9495 E-mail: info@tsocdm.com




LEGEND	
	2 Nos.6A UPS Power Socket Outlet
	2 Nos.6A RAW Power Socket Outlet
	1 Nos.6A Raw Power Socket Outlet
	Modular Type 25/32A A/C Socket
	6/16ARaw Power Socket Outlet
	Data Socket
	Telephone Outlet
	6A AC Power Socket @CEILING LVL.
	Distribution Board

JOB NO <b>1739</b>	PROJECT TITLE : <b>PROPOSED INTERIOR DESIGN FOR CANARA BANK CIRCLE OFFICE SAMBAKULAM ROAD, MADURAI.</b>	DRAWING TITLE :	POWER LAYOUT - SECOND FLOOR	DESIGN STAGE	SCALE	N.T.S	REV NO	REV - 04	ORIENTATION	ARCHITECTS <b>TSO DESIGN COMMUNE PVT. LTD.</b> Architects ■ Planners ■ Interior designers NEW NO.16,(OLD NO.42), Ground floor, South West Boag Road, T.Nagar, Chennai - 600017. Ph : 044 - 4212 9252 Telefax : 044 - 2435 0493 E-mail : info@tsoc.com
		DRAWING TYPE :	WORKING DRAWING		DATE	29-04-2025	DRN	HARI G		
					R.DATE	26.10.2025	CHKD	G.G		



LEGEND	
	2 Nos.6A UPS Power Socket Outlet
	2 Nos.6A RAW Power Socket Outlet
	1 Nos.6A Raw Power Socket Outlet
	Modular Type 25/32A A/C Socket
	6/16ARaw Power Socket Outlet
	Data Socket
	Telephone Outlet
	6A AC Power Socket @CEILING LVL.
	Distribution Board

JOB NO	PROJECT TITLE :	PROPOSED INTERIOR DESIGN FOR	DRAWING TITLE :	DESIGN STAGE	SCALE	N.T.S	REV NO	REV - 04	ORIENTATION	ARCHITECTS <b>TSO DESIGN COMMUNE PVT. LTD.</b> Architects ■ Planners ■ Interior designers NEW NO.16,(OLD NO.42), Ground floor, South West Boag Road, T.Nagar, Chennai - 600017. Ph : 044 - 4212 9252 Telefax : 044 - 2435 0493 E-mail : info@tsoc.com
<b>1739</b>		<b>CANARA BANK CIRCLE OFFICE</b>	POWER LAYOUT - THIRD FLOOR	SCHEME LEVEL	DATE	29-04-2025	DRN	HARI G		
		SAMBAKULAM ROAD, MADURAI.	DRAWING TYPE :	FINAL COPY	R.DATE	26.10.2025	CHKD	G.G		

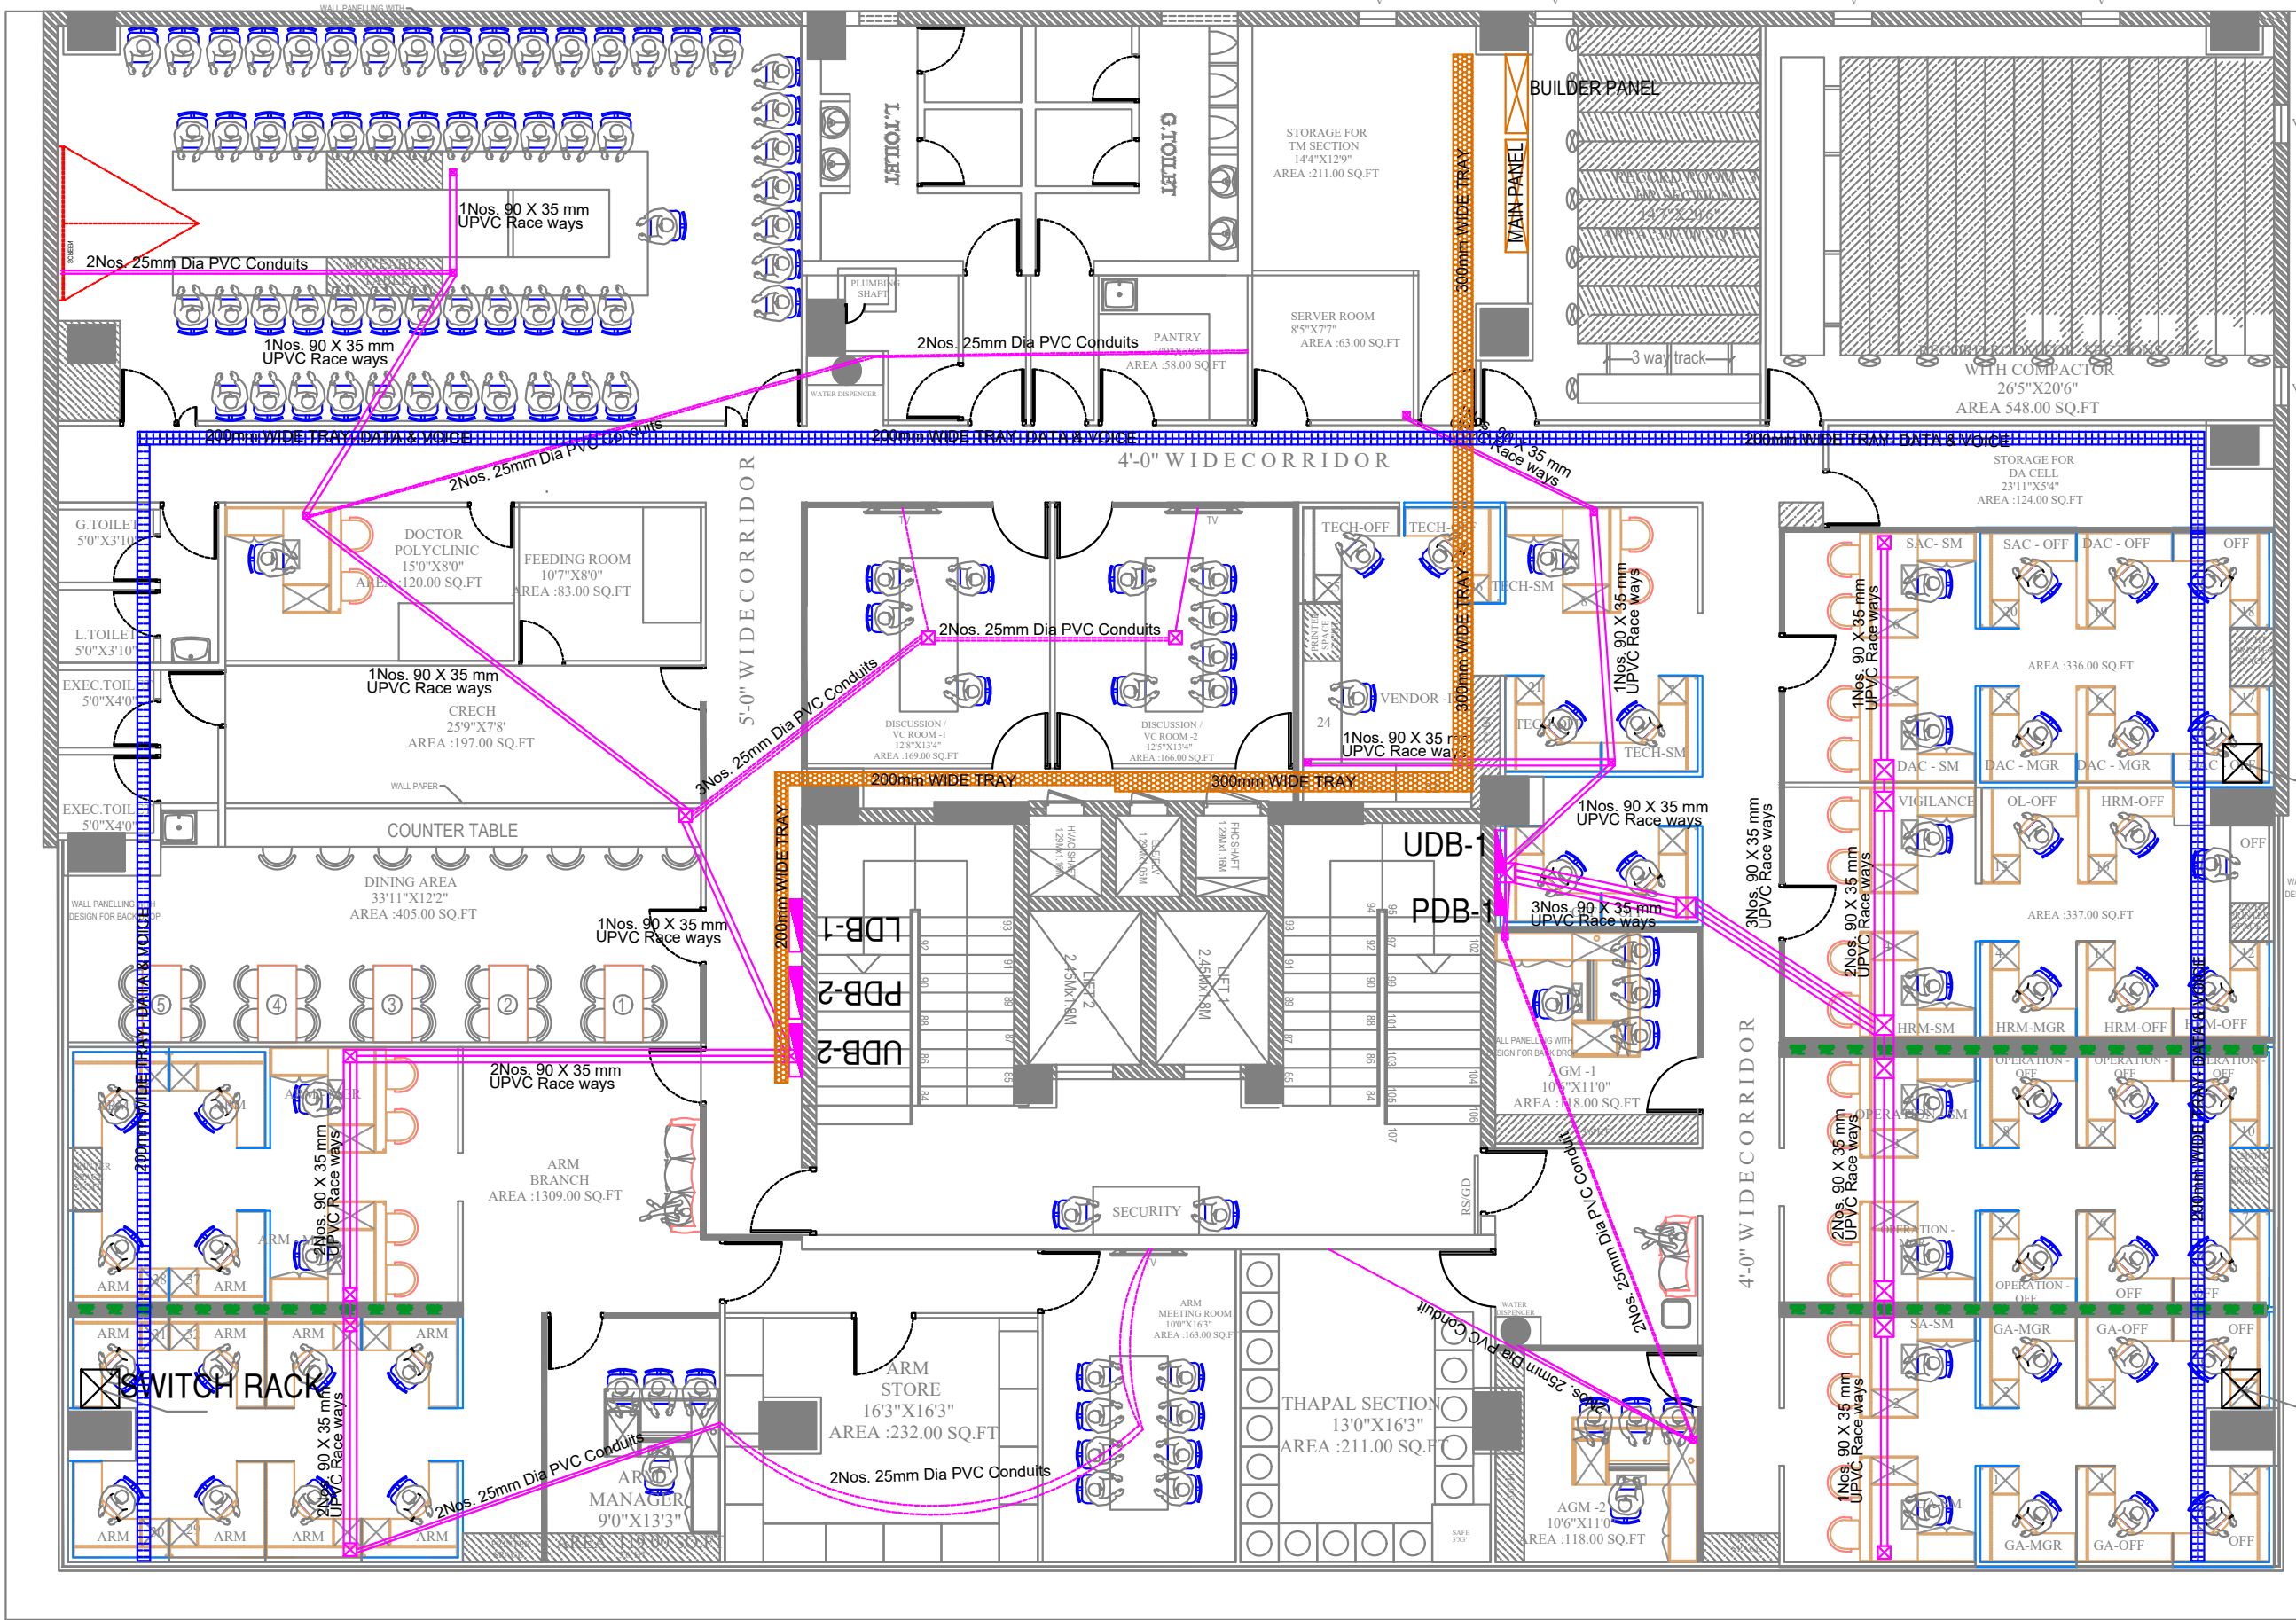


SWITCH RACK

SWITCH RACK


LEGEND	
	RAW & UPS POWER RACEWAYS
	FLOOR JUNCTION BOXES
	25MM DIA PVC CONDUITS
	POWER CABLE TRAY
	DATA & VOICE CABLE TRAY

JOB NO <b>1739</b>	PROJECT TITLE : <b>PROPOSED INTERIOR DESIGN FOR CANARA BANK CIRCLE OFFICE SAMBAKULAM ROAD, MADURAI.</b>	DRAWING TITLE : FLOOR RACEWAYS & CABLE TRAY LAYOUT SECOND FLOOR	DESIGN STAGE SCHEME LEVEL	SCALE N.T.S	REV NO REV - 04	ORIENTATION N	ARCHITECTS <b>T.S.O DESIGN COMMUNE PVT. LTD.</b> Architects ■ Planners ■ Interior designers NEW NO.16,(OLD NO.42), Ground floor, South West Boag Road, T.Nagar, Chennai - 600017. Ph : 044 - 4212 9252 Telefax : 044 - 2435 0490 E-mail : info@tsoc.com
		DRAWING TYPE : WORKING DRAWING	FINAL COPY	DATE 29-04-2025	CHKD G.G		

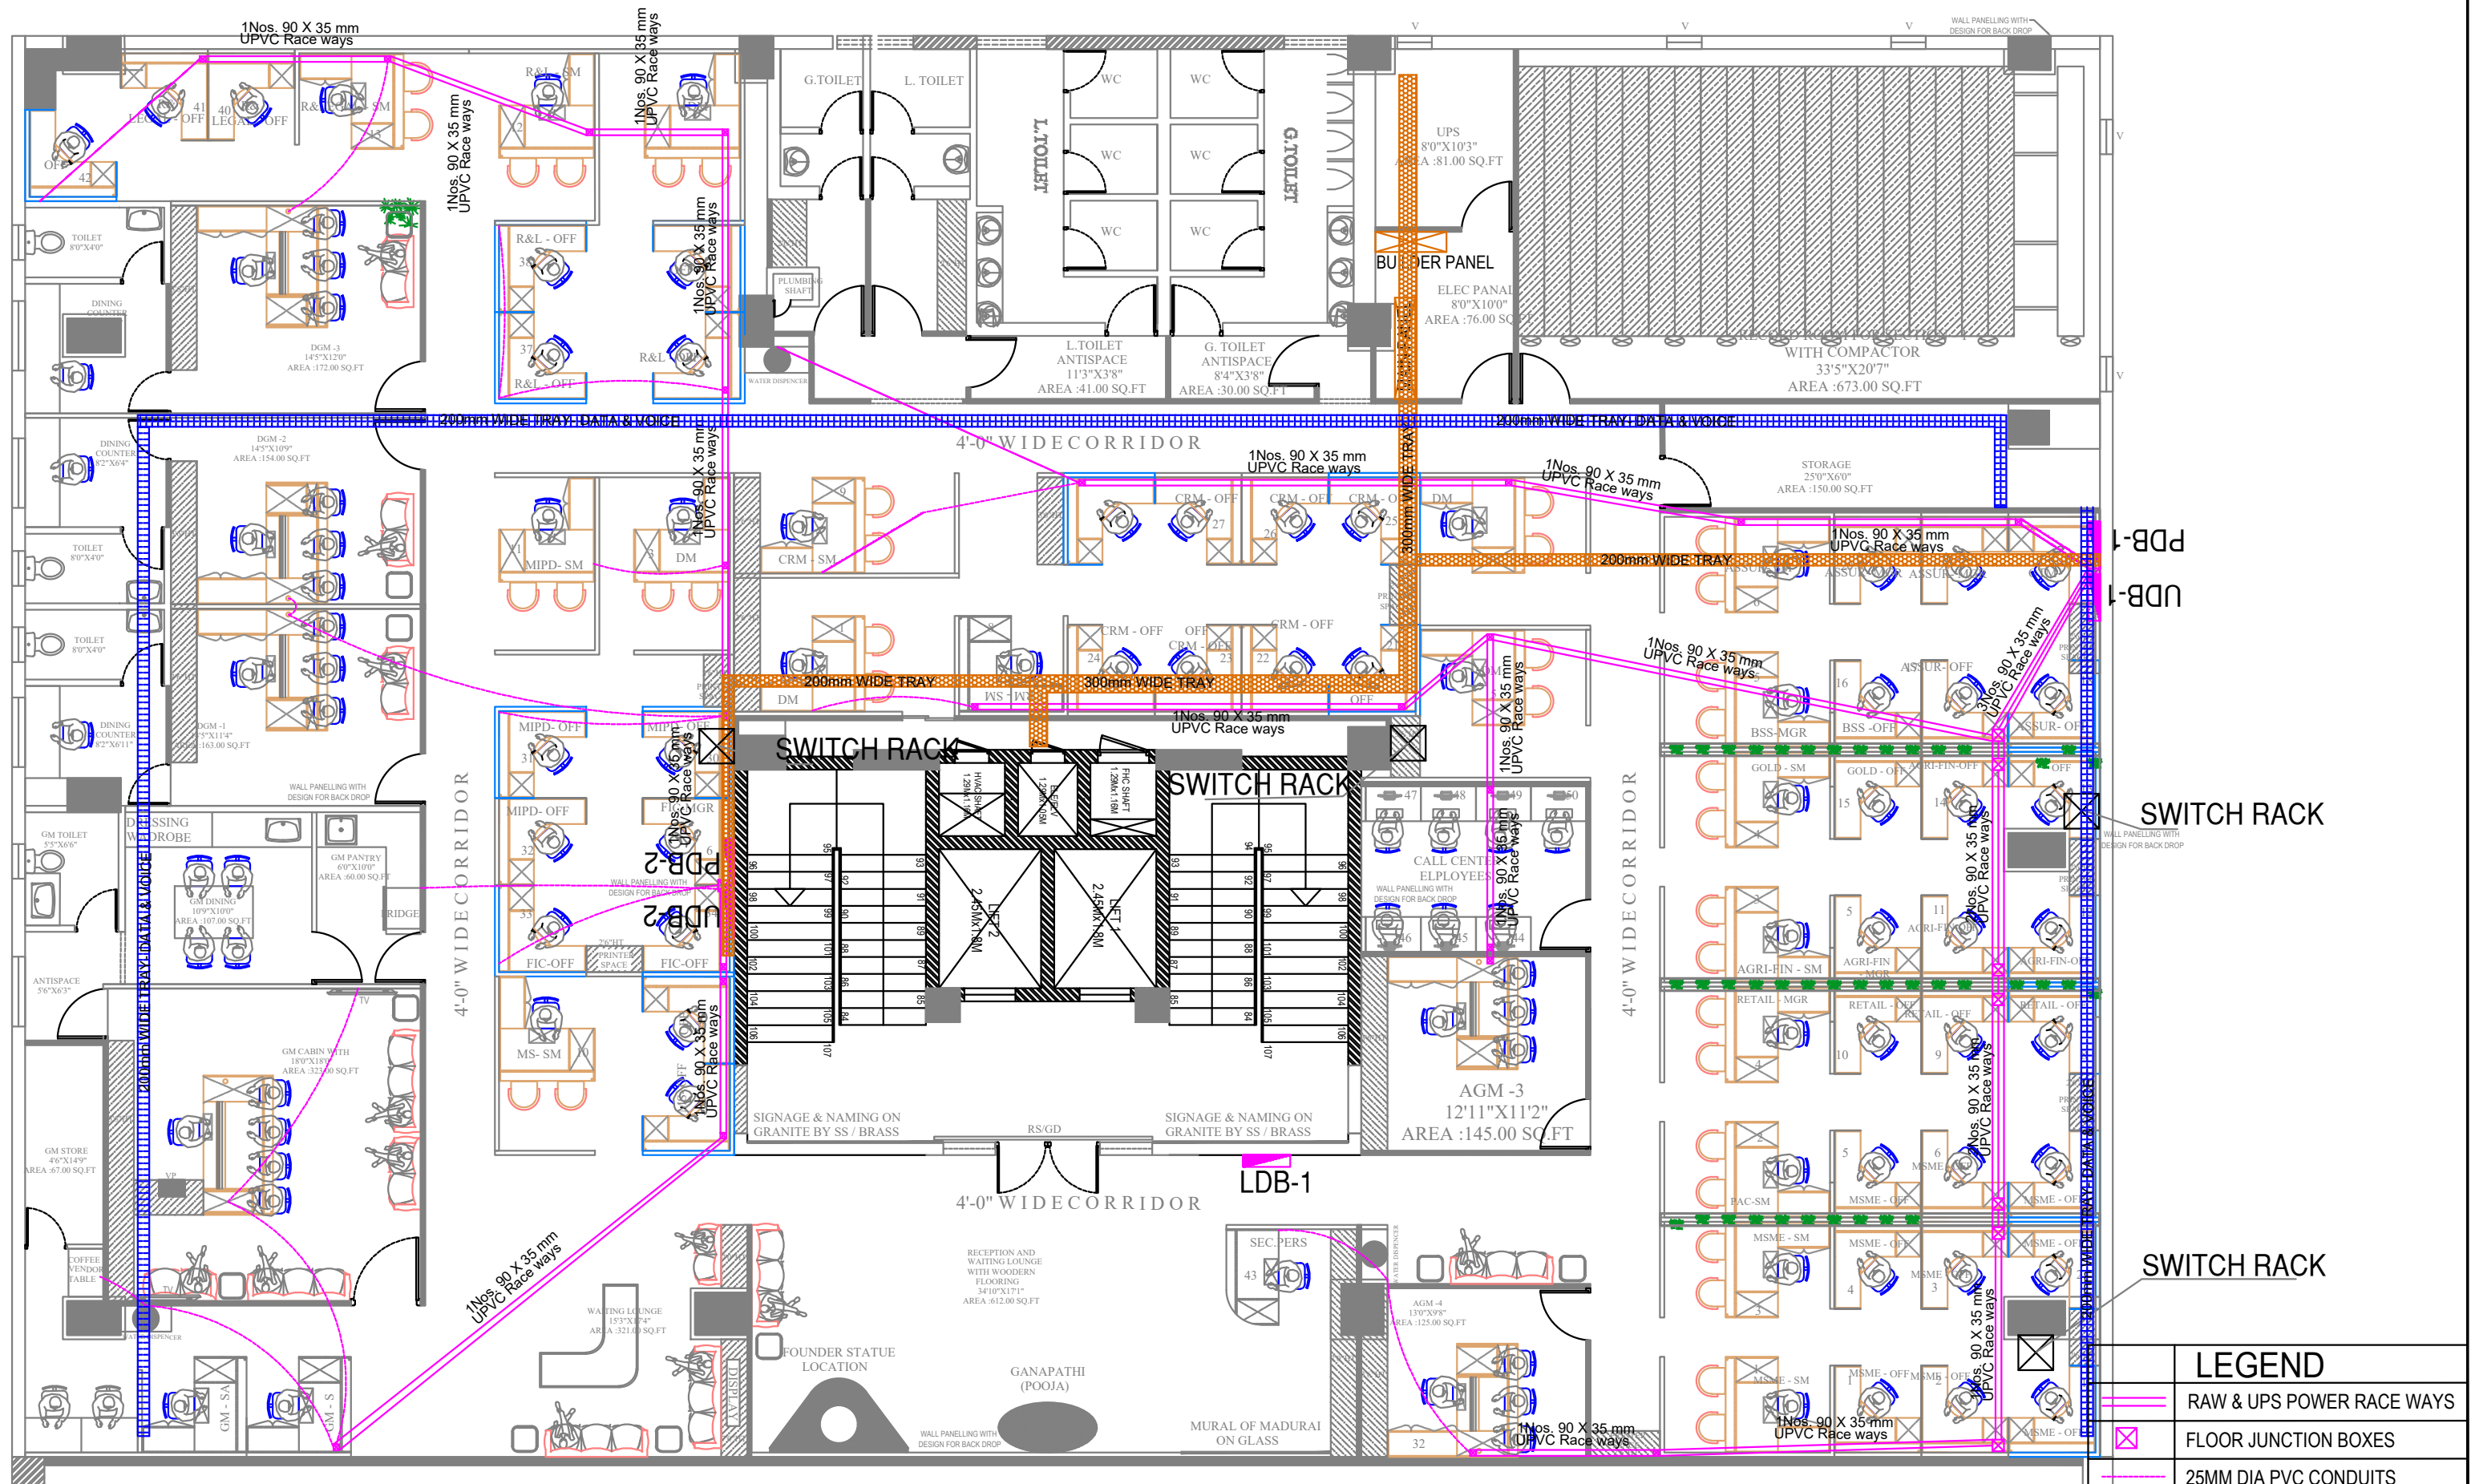

LEGEND	
	RAW & UPS POWER RACEWAYS
	FLOOR JUNCTION BOXES
	25MM DIA PVC CONDUITS
	POWER CABLE TRAY
	DATA & VOICE CABLE TRAY


JOB NO	PROJECT TITLE :	PROPOSED INTERIOR DESIGN FOR	DRAWING TITLE :	DESIGN STAGE	SCALE	N.T.S	REV NO	REV - 04	ORIENTATION	ARCHITECTS
1739	<b>CANARA BANK CIRCLE OFFICE</b>		FLOOR RACEWAYS & CABLE TRAY LAYOUT	SCHEME LEVEL	DATE	29-04-2025	DRN	HARI G		
	SAMBAKULAM ROAD, MADURAI.		THIRD FLOOR	FINAL COPY	R.DATE	26.10.2025	CHKD	G.G		
			DRAWING TYPE :	WORKING DRAWING						<b>TSO DESIGN COMMUNE PVT. LTD.</b> Architects ■ Planners ■ Interior designers NEW NO.16,(OLD NO.42), Ground floor, South West Boag Road, T.Nagar, Chennai - 600017. Ph : 044 - 4212 9252 Telefax : 044 - 2435 0493 E-mail : info@tsodc.com

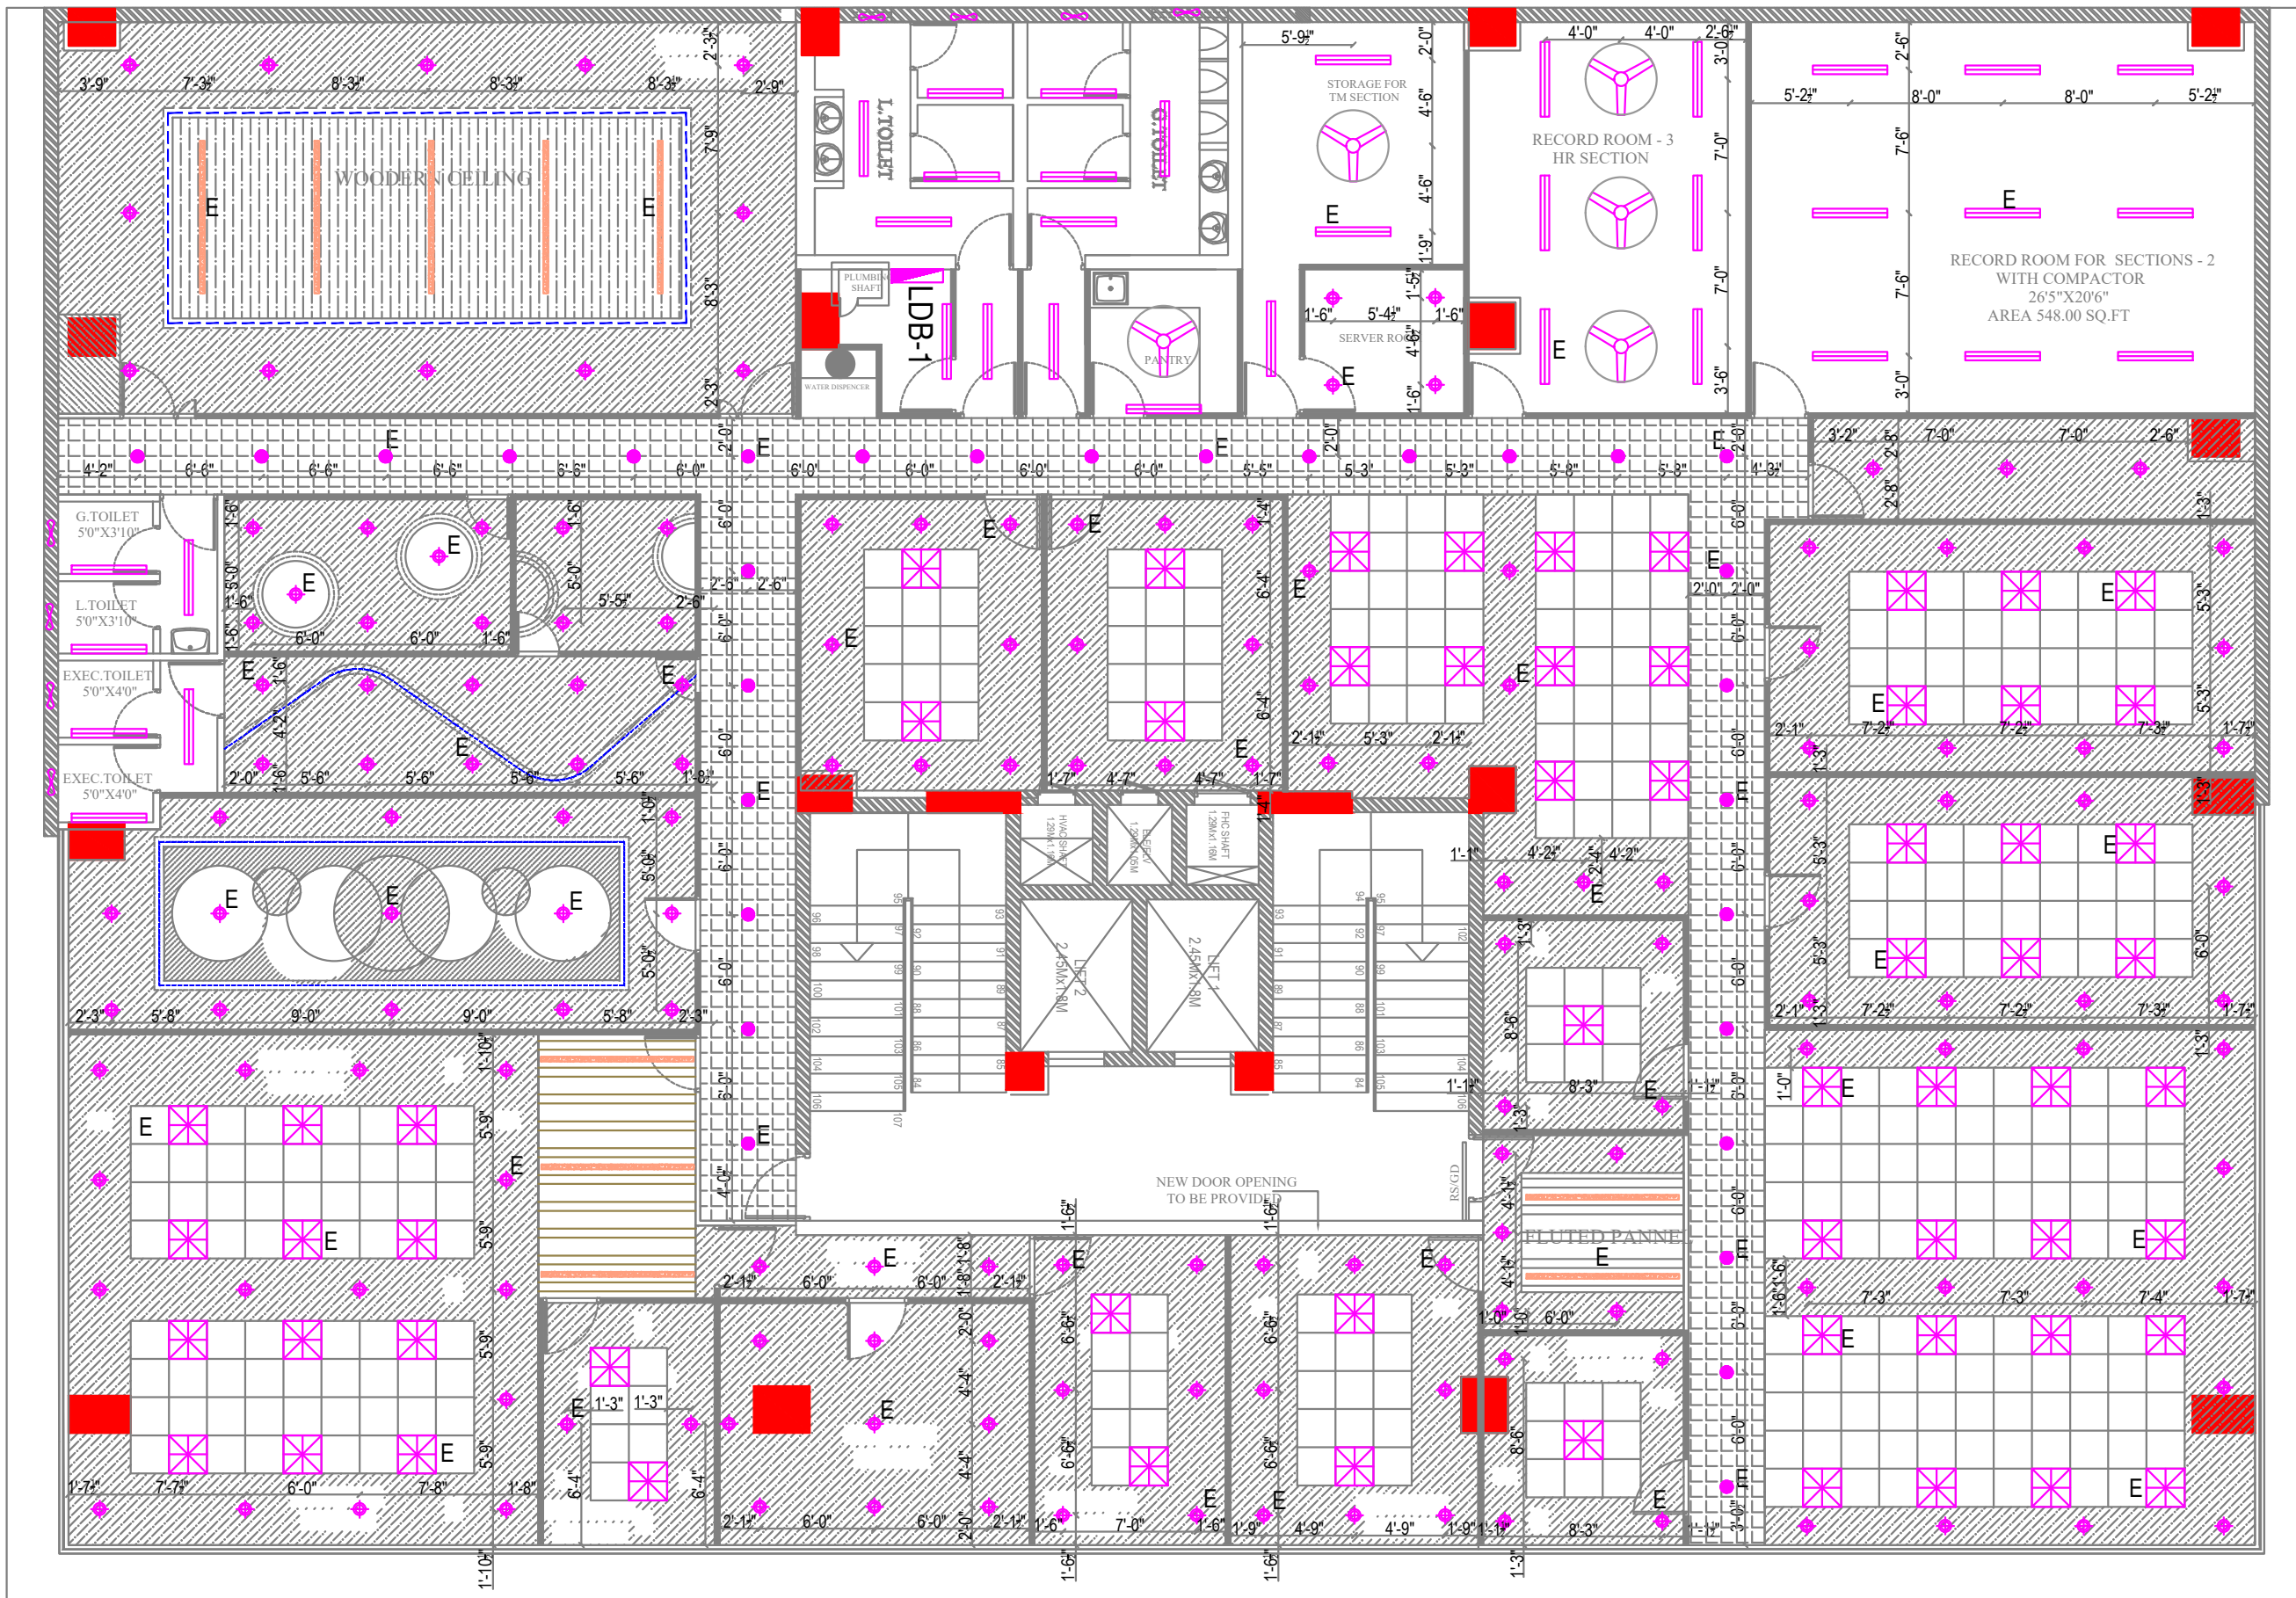

**LEGEND**

	2' X 2' - 36 W LED FITTING
	15 W LED DOWN LIGHT
	4' - 1 x 20 W LED BATTEN FITTING WITH BATTERY BACKUP
	WALL MOUNTING FAN
	CEILING FAN
	EXHAUST FAN
	EMERGENCY LIGHT
	STRIP LIGHT
	LINEAR SUSPENDED LIGHT
	SUSPENDED LIGHT - 20W

JOB NO	PROJECT TITLE :	PROPOSED INTERIOR DESIGN FOR	LIGHTING LAYOUT - SECOND FLOOR	DESIGN STAGE	SCALE	N.T.S	REV NO	03	ORIENTATION	ARCHITECTS <b>TSO DESIGN COMMUNE PVT. LTD.</b> Architects ■ Planners ■ Interior Designers <small>NEW NO.16,(OLD NO.42), Ground floor, South West Boag Road, T.Nagar, Chennai - 600017. Ph : 044 - 4212 9252 Telefax : 044 - 2435 0493 E-mail : info@tdc.com</small>
<b>1739</b>	<b>CANARA BANK CIRCLE OFFICE</b>		SCHMATIC DRAWING	SCHEME LEVEL	DATE	29-04-2025	DRN	HARI G		
	SAMBAKULAM ROAD, MADURAI.			FINAL COPY	R.DATE	27.09.2025	CHKD	G.G		

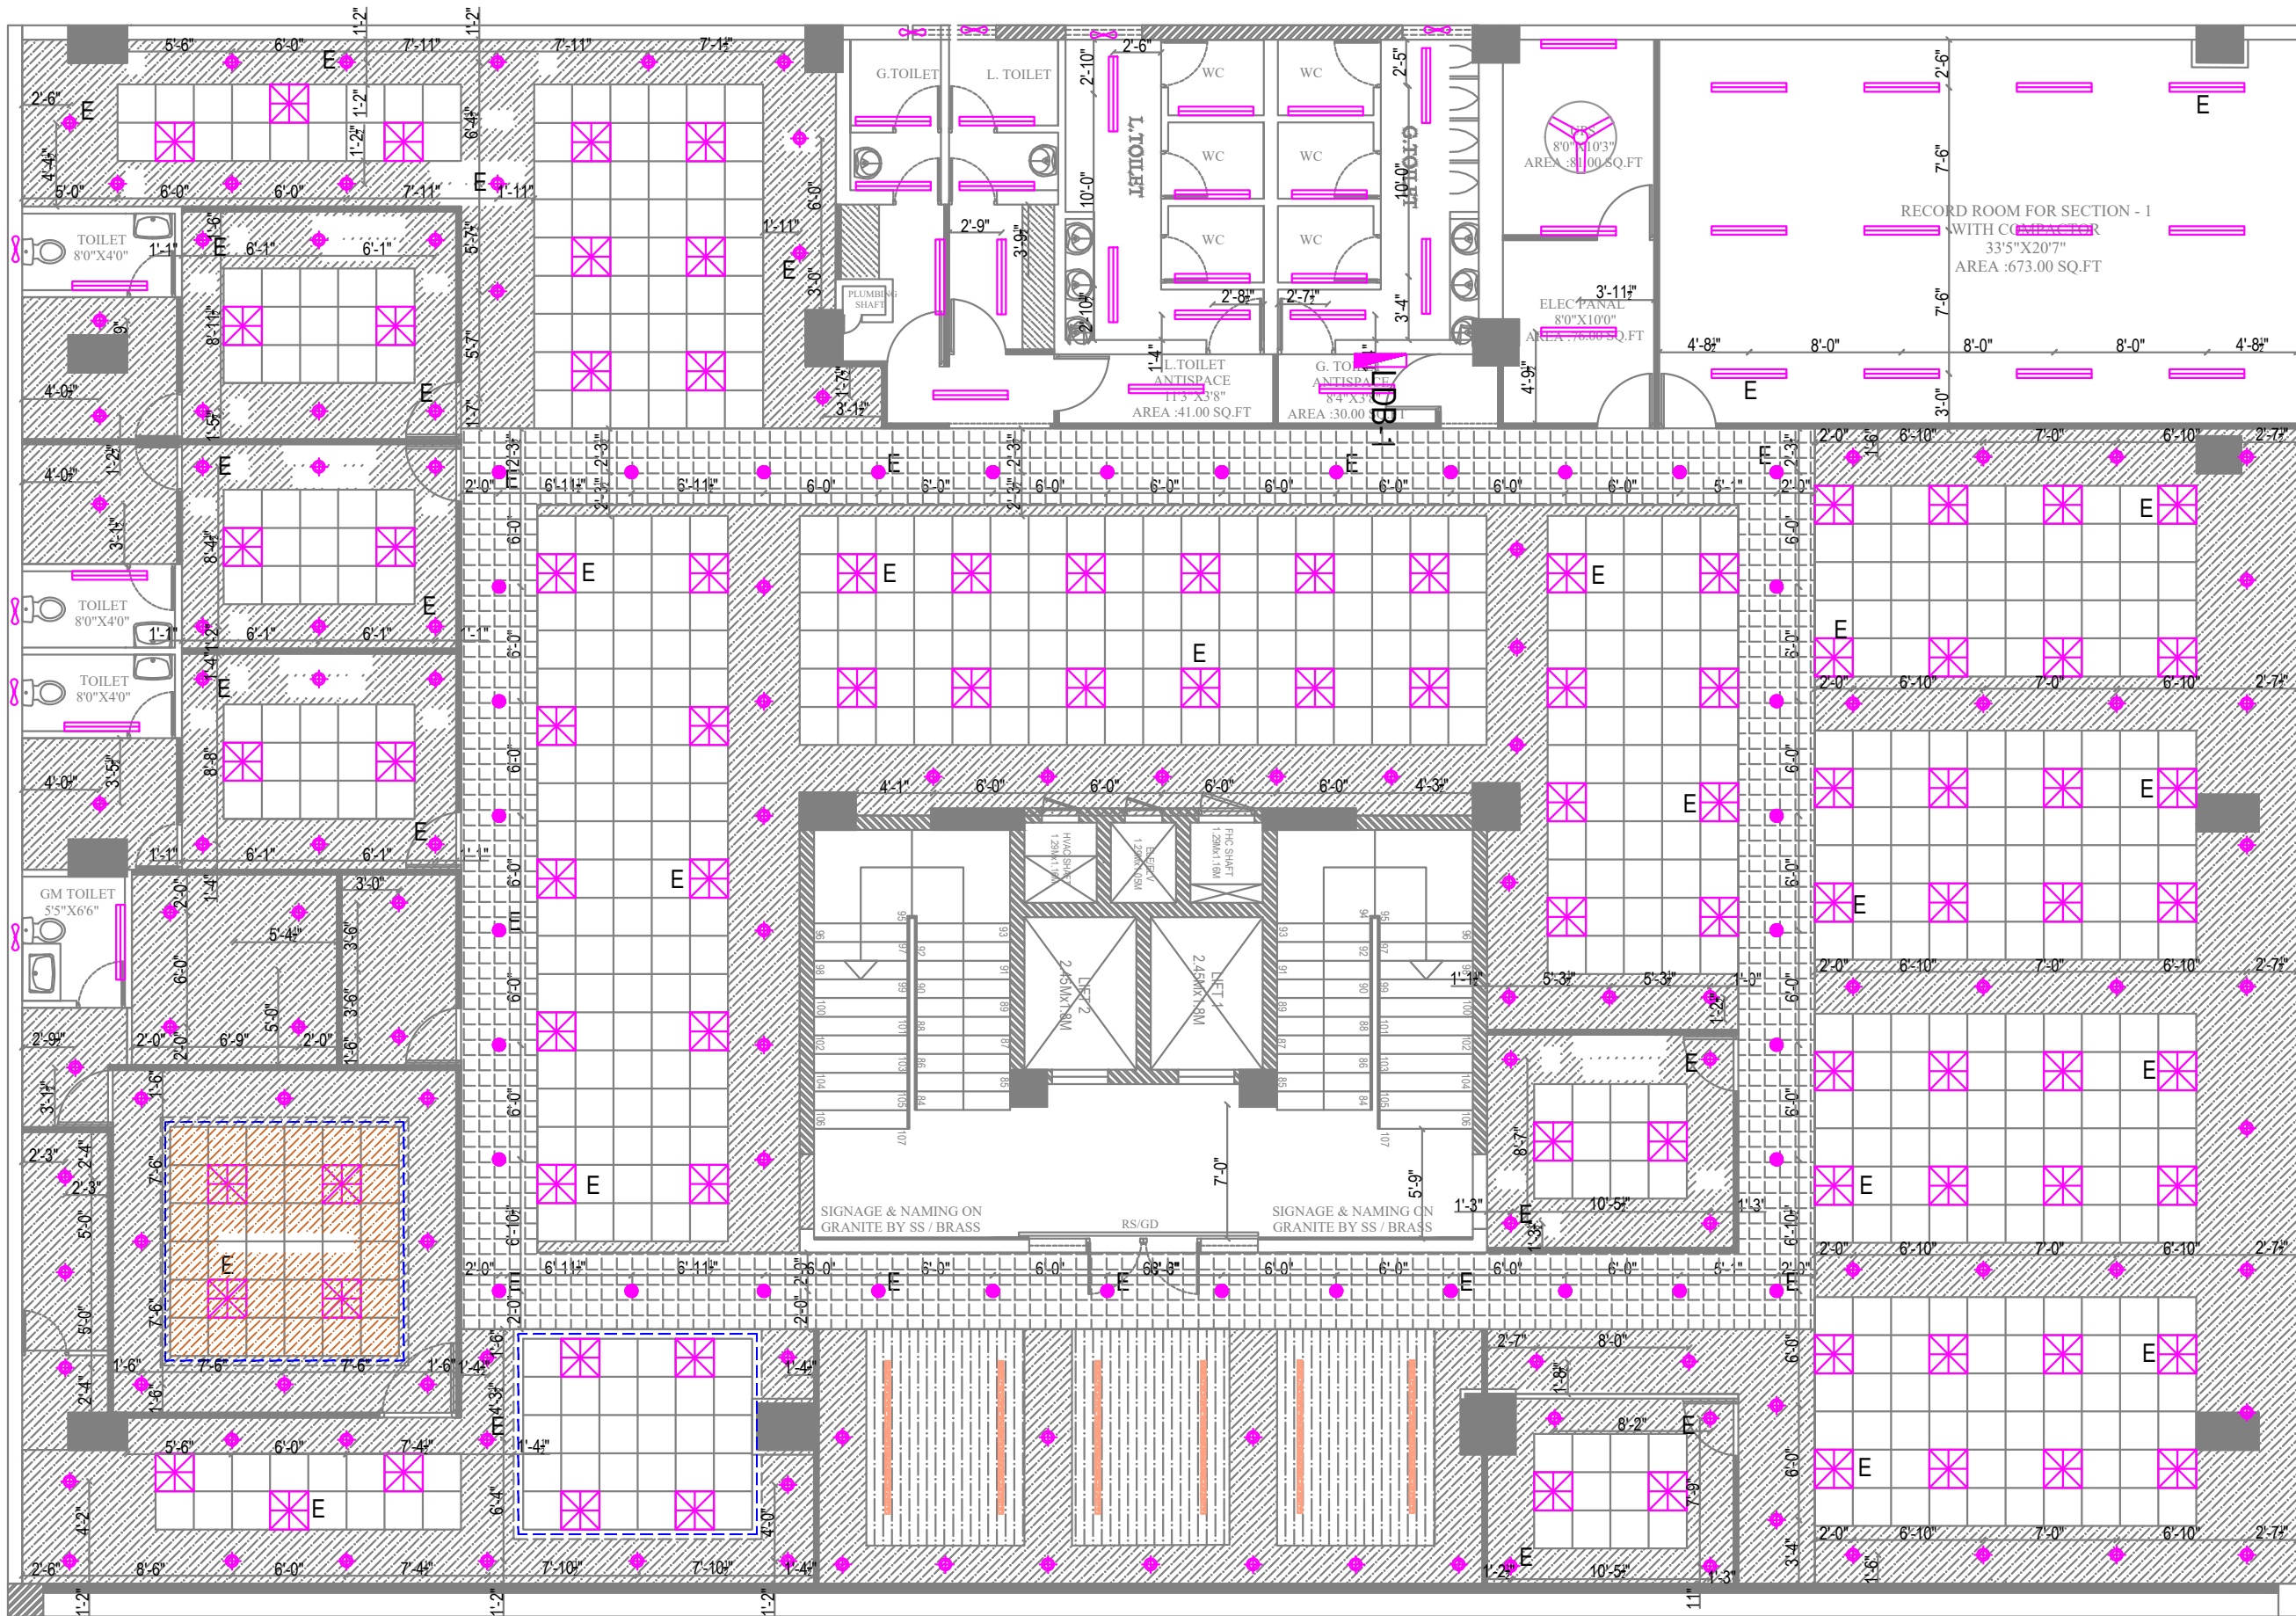


**LEGEND**

	2' X 2' - 36 W LED FITTING
	15 W LED DOWN LIGHT
	4' - 1 x 20 W LED BATTEN FITTING WITH BATTERY BACKUP
	WALL MOUNTING FAN
	CEILING FAN
	EXHAUST FAN
	EMERGENCY LIGHT
	STRIP LIGHT
	LINEAR SUSPENDED LIGHT
	SUSPENDED LIGHT - 20W


<b>JOB NO</b>	<b>PROJECT TITLE :</b>	PROPOSED INTERIOR DESIGN FOR <b>CANARA BANK CIRCLE OFFICE</b> SAMBAKULAM ROAD, MADURAI.	<b>DRAWING TITLE :</b>	LIGHTING LAYOUT - THIRD FLOOR	<b>DESIGN STAGE</b>	SCALE	N.T.S	REV NO	03	<b>ORIENTATION</b>
<b>1739</b>			<b>DRAWING TYPE :</b>	SCHEMATIC DRAWING		DATE	29-04-2025	DRN	HARI G	
				FINAL COPY		R.DATE	27.09.2025	CHKD	G.G	
<b>ARCHITECTS</b>  <b>TSO DESIGN COMMUNE PVT. LTD.</b> Architects ■ Planners ■ Interior designers <small>NEW NO.16,(OLD NO.42), Ground floor, South West Boag Road,          T.Nagar, Chennai - 600017. Ph : 044 - 4212 9252          Telefax : 044 - 2435 0493 E-mail : info@tsodc.com</small>										



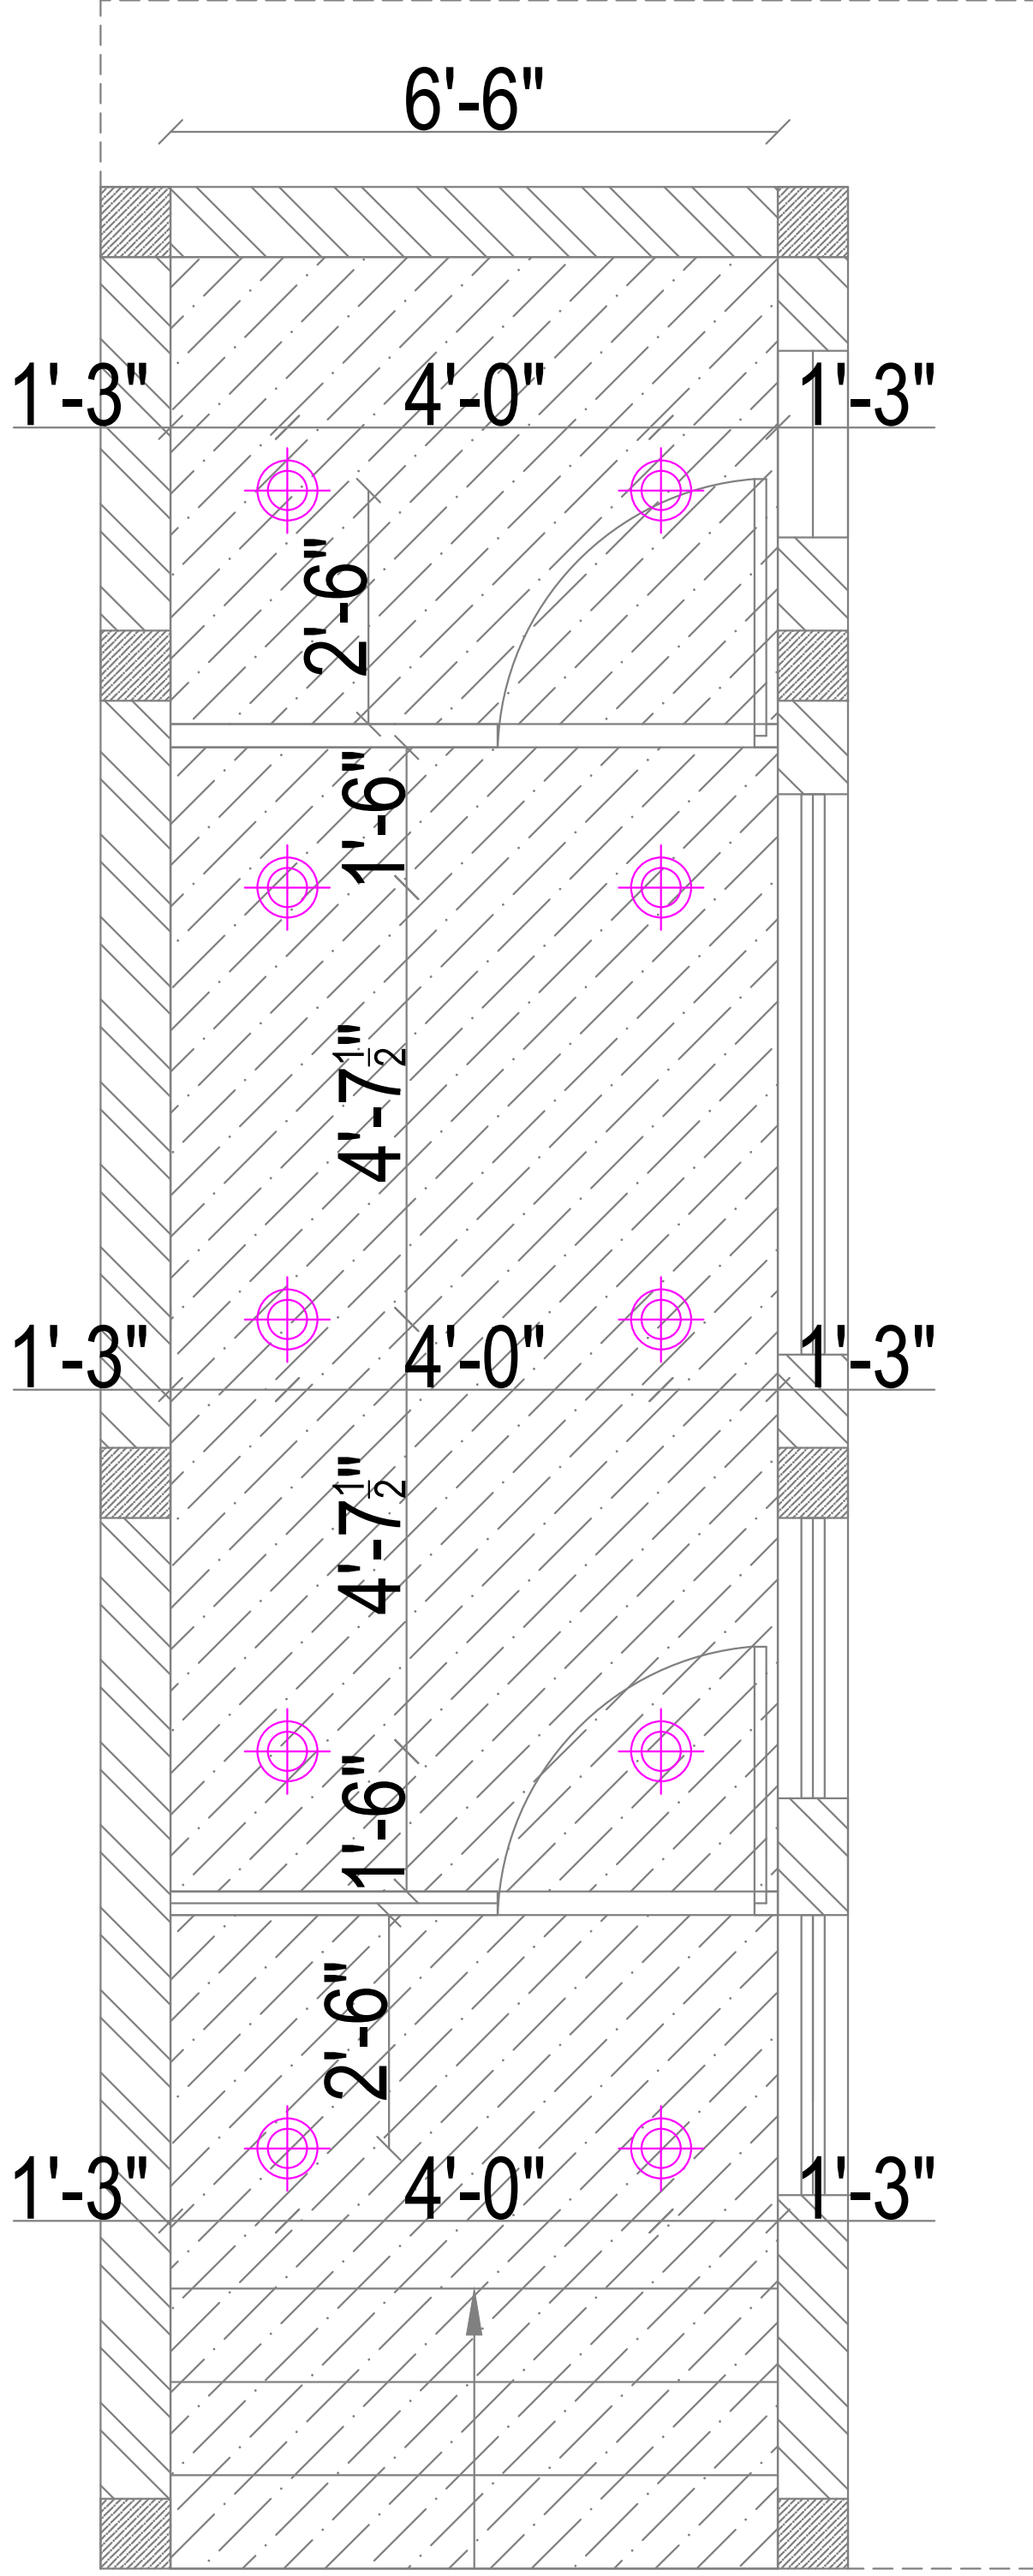


LEGEND	
	15 W LED DOWN LIGHT
	4' - 1 x 20 W LED BATTEN FITTING WITH BATTERY BACKUP
	CEILING FAN
	EXHAUST FAN
	STRIP LIGHT

JOB NO <b>1739</b>	PROJECT TITLE : <b>CANARA BANK CIRCLE OFFICE</b> SAMBAKULAM ROAD, MADURAI.		DRAWING TITLE : LIGHTING LAYOUT - ATM	DRAWING TYPE : SCHEMATIC DRAWING	DESIGN STAGE SCHEME LEVEL FINAL COPY	SCALE	N.T.S	REV/NO	01	ORIENTATION	
	DATE	29-04-2025				DRN	HARI G	R.DATE	27.09.2025	CHKD	
PROPOSED INTERIOR DESIGN FOR			ARCHITECTS		ARCHITECTS		ARCHITECTS		<b>TSD DESIGN COMMUNE PVT. LTD.</b> Architects • Planners • Interior designers NEW NO.16, GILD NO.421, Ground floor, South West Bang Road, Angkor, Coimbatore - 641 001, India. Ph: 944 722 2626, Toll-free: 044-2435 9495 E-mail: info@tsd.com		

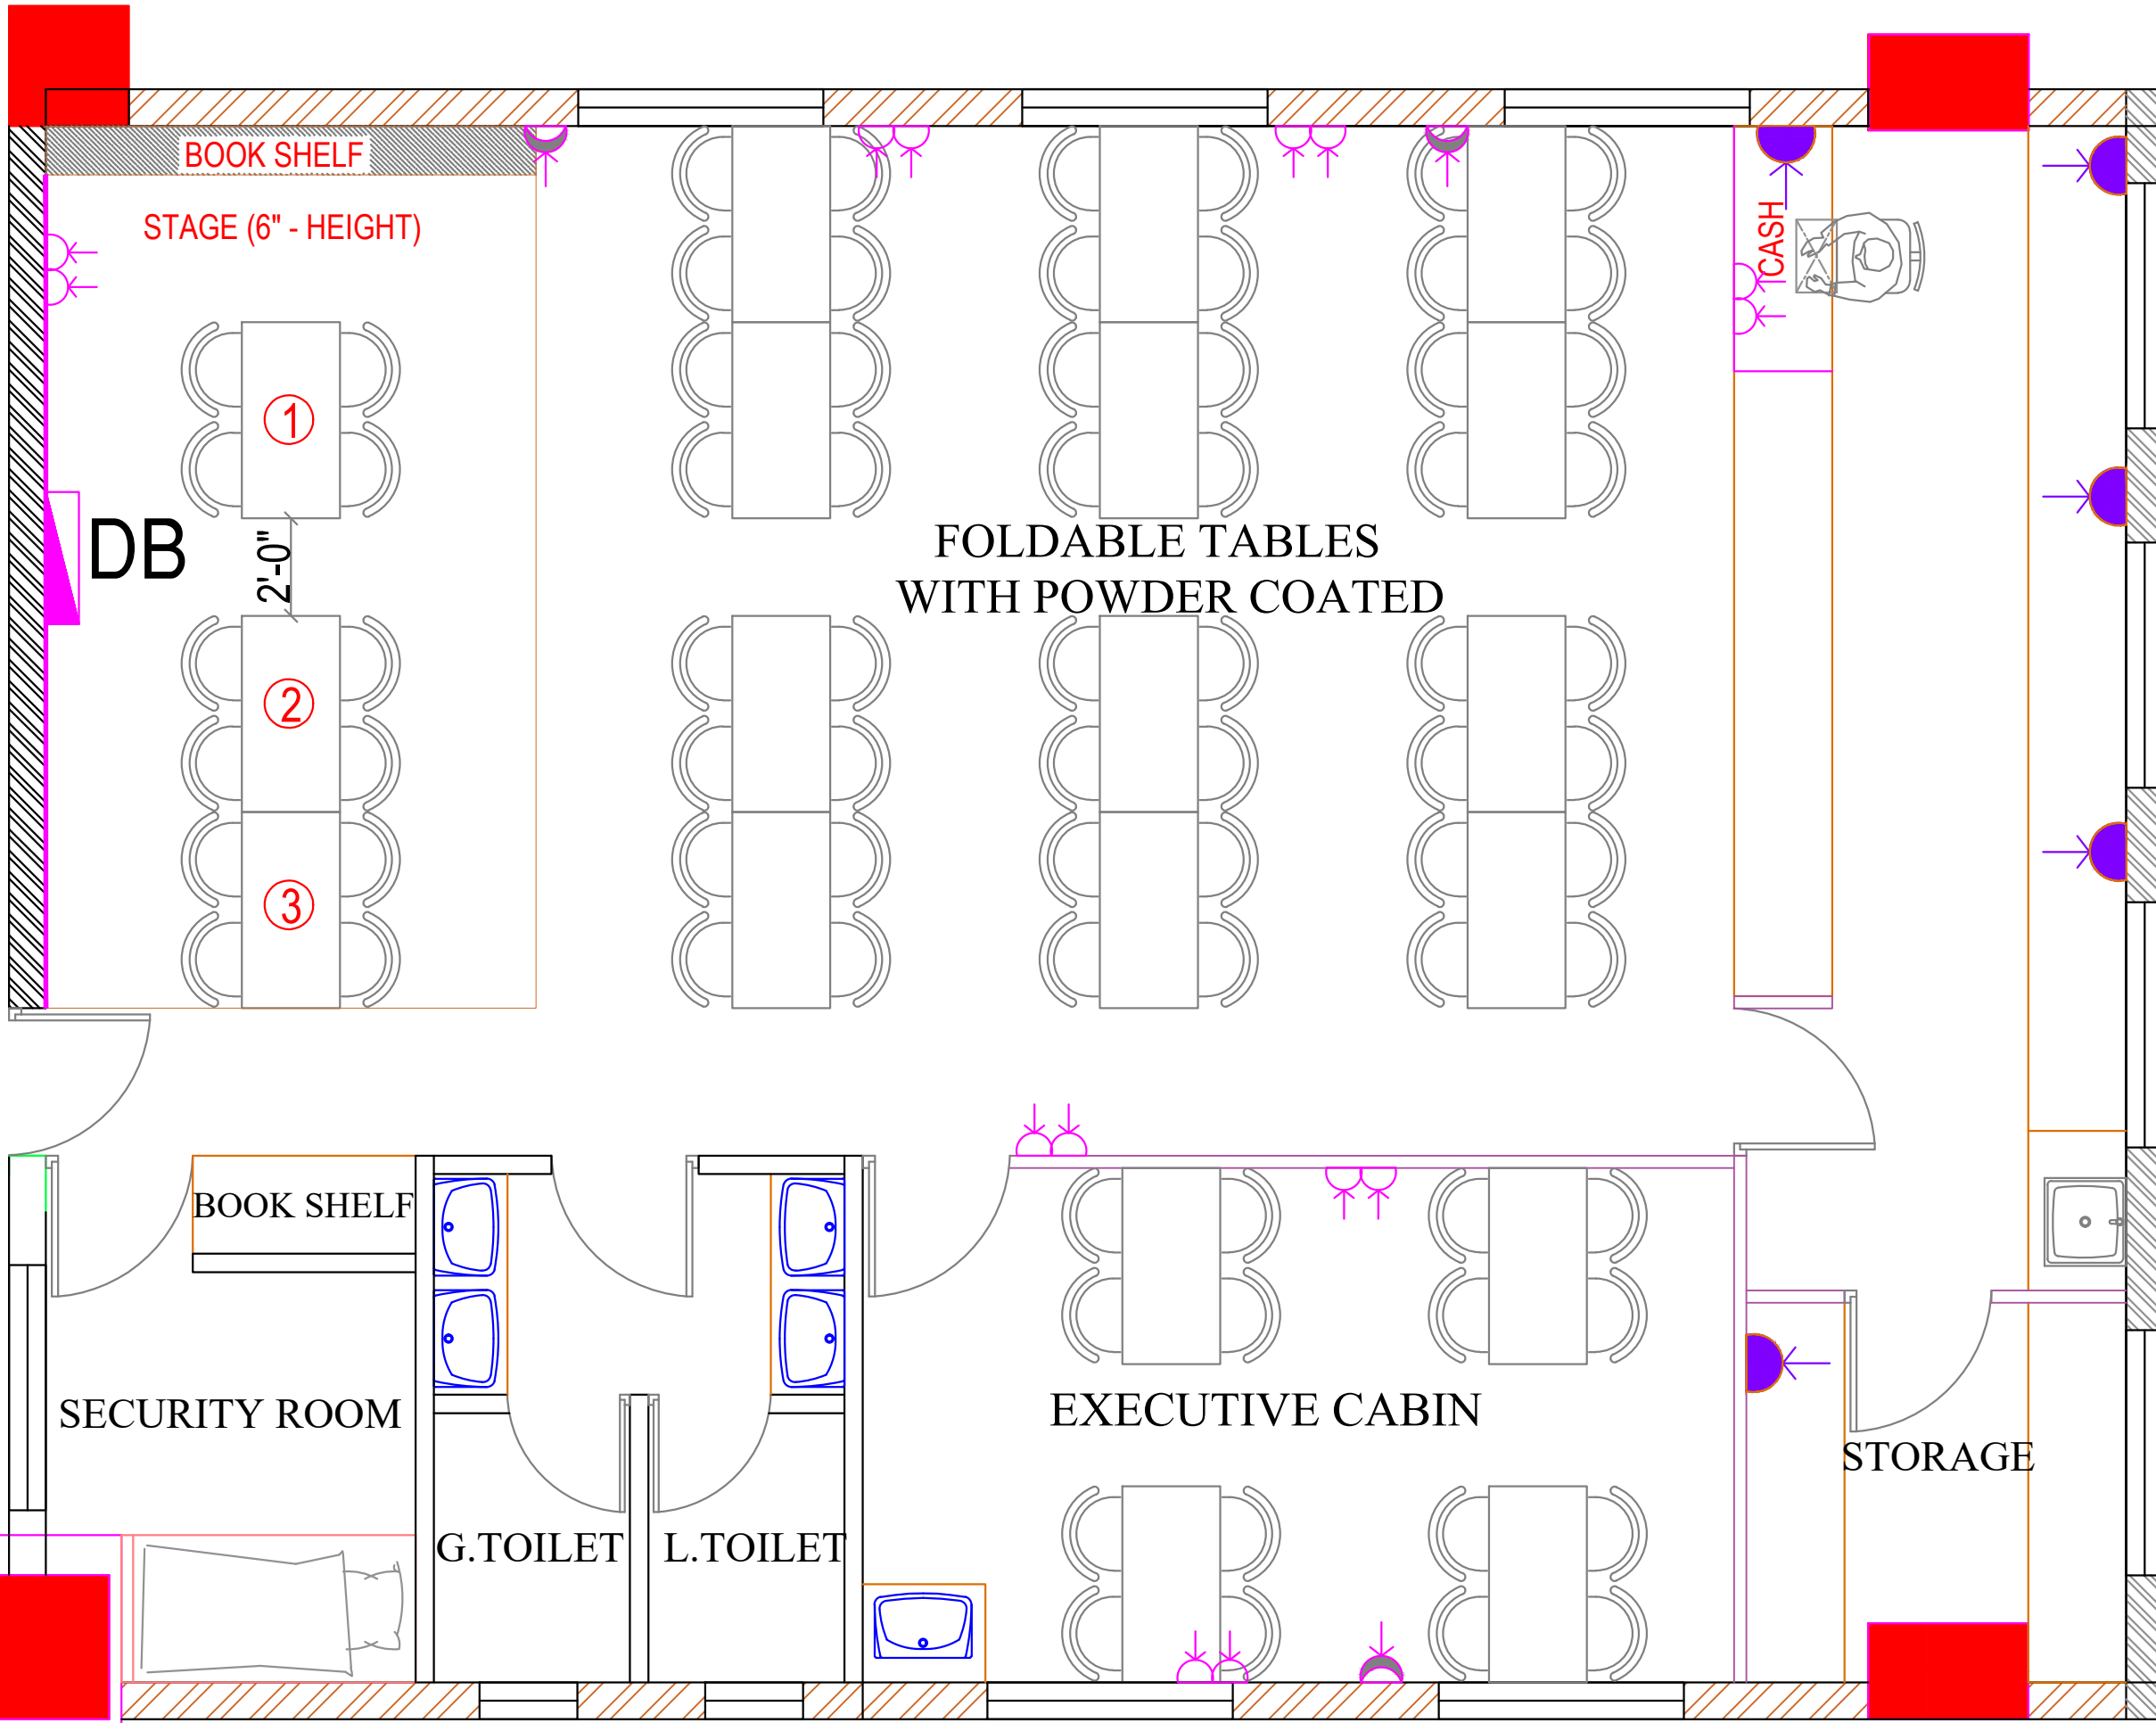




LEGEND	
	3 Nos.6A UPS Power Socket Outlet
	2 Nos.6A RAW Power Socket Outlet
	1 Nos.6A Raw Power Socket Outlet
	Modular Type 25/32A A/C Socket
	6/16ARaw Power Socket Outlet
	Data Socket
	Telephone Outlet
	6A AC Power Socket @CEILING LVL.
	Distribution Board

JOB NO	PROJECT TITLE :	PROPOSED INTERIOR DESIGN FOR	DRAWING TITLE :	DESIGN STAGE	SCALE	N.T.S	REV NO	02	ORIENTATION	ARCHITECTS
<b>1739</b>	<b>CANARA BANK CIRCLE OFFICE</b>	SAMBAKULAM ROAD, MADURAI.	POWER LAYOUT - TERRACE FLOOR	SCHEME LEVEL	DATE	29-04-2025	DRN	HARI G		
			DRAWING TYPE :	FINAL COPY	R.DATE	27.09.205	CHKD	G.G		<b>TSO DESIGN COMMUNE PVT. LTD.</b> Architects ■ Planners ■ Interior designers <small>NEW NO.16,(OLD NO.42), Ground floor, South West Boag Road, T.Nagar, Chennai - 600017. Ph : 044 - 4212 9252. Telefax : 044 - 2435 0493 E-mail : info@tsodc.com</small>

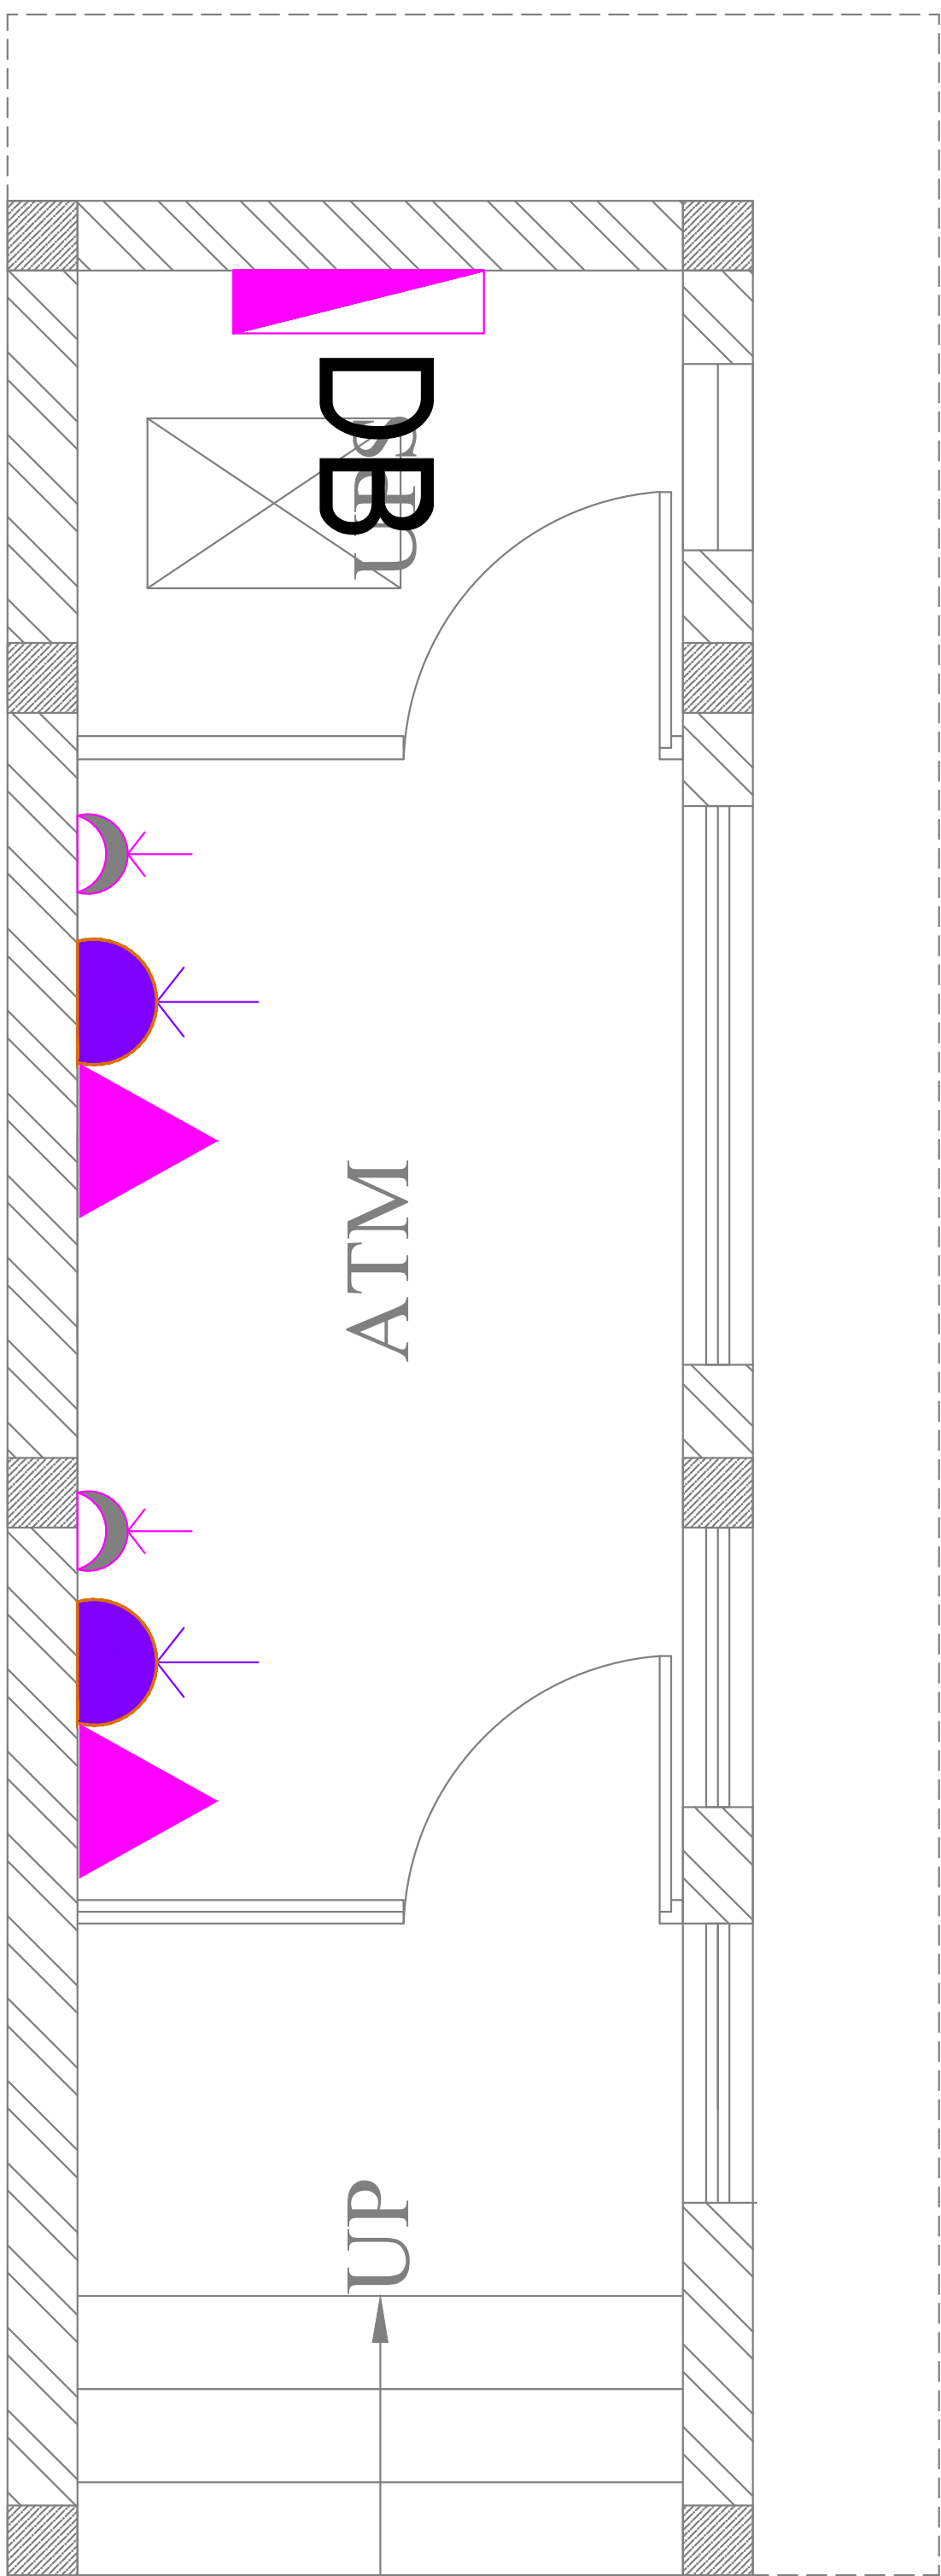

LEGEND	
	Modular Type 25/32A A/C Socket
	6/16ARaw Power Socket Outlet
	Data Socket
	Distribution Board

JOB NO <b>1739</b>	PROJECT TITLE :		PROPOSED INTERIOR DESIGN FOR		DRAWING TITLE :		DESIGN STAGE		SCALE	N.T.S	REV/NO	ORIENTATION	ARCHITECTS 	<b>TSD DESIGN COMMUNE PVT. LTD.</b> Architects • Planners • Interior designers NEW NO.16, OLD NO.421, Ground floor, South West Bang Road, Nagar, Changanassery, Pin - 044 722626, Trivandrum - 044 -2435 9493 E-mail: ttdesign@tds.com
	CANARA BANK CIRCLE OFFICE		SAMBAKULAM ROAD, MADURAI.		POWER LAYOUT - ATM		SCHEME LEVEL		DATE	29-04-2025	DRN	HARI G		
		DRAWING TYPE :		SCHEMATIC DRAWING		FINAL COPY		R.DATE	27.09.2025	CHKD	G.G			

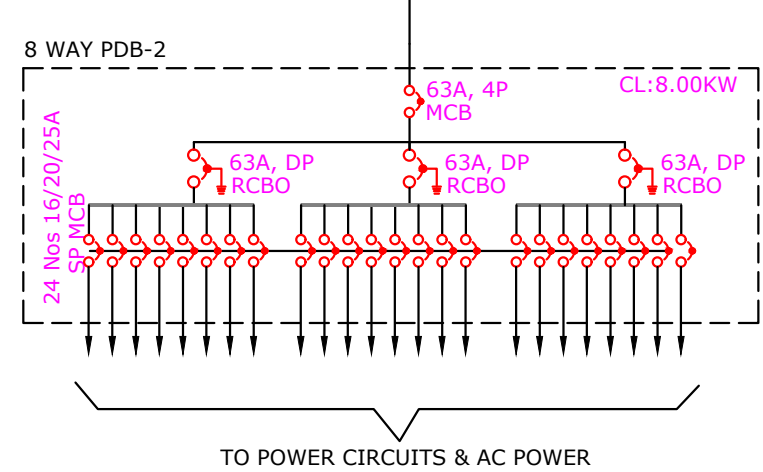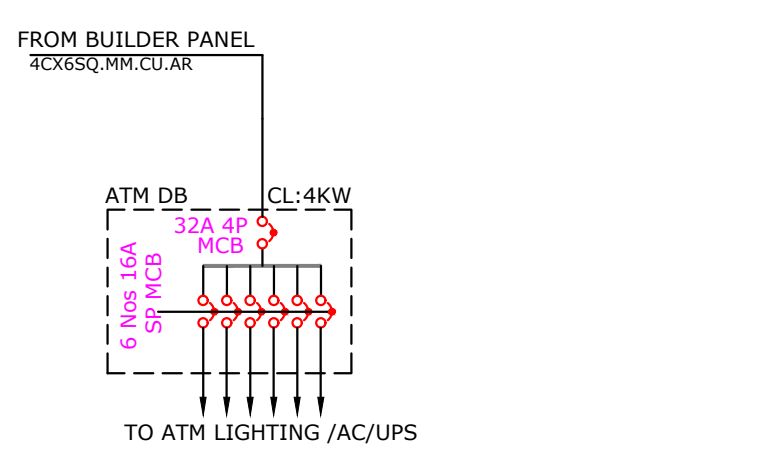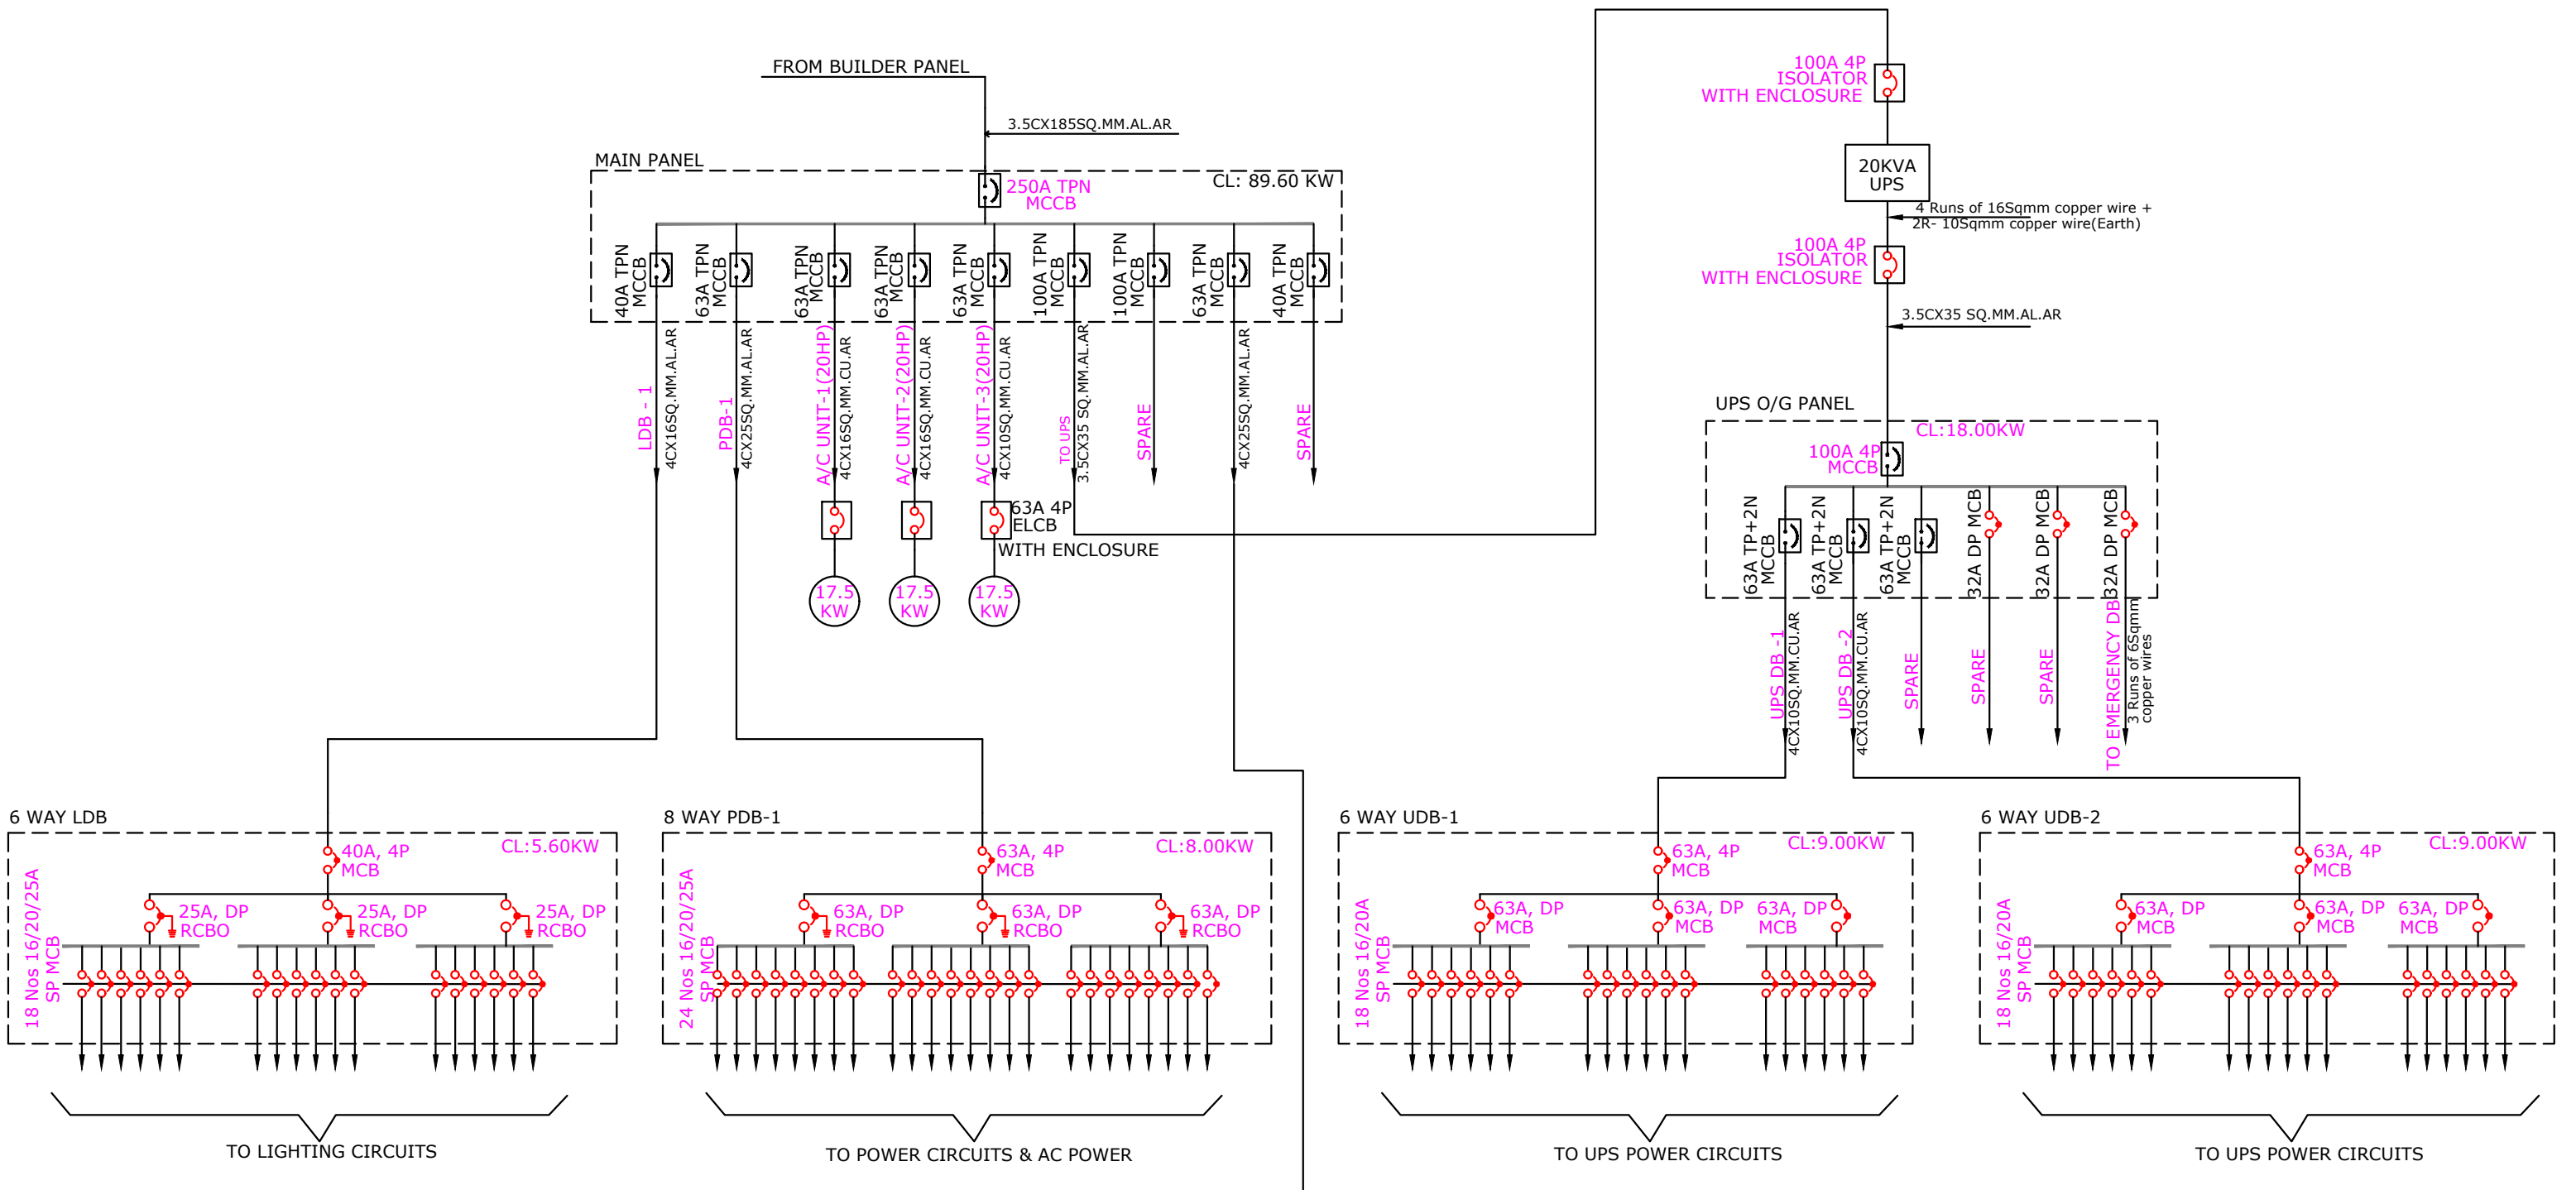

LEGEND	
	METER
	AUTO MAIN FAILURE
	SDF
	RW- REWIRE FUSE UNIT
	MINIATURE CIRCUIT BREAKER (MCB)
	MOULDED CASE CIRCUIT BREAKER (MCCB)
	EARTH LEAKAGE CIRCUIT BREAKER (ELCB)


PROJECT TITLE:  
**PROPOSED OFFICE INTERIOR FOR CANARA BANK CIRCLE OFFICE**  
 SAMBAKULAM ROAD, MADURAI.

ARCHITECT  
**TSO-DESIGN COMMUNE**  
 ARCHITECTS-PLANNERS-INTERIOR DESIGNERS  
 No : 16, GROUND FLOOR, SOUTHWEST BOAG ROAD,  
 T.NAGAR, CHENNAI - 600 017.  
 PHONE : 24350493, 42129252.

CONSULTANT:  
**G.GNANASEKARAN**  
 PLOT NO:3, 5TH STREET,  
 SHEELA NAGAR, MADIPAKKAM,  
 CHENNAI - 600 091  
 PHONE : 94453 26025

DRAWING TITLE:  
 SCHEMATIC LAYOUT  
 SECOND FLOOR

DRG NO : ELE-SLD-1	DATE : 14.09.2025
JOB NO : 1739	DRN : G.S.
SCALE : NTS	CHECKED : G.G.

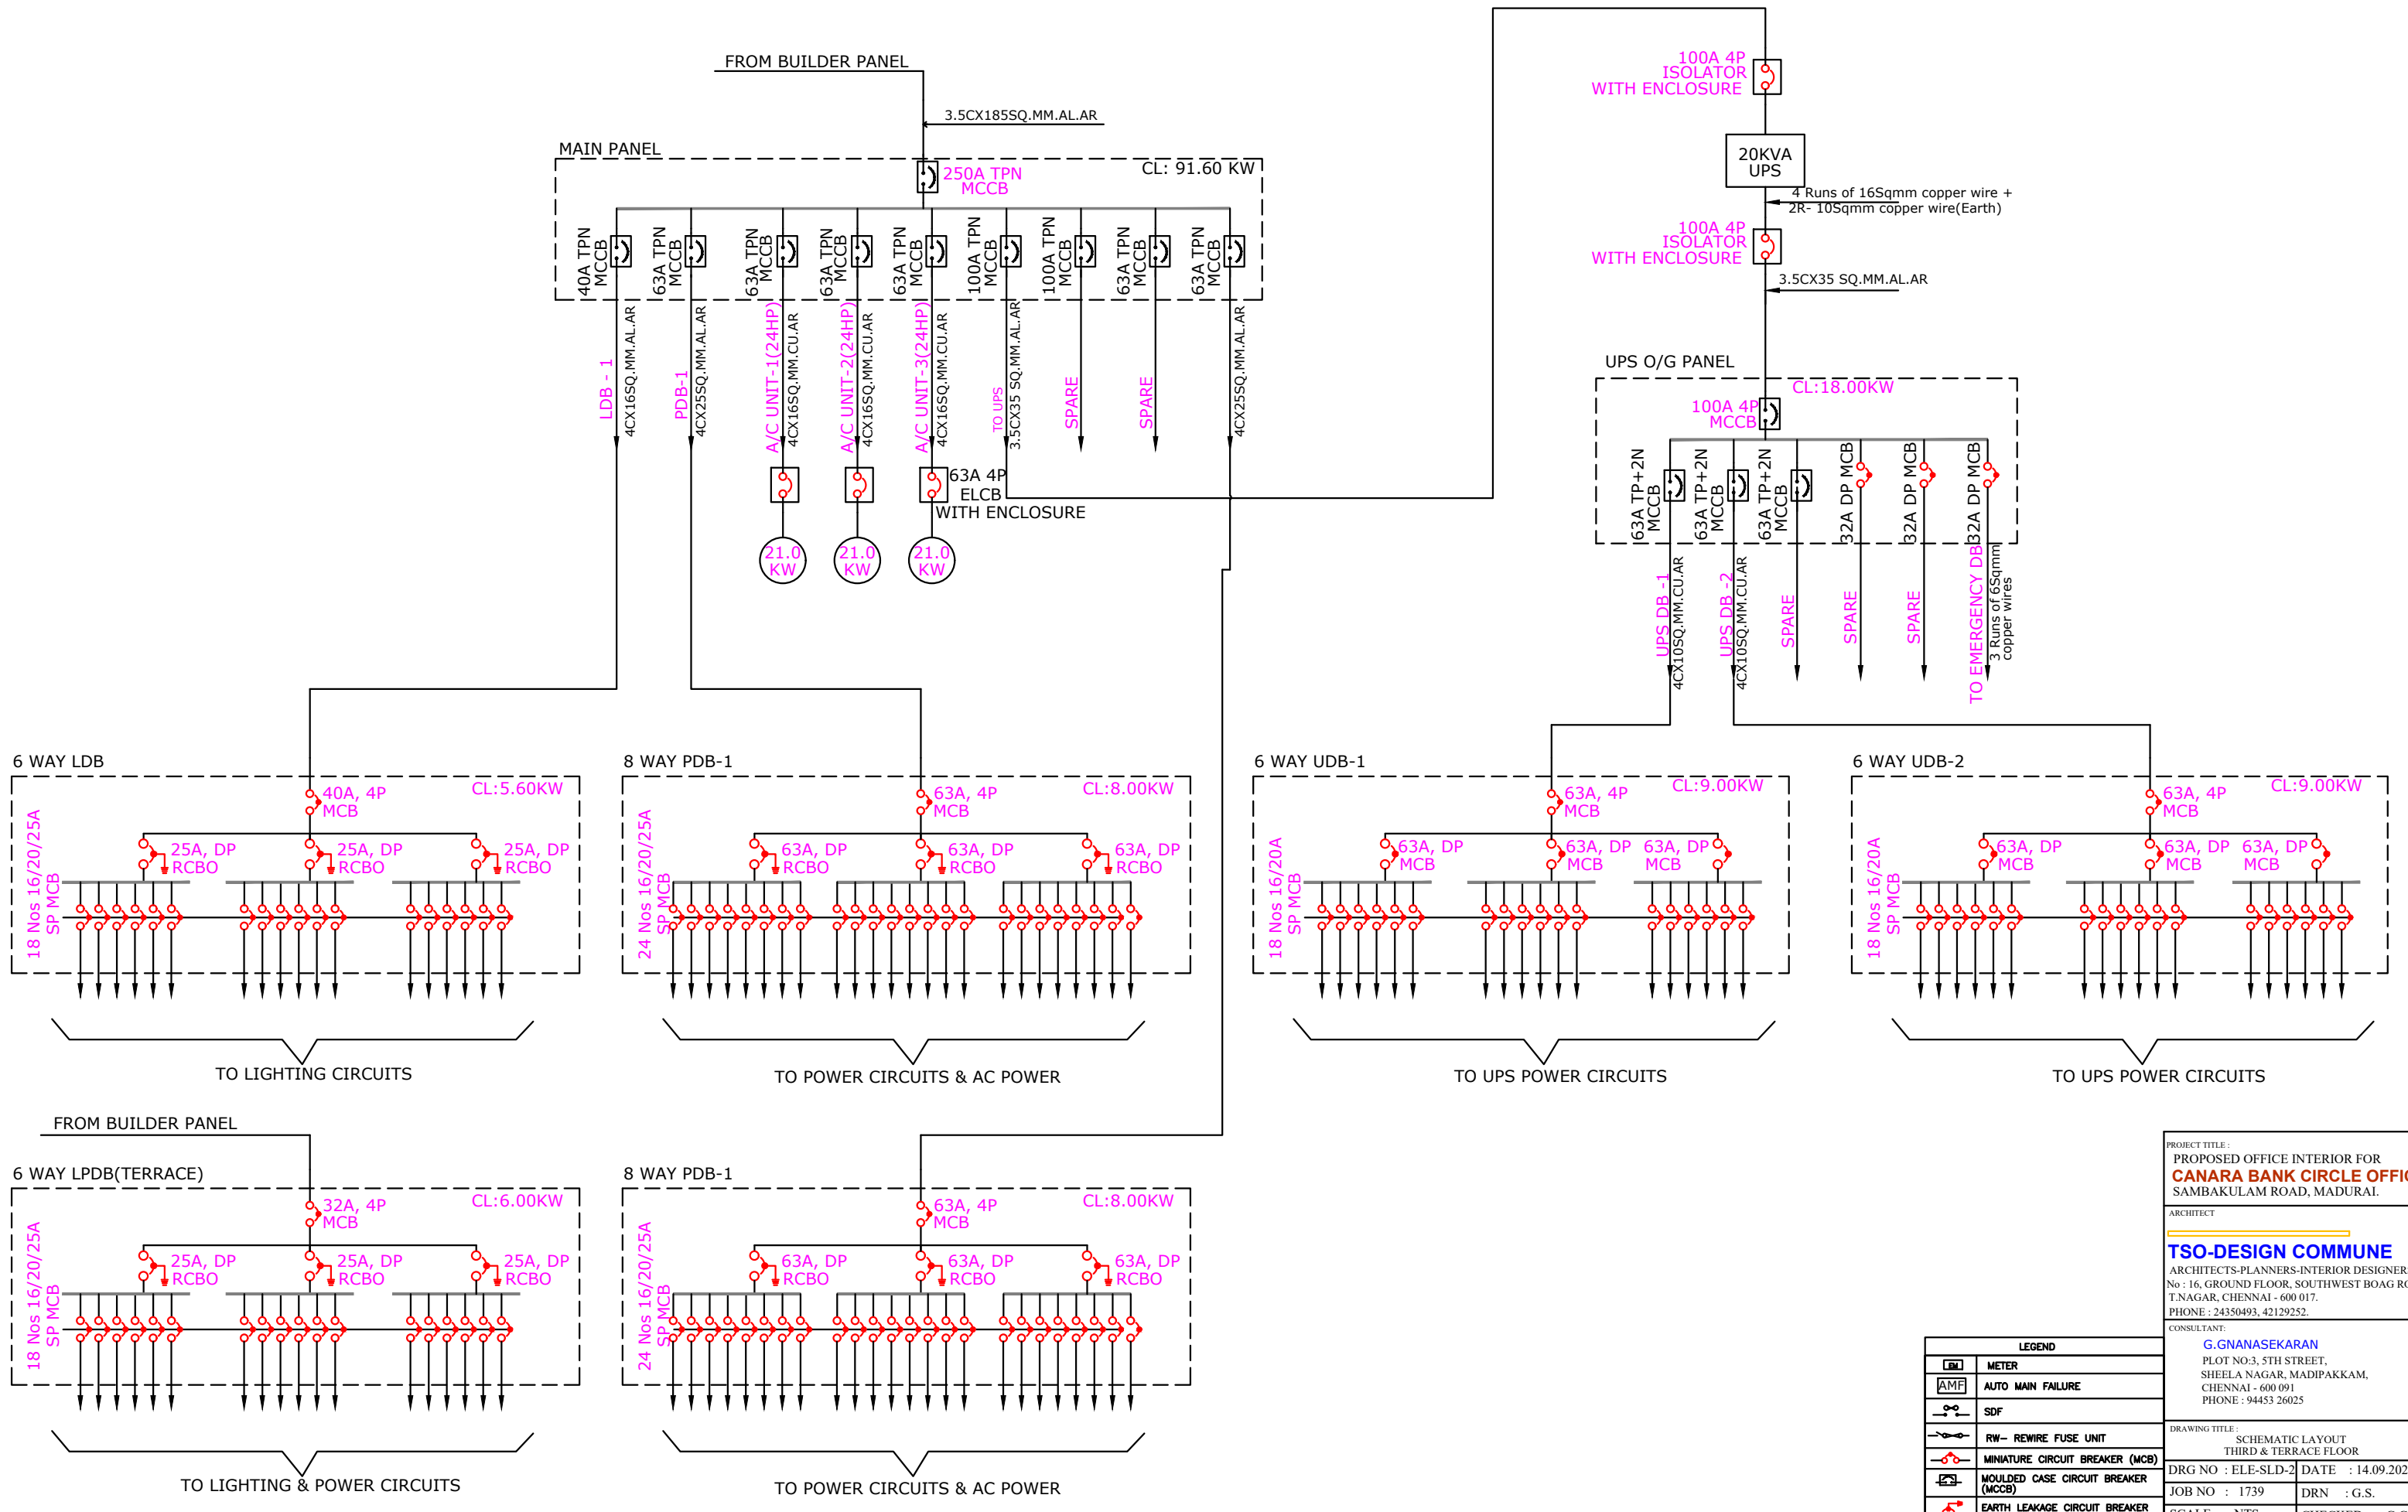

PROJECT TITLE :  
**PROPOSED OFFICE INTERIOR FOR CANARA BANK CIRCLE OFFICE**  
 SAMBAKULAM ROAD, MADURAI.


ARCHITECT  
**TSO-DESIGN COMMUNE**  
 ARCHITECTS-PLANNERS-INTERIOR DESIGNERS  
 No : 16, GROUND FLOOR, SOUTHWEST BOAG ROAD  
 T.NAGAR, CHENNAI - 600 017.  
 PHONE : 24350493, 42129252.

CONSULTANT:  
**G.GNANASEKARAN**  
 PLOT NO:3, 5TH STREET,  
 SHEELA NAGAR, MADIPAKKAM,  
 CHENNAI - 600 091  
 PHONE : 94453 26025

DRAWING TITLE :  
 SCHEMATIC LAYOUT  
 THIRD & TERRACE FLOOR


DRG NO : ELE-SLD-2	DATE : 14.09.2025
JOB NO : 1739	DRN : G.S.
SCALE : NTS	CHECKED : G.G.

LEGEND	
	METER
	AUTO MAIN FAILURE
	SDF
	RW- REWIRE FUSE UNIT
	MINIATURE CIRCUIT BREAKER (MCB)
	MOULDED CASE CIRCUIT BREAKER (MCCB)
	EARTH LEAKAGE CIRCUIT BREAKER (ELCB)

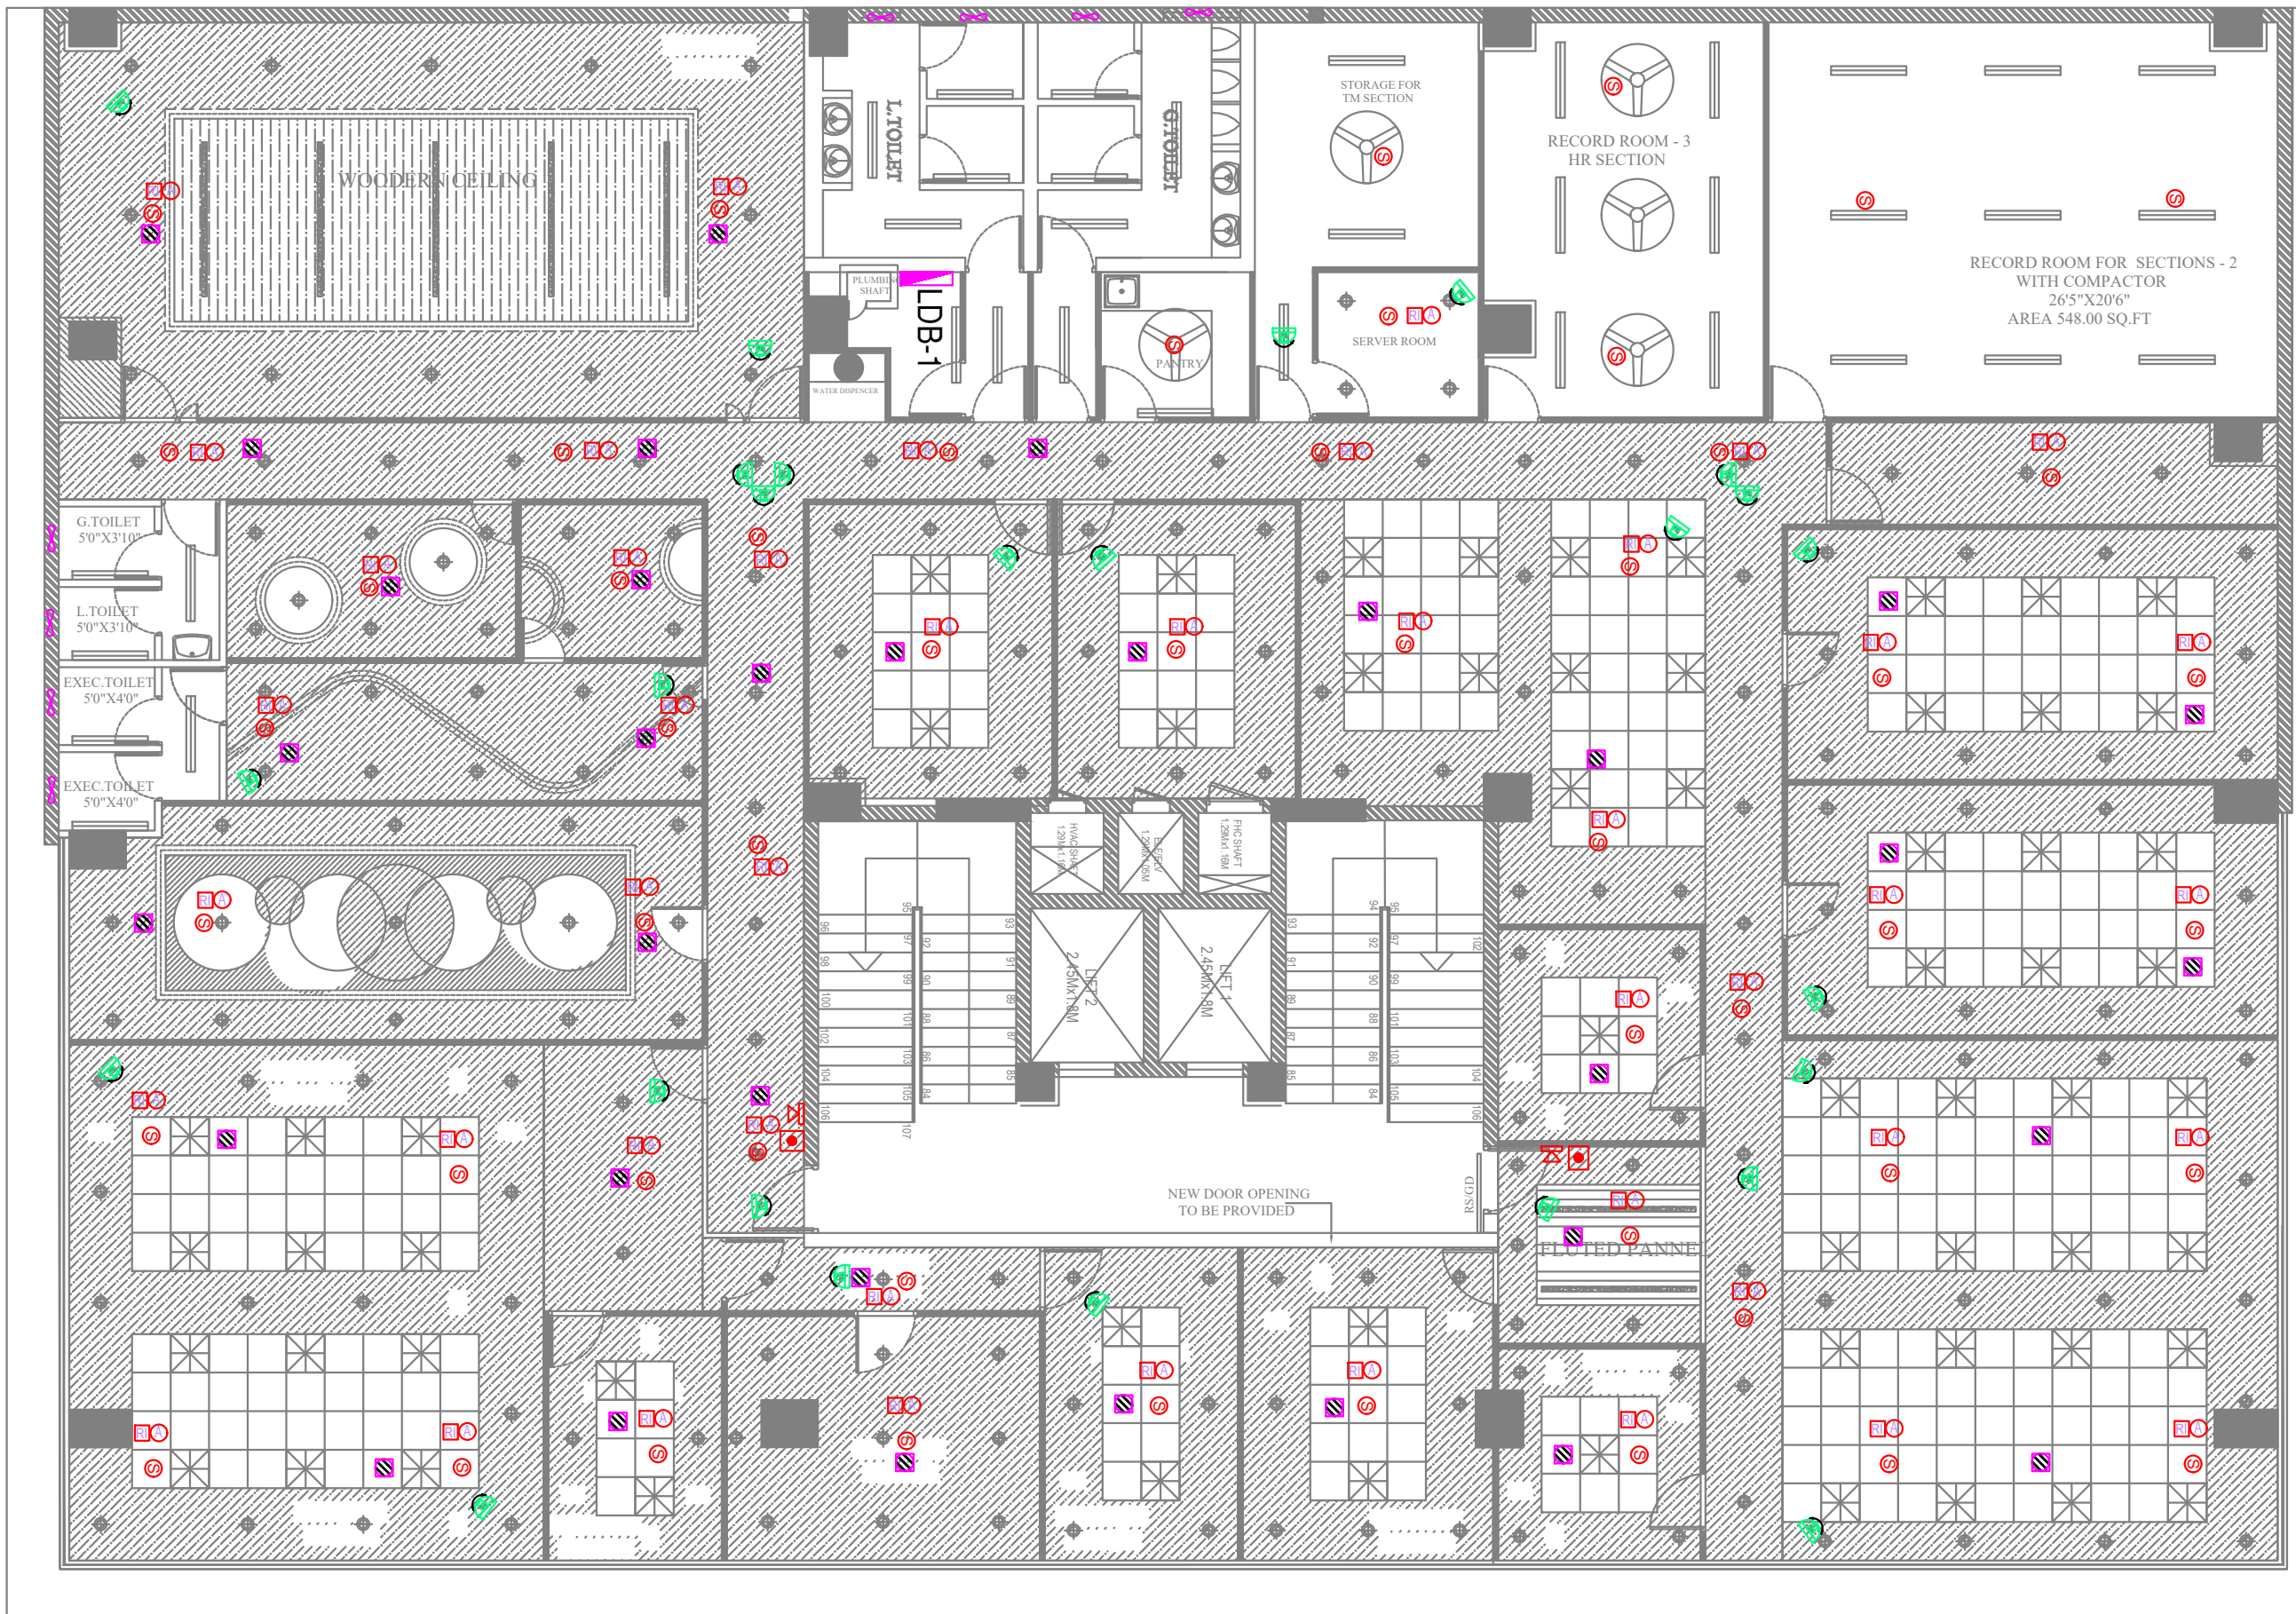


LEGEND	
	SMOKE DETECTOR
	HOOTER
	MANUAL CALL POINT
	CEILING SPEAKER
	HEAT DETECTOR
	ABOVE SMOKE DETECTOR
	RESPONSE INDICATOR
	CAMERA

JOB NO	PROJECT TITLE :	PROPOSED INTERIOR DESIGN FOR	FIRE ALARM LAYOUT - SECOND FLOOR	DESIGN STAGE	SCALE	N.T.S	REV NO	REV - 01	ORIENTATION	ARCHITECTS
1739		<b>CANARA BANK CIRCLE OFFICE</b>		SCHEME LEVEL	DATE	29-04-2025	DRN	HARI G		<b>TSO DESIGN COMMUNE PVT. LTD.</b> Architects ■ Planners ■ Interior designers <small>NEW NO.16,(OLD NO.42), Ground floor, South West Boag Road,          T.Nagar, Chennai - 600017. Ph : 044 - 4212 9252          Telefax : 044 - 2435 0493 E-mail : info@tsdc.com</small>
		SAMBAKULAM ROAD, MADURAI.	SCHEMATIC DRAWING	FINAL COPY	R.DATE	06.09.2025	CHKD	G.G		

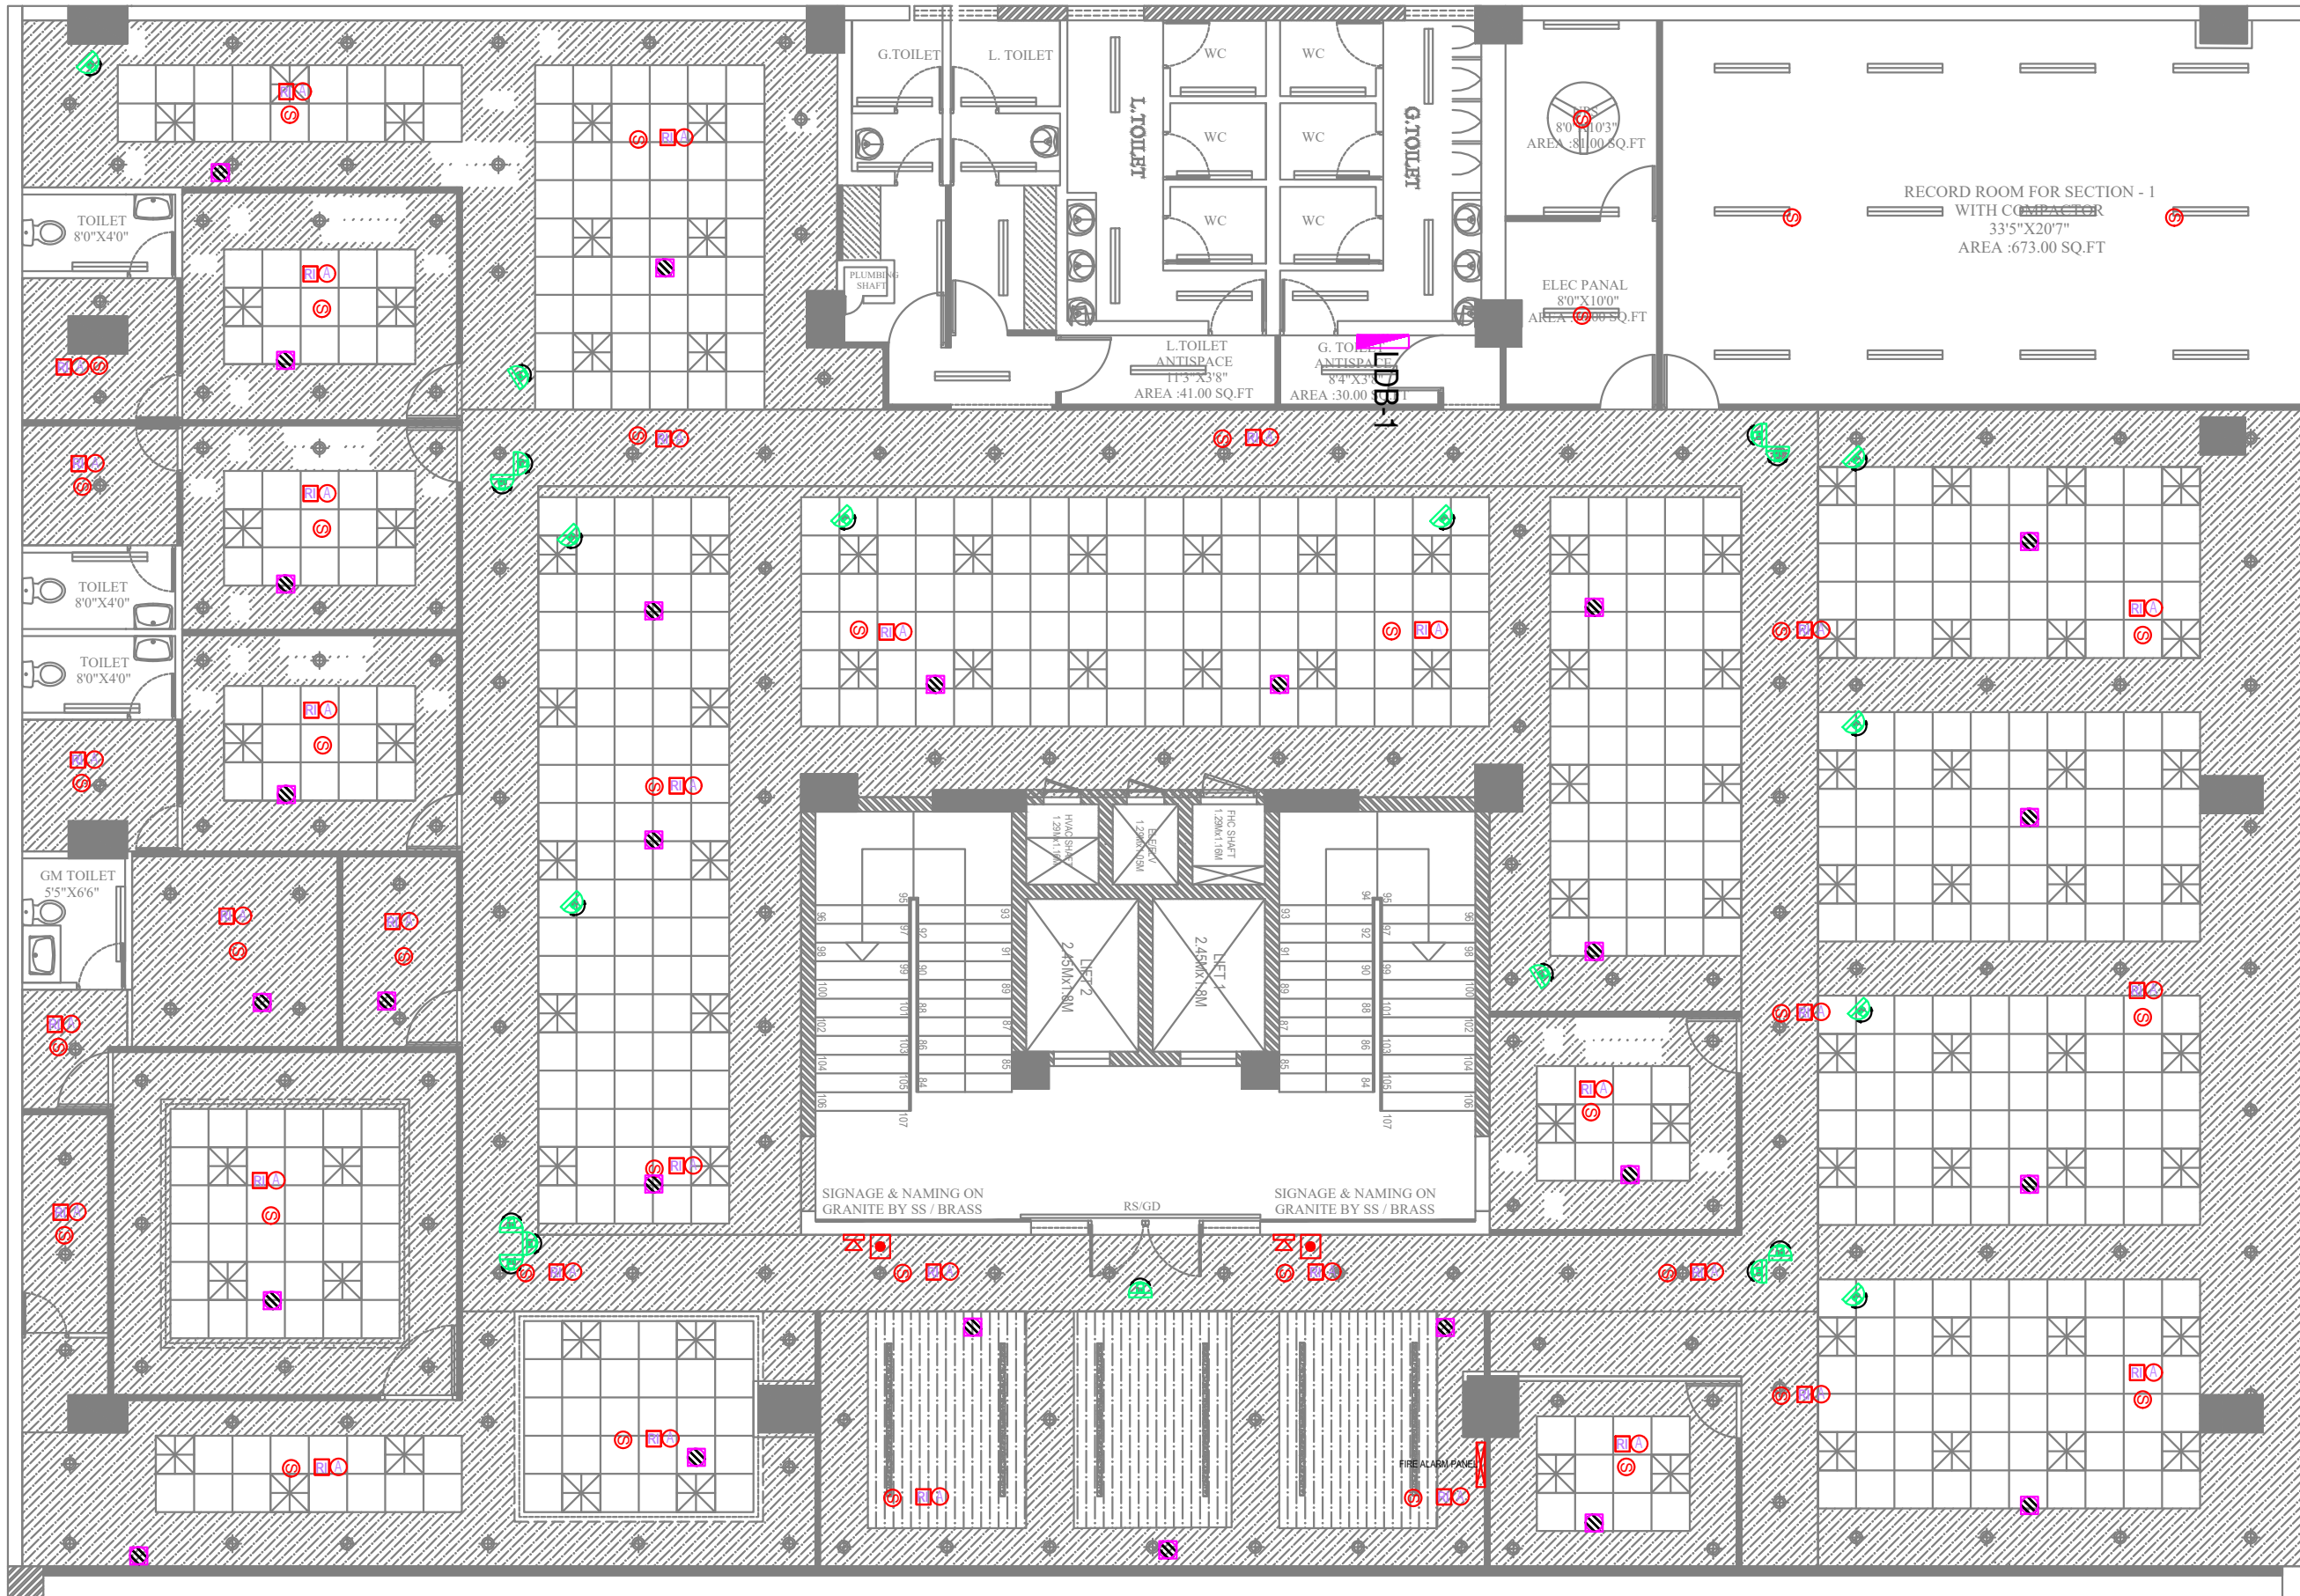


LEGEND	
	SMOKE DETECTOR
	HOOTER
	MANUAL CALL POINT
	CEILING SPEAKER
	HEAT DETECTOR
	ABOVE SMOKE DETECTOR
	RESPONSE INDICATOR
	CAMERA

JOB NO <b>1739</b>	PROJECT TITLE : <b>PROPOSED INTERIOR DESIGN FOR CANARA BANK CIRCLE OFFICE SAMBAKULAM ROAD, MADURAI.</b>	DRAWING TITLE :	FIRE ALARM LAYOUT - THIRD FLOOR	DESIGN STAGE	SCALE	N.T.S	REV NO	REV - 01	ORIENTATION	ARCHITECTS <b>TSO DESIGN COMMUNE PVT. LTD.</b> Architects ■ Planners ■ Interior designers NEW NO.16,(OLD NO.42), Ground floor, South West Boag Road, T.Nagar, Chennai - 600017. Ph : 044 - 4212 9252 Telefax : 044 - 2435 0493 E-mail : info@tdc.com
		DRAWING TYPE :	SCHEMATIC DRAWING	SCHEME LEVEL FINAL COPY	DATE	29-04-2025	DRN	HARI G		
					R.DATE	06.09.2025	CHKD	G.G		

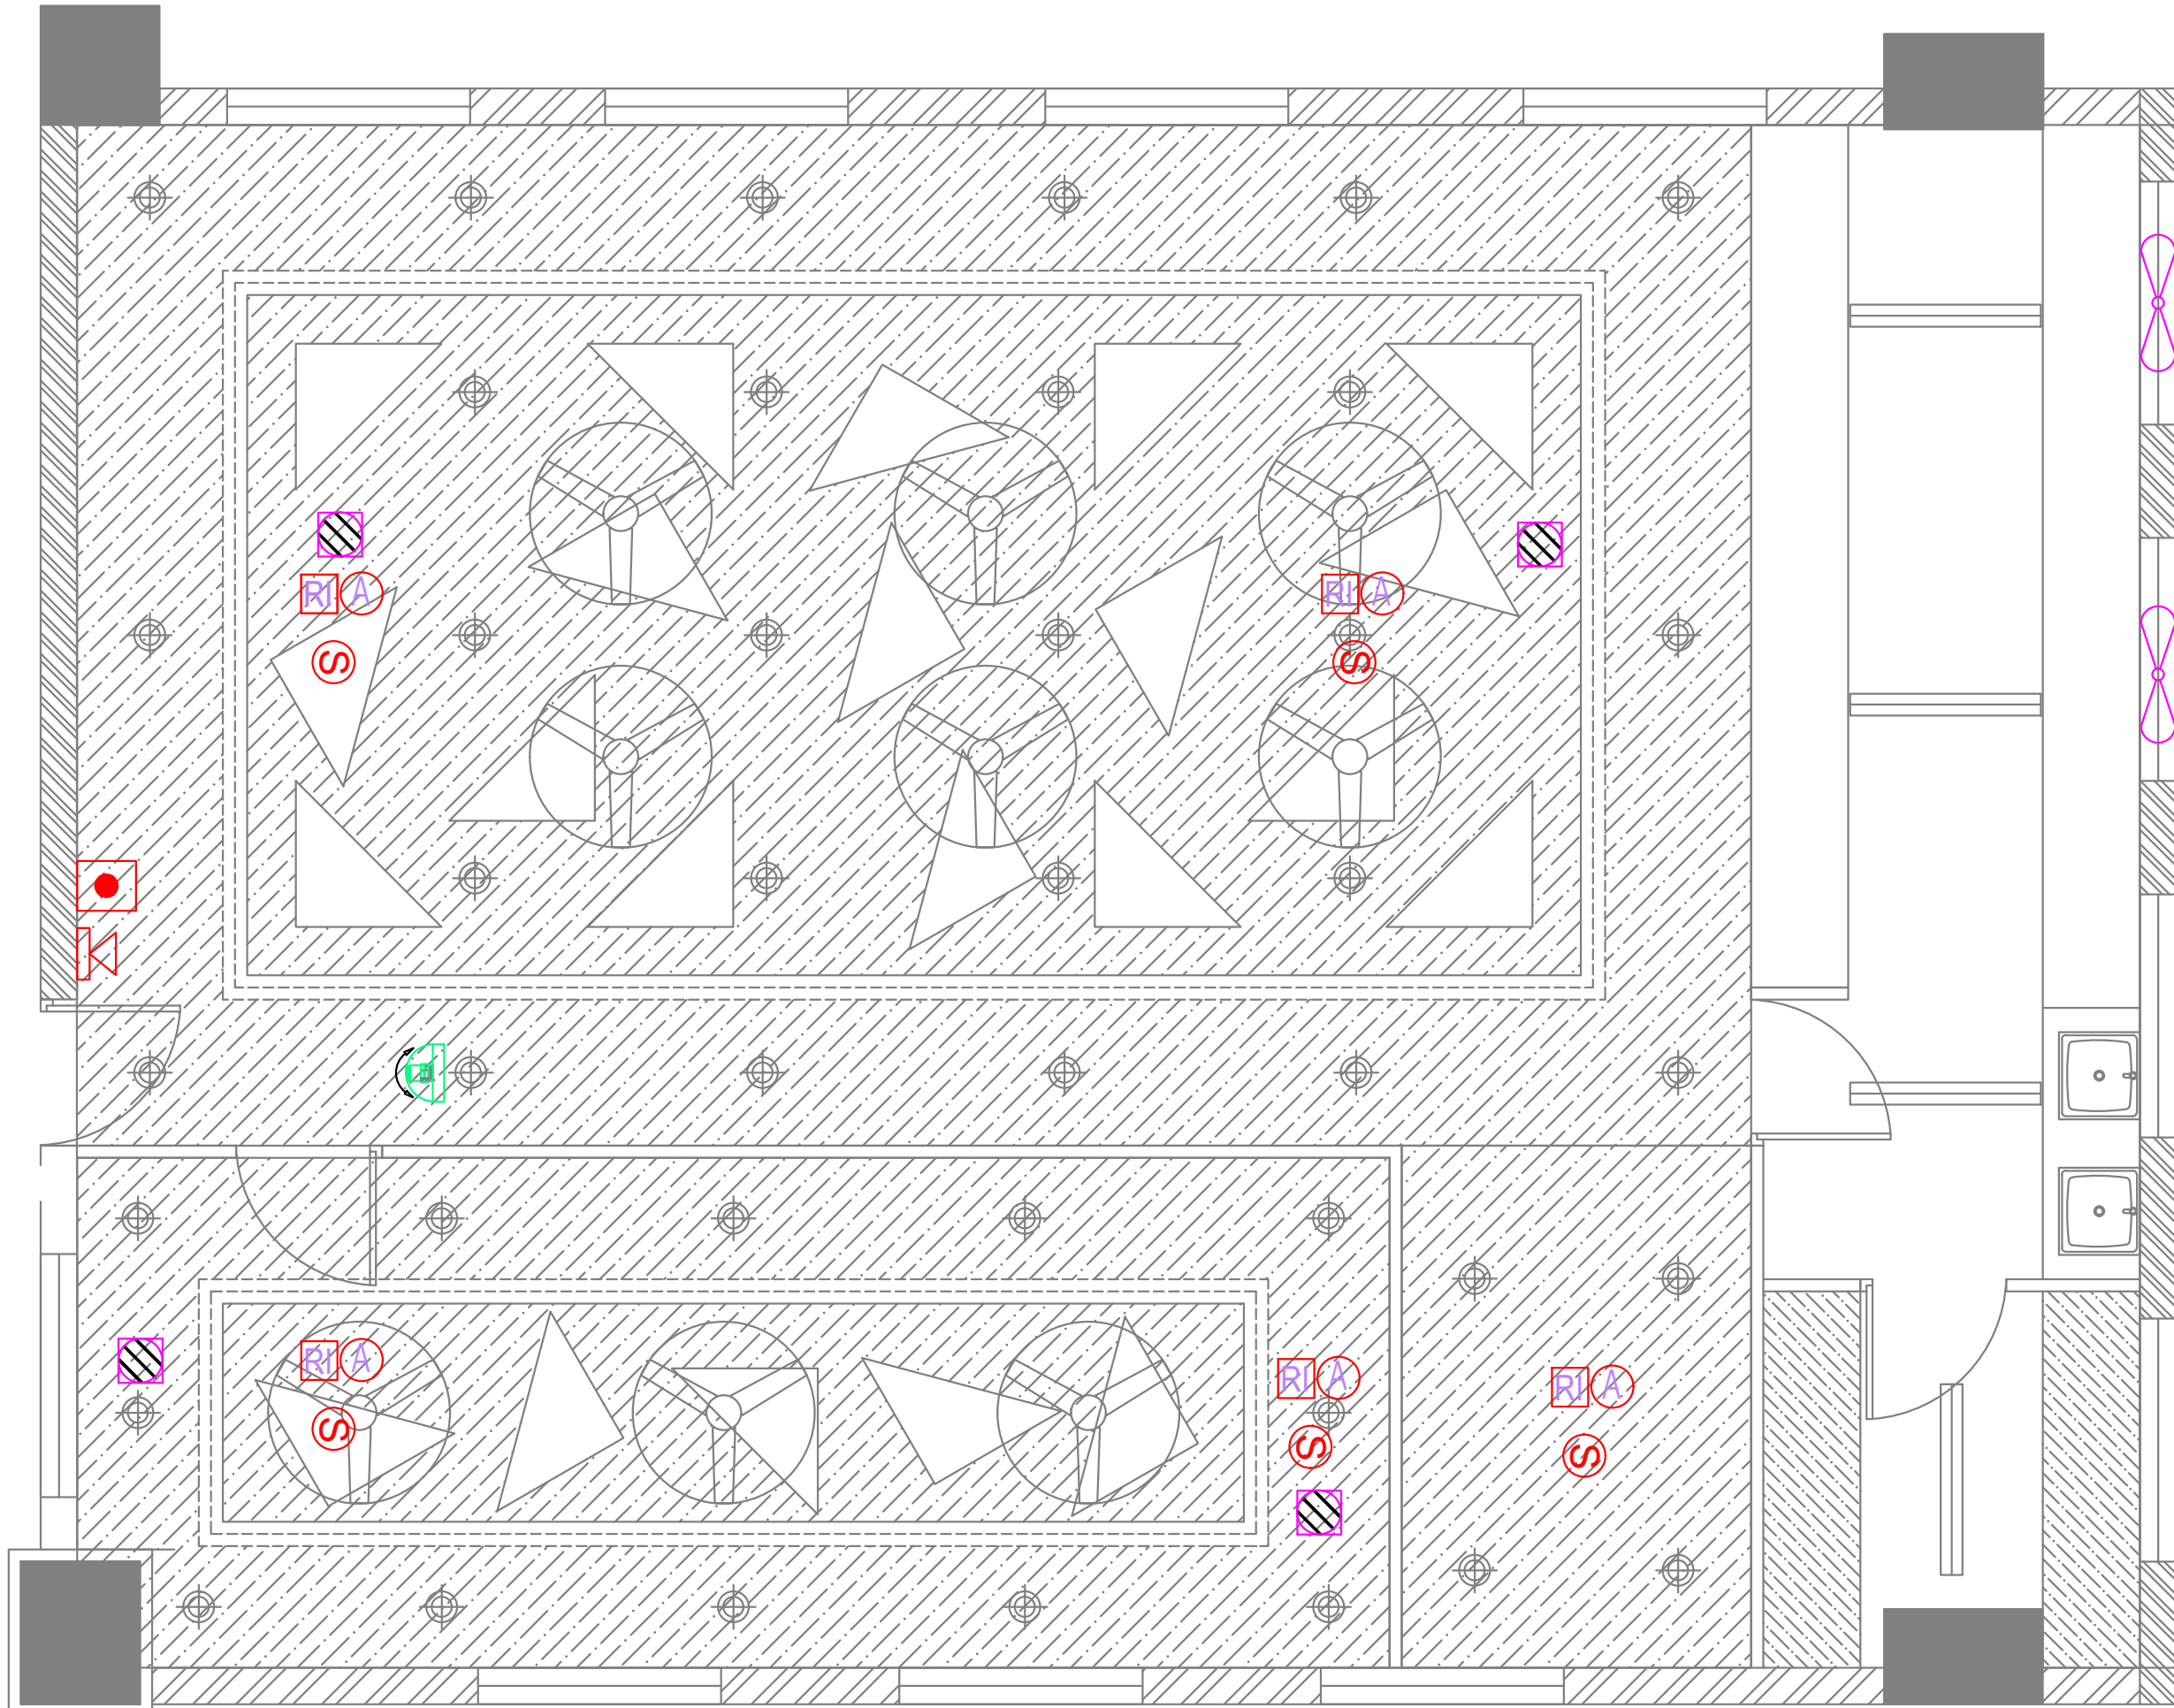

LEGEND	
	SMOKE DETECTOR
	HOOTER
	MANUAL CALL POINT
	CEILING SPEAKER
	HEAT DETECTOR
	ABOVE SMOKE DETECTOR
	RESPONSE INDICATOR
	CAMERA

JOB NO <b>1739</b>	PROJECT TITLE : <b>PROPOSED INTERIOR DESIGN FOR CANARA BANK CIRCLE OFFICE SAMBAKULAM ROAD, MADURAI.</b>	DRAWING TITLE : FIRE ALARM LAYOUT TERRACE FLOOR	DESIGN STAGE SCHEME LEVEL	SCALE N.T.S	REV NO 01	ORIENTATION 	ARCHITECTS <b>TSO DESIGN COMMUNE PVT. LTD.</b> Architects ■ Planners ■ Interior designers <small>NEW NO.16,(OLD NO.42), Ground floor, South West Boag Road, T.Nagar, Chennai - 600017. Ph : 044 - 4212 9252 Telefax : 044 - 2435 0493 E-mail : info@tsodc.com</small>
		DRAWING TYPE : SCHEMATIC DRAWING	FINAL COPY	DATE 29-04-2025	DRN HARI G		
				R.DATE 06.09.2025	CHKD G.G		

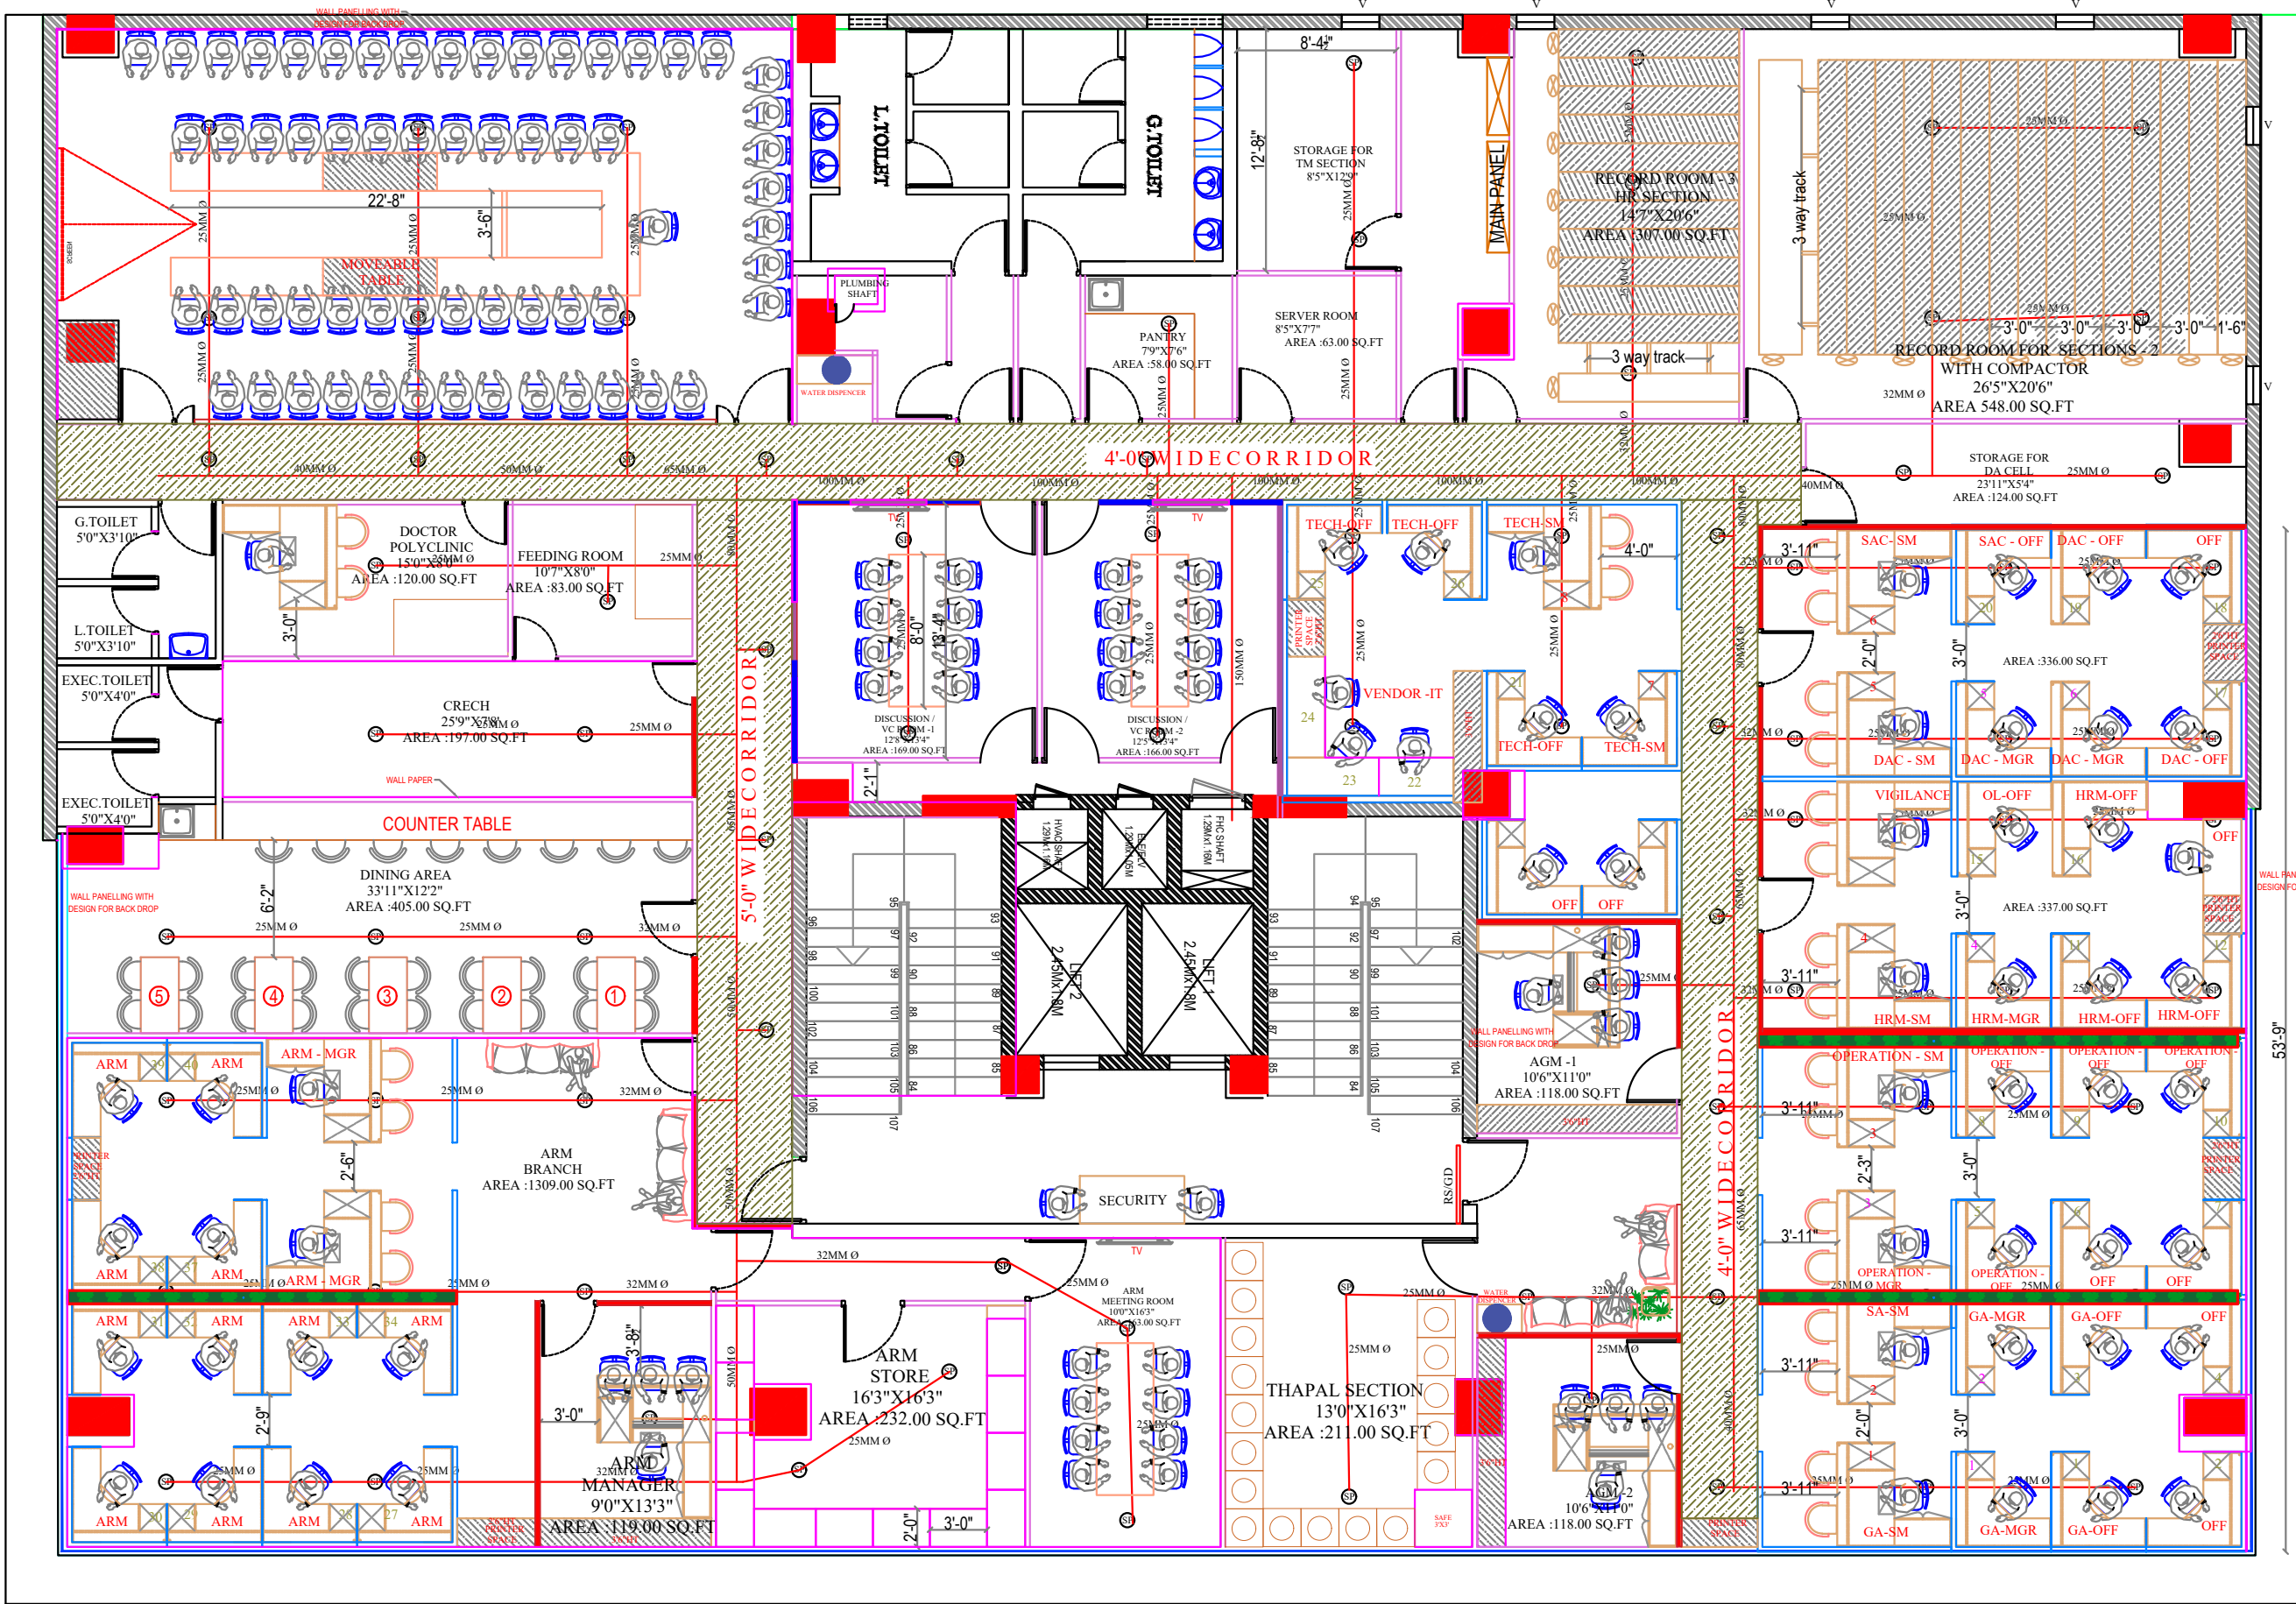


- ▬ SEMI GLAZED PARTITION
- ▬ LOW HEIGHT PARTITION
- ▬ FULL GLAZED PARTITION
- ▬ FULL HEIGHT SOLID PARTITION

- ARM MGR - 1
- AGM - 2
- SM - 8
- MGR - 8
- OFFICER - 43

CARPET AREA  
 SECOND FLOOR - 7845.10 SQ.FT  
 THIRD FLOOR - 8129.10 SQ.FT  
 TOTAL AREA - 15974.20 SQ.FT  
 (EXCLUDED TOILET & STAIRCASE)

JOB NO <b>1739</b>	PROJECT TITLE : <b>CANARA BANK CIRCLE OFFICE</b> SAMBAKULAM ROAD, MADURAI.	DRAWING TITLE :	SPRINKLER LAYOUT -SECOND FLOOR	DESIGN STAGE	SCALE	N.T.S	REV NO	REV - 19	ORIENTATION	ARCHITECTS <b>TSO DESIGN COMMUNE PVT. LTD.</b> Architects ■ Planners ■ Interior designers NEW NO.16,(OLD NO.42), Ground floor, South West Boag Road, T.Nagar, Chennai - 600017. Ph : 044 - 4212 9252 Telefax : 044 - 2435 0490 E-mail : info@tsodc.com
		DRAWING TYPE :	SCHEMATIC DRAWING			DATE	29-04-2025	DRN	K.D	
					R.DATE	25.10.2025	CHKD	K.S		

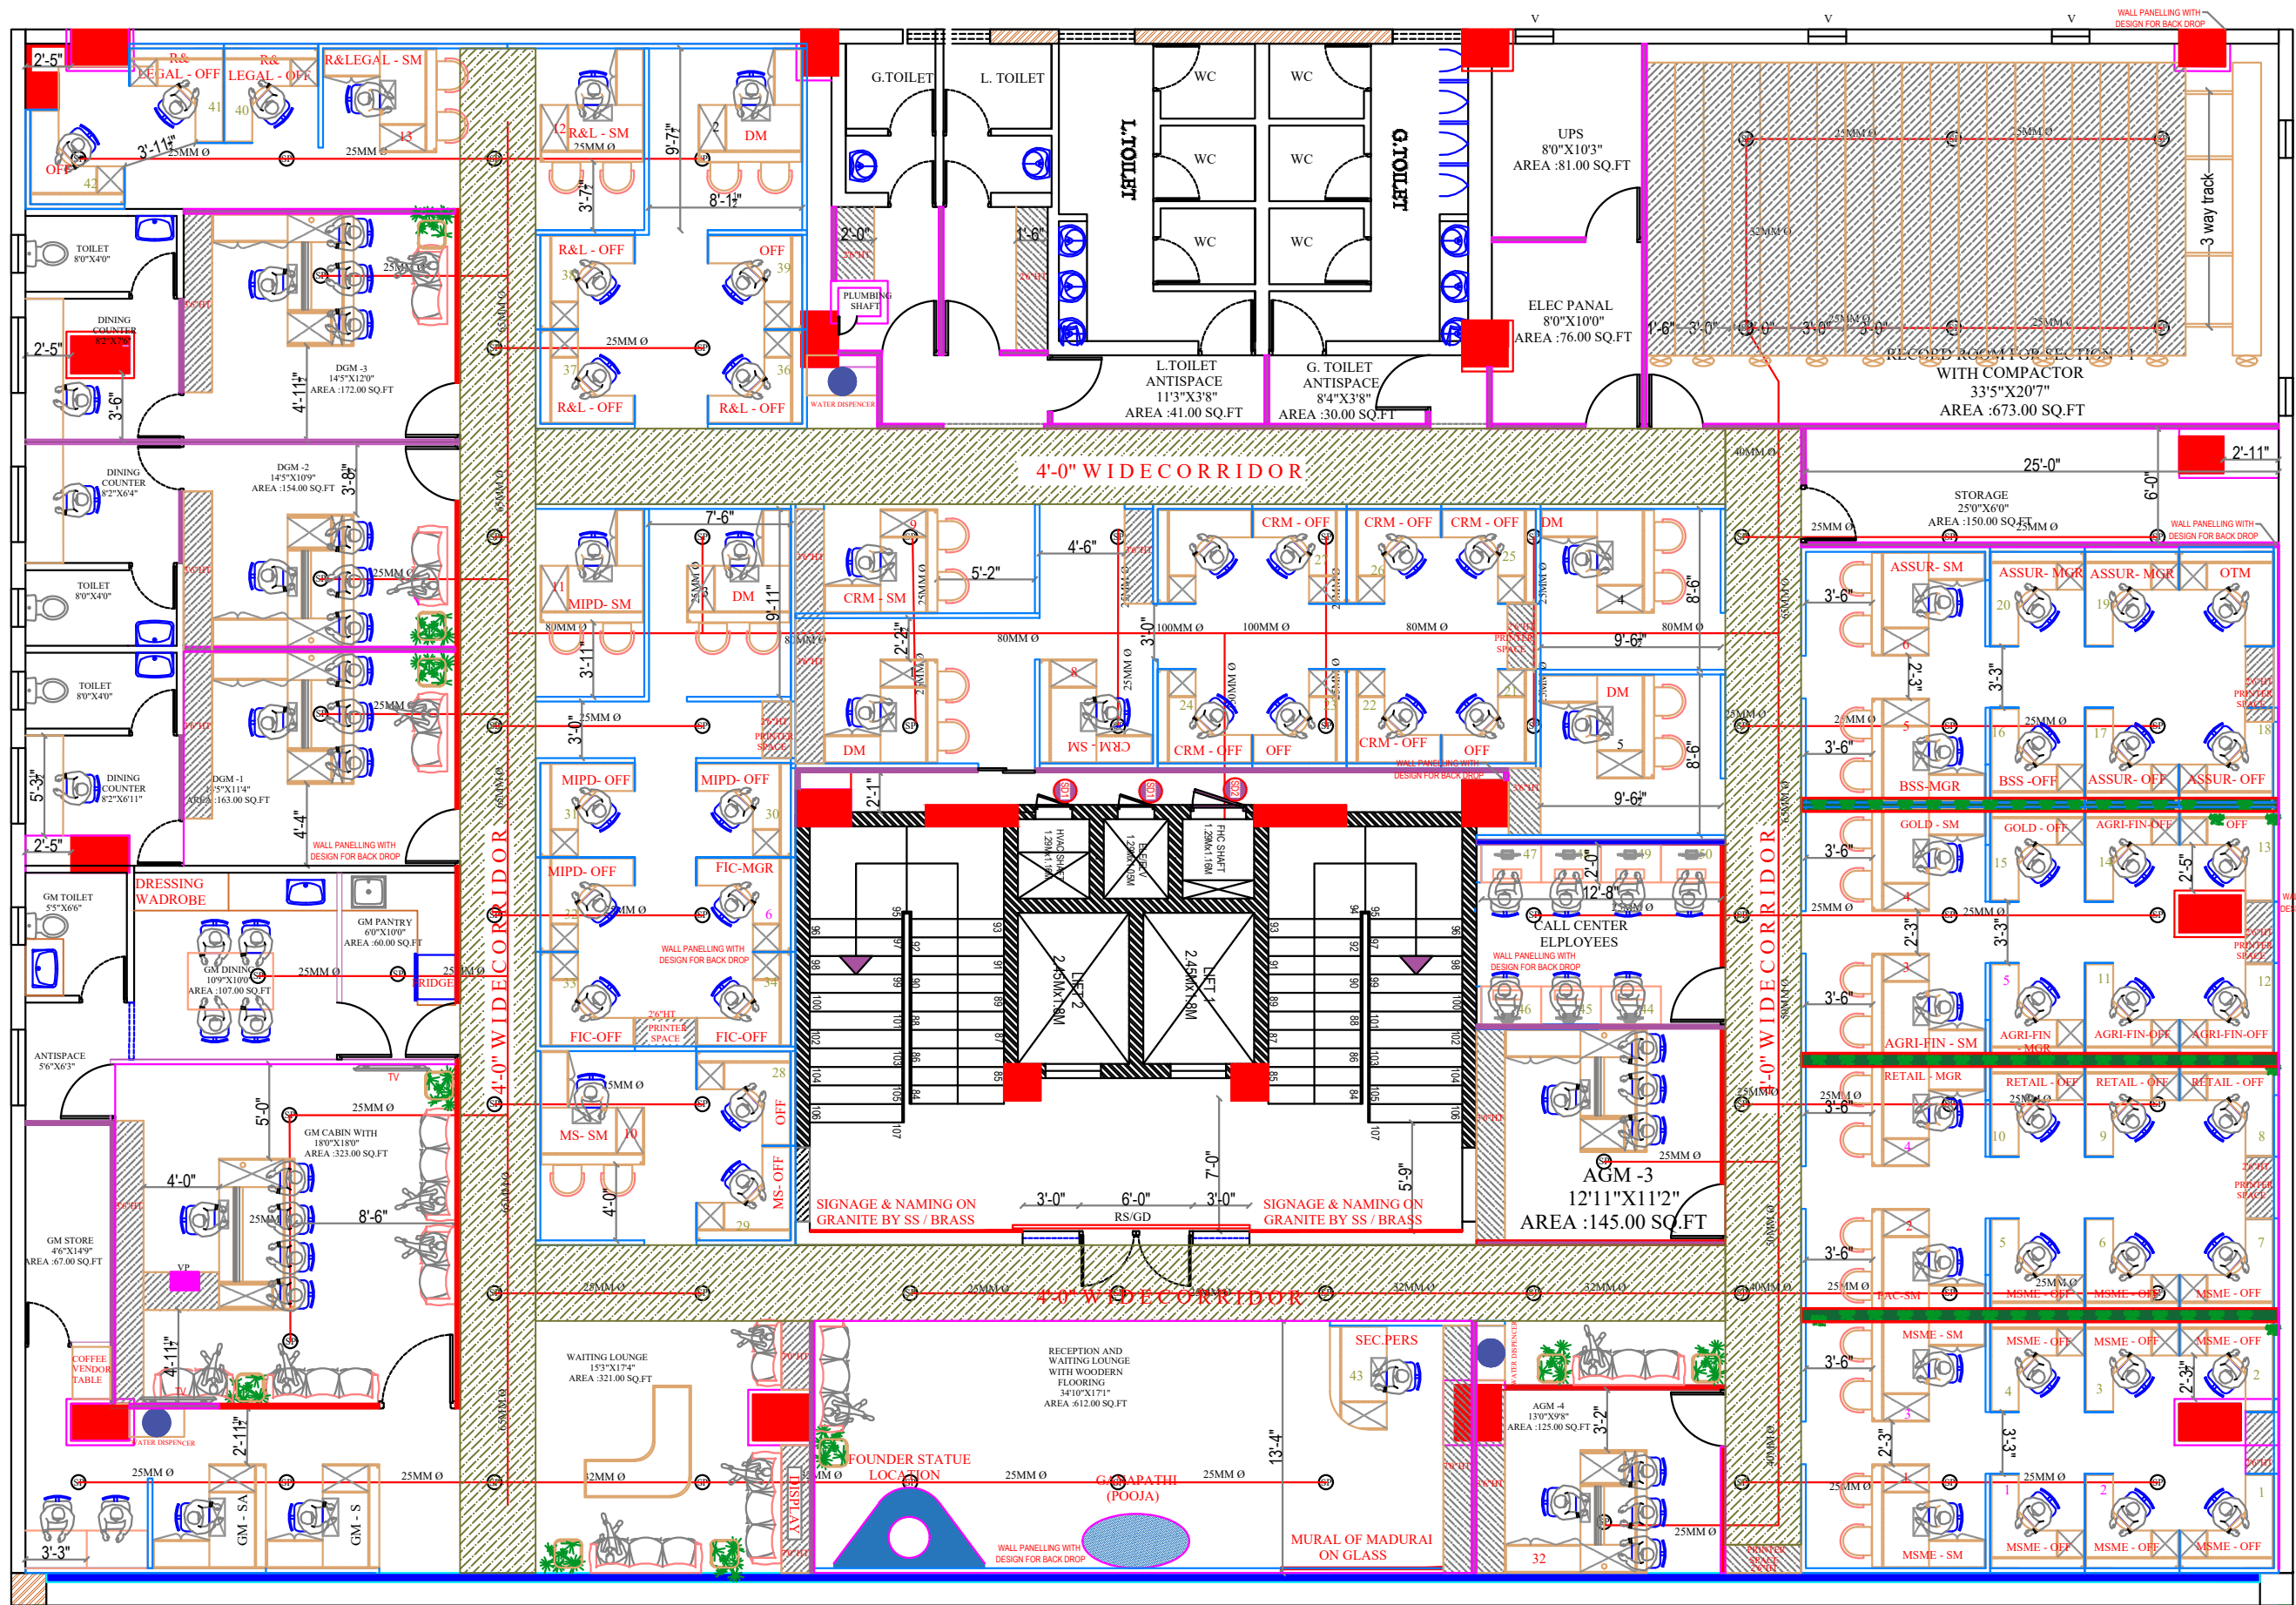

- SEMI GLAZED PARTITION
  - LOW HEIGHT PARTITION
  - FULL GLAZED PARTITION
  - FULL HEIGHT SOLID PARTITION
- GM - 1
  - DGM - 3
  - DM - 5
  - AGM - 2
  - SM - 12
  - MGR - 6
  - OFFICER - 52

CARPET AREA  
 SECOND FLOOR - 7845.10 SQ.FT  
 THIRD FLOOR - 8129.10 SQ.FT  
 TOTAL AREA - 15974.20 SQ.FT  
 (EXCLUDED TOILET & STAIRCASE)

JOB NO <b>1739</b>	PROJECT TITLE : <b>PROPOSED INTERIOR DESIGN FOR CANARA BANK CIRCLE OFFICE SAMBAKULAM ROAD, MADURAI.</b>	DRAWING TITLE :	SPRINKLER LAYOUT -THIRD FLOOR	DESIGN STAGE	SCALE	N.T.S	REV NO	REV - 19	ORIENTATION	ARCHITECTS <b>TSO DESIGN COMMUNE PVT. LTD.</b> Architects ■ Planners ■ Interior designers
		DRAWING TYPE :	SCHEMATIC DRAWING	<input type="checkbox"/> SCHEME LEVEL <input checked="" type="checkbox"/> FINAL COPY	DATE	29-04-2025	DRN	K.D		
				R.DATE	25.10.2025	CHKD	K.S			