


- SEMI GLAZED PARTITION
 - LOW HEIGHT PARTITION
 - FULL GLAZED PARTITION
 - FULL HEIGHT SOLID PARTITION
- ARM MGR - 1
 - AGM - 2
 - SM - 8
 - MGR - 8
 - OFFICER - 43

CARPET AREA
 SECOND FLOOR - 7845.10SQ.FT
 THIRD FLOOR - 8129.10 SQ.FT
 TOTAL AREA - 15974.20 SQ.FT
 (EXCLUDED TOILET & STAIRCASE)


JOB NO 1739	PROJECT TITLE : CANARA BANK CIRCLE OFFICE SAMBAKULAM ROAD, MADURAI.	DRAWING TITLE :	SECOND FLOOR INTERIOR LAYOUT	DESIGN STAGE	SCHEME LEVEL	SCALE	N.T.S	REV NO	REV - 19	ORIENTATION	ARCHITECTS TSO DESIGN COMMUNE PVT. LTD. Architects ■ Planners ■ Interior designers NEW NO.16,(OLD NO.42), Ground floor, South West Boag Road, T.Nagar, Chennai - 600017. Ph : 044 - 4212 9252 Telefax : 044 - 2435 0490 E-mail : info@tsodc.com
		DRAWING TYPE :	SCHEMATIC DRAWING		FINAL COPY	DATE	29-04-2025	DRN	K.D		
						R.DATE	25.10.2025	CHKD	K.S		

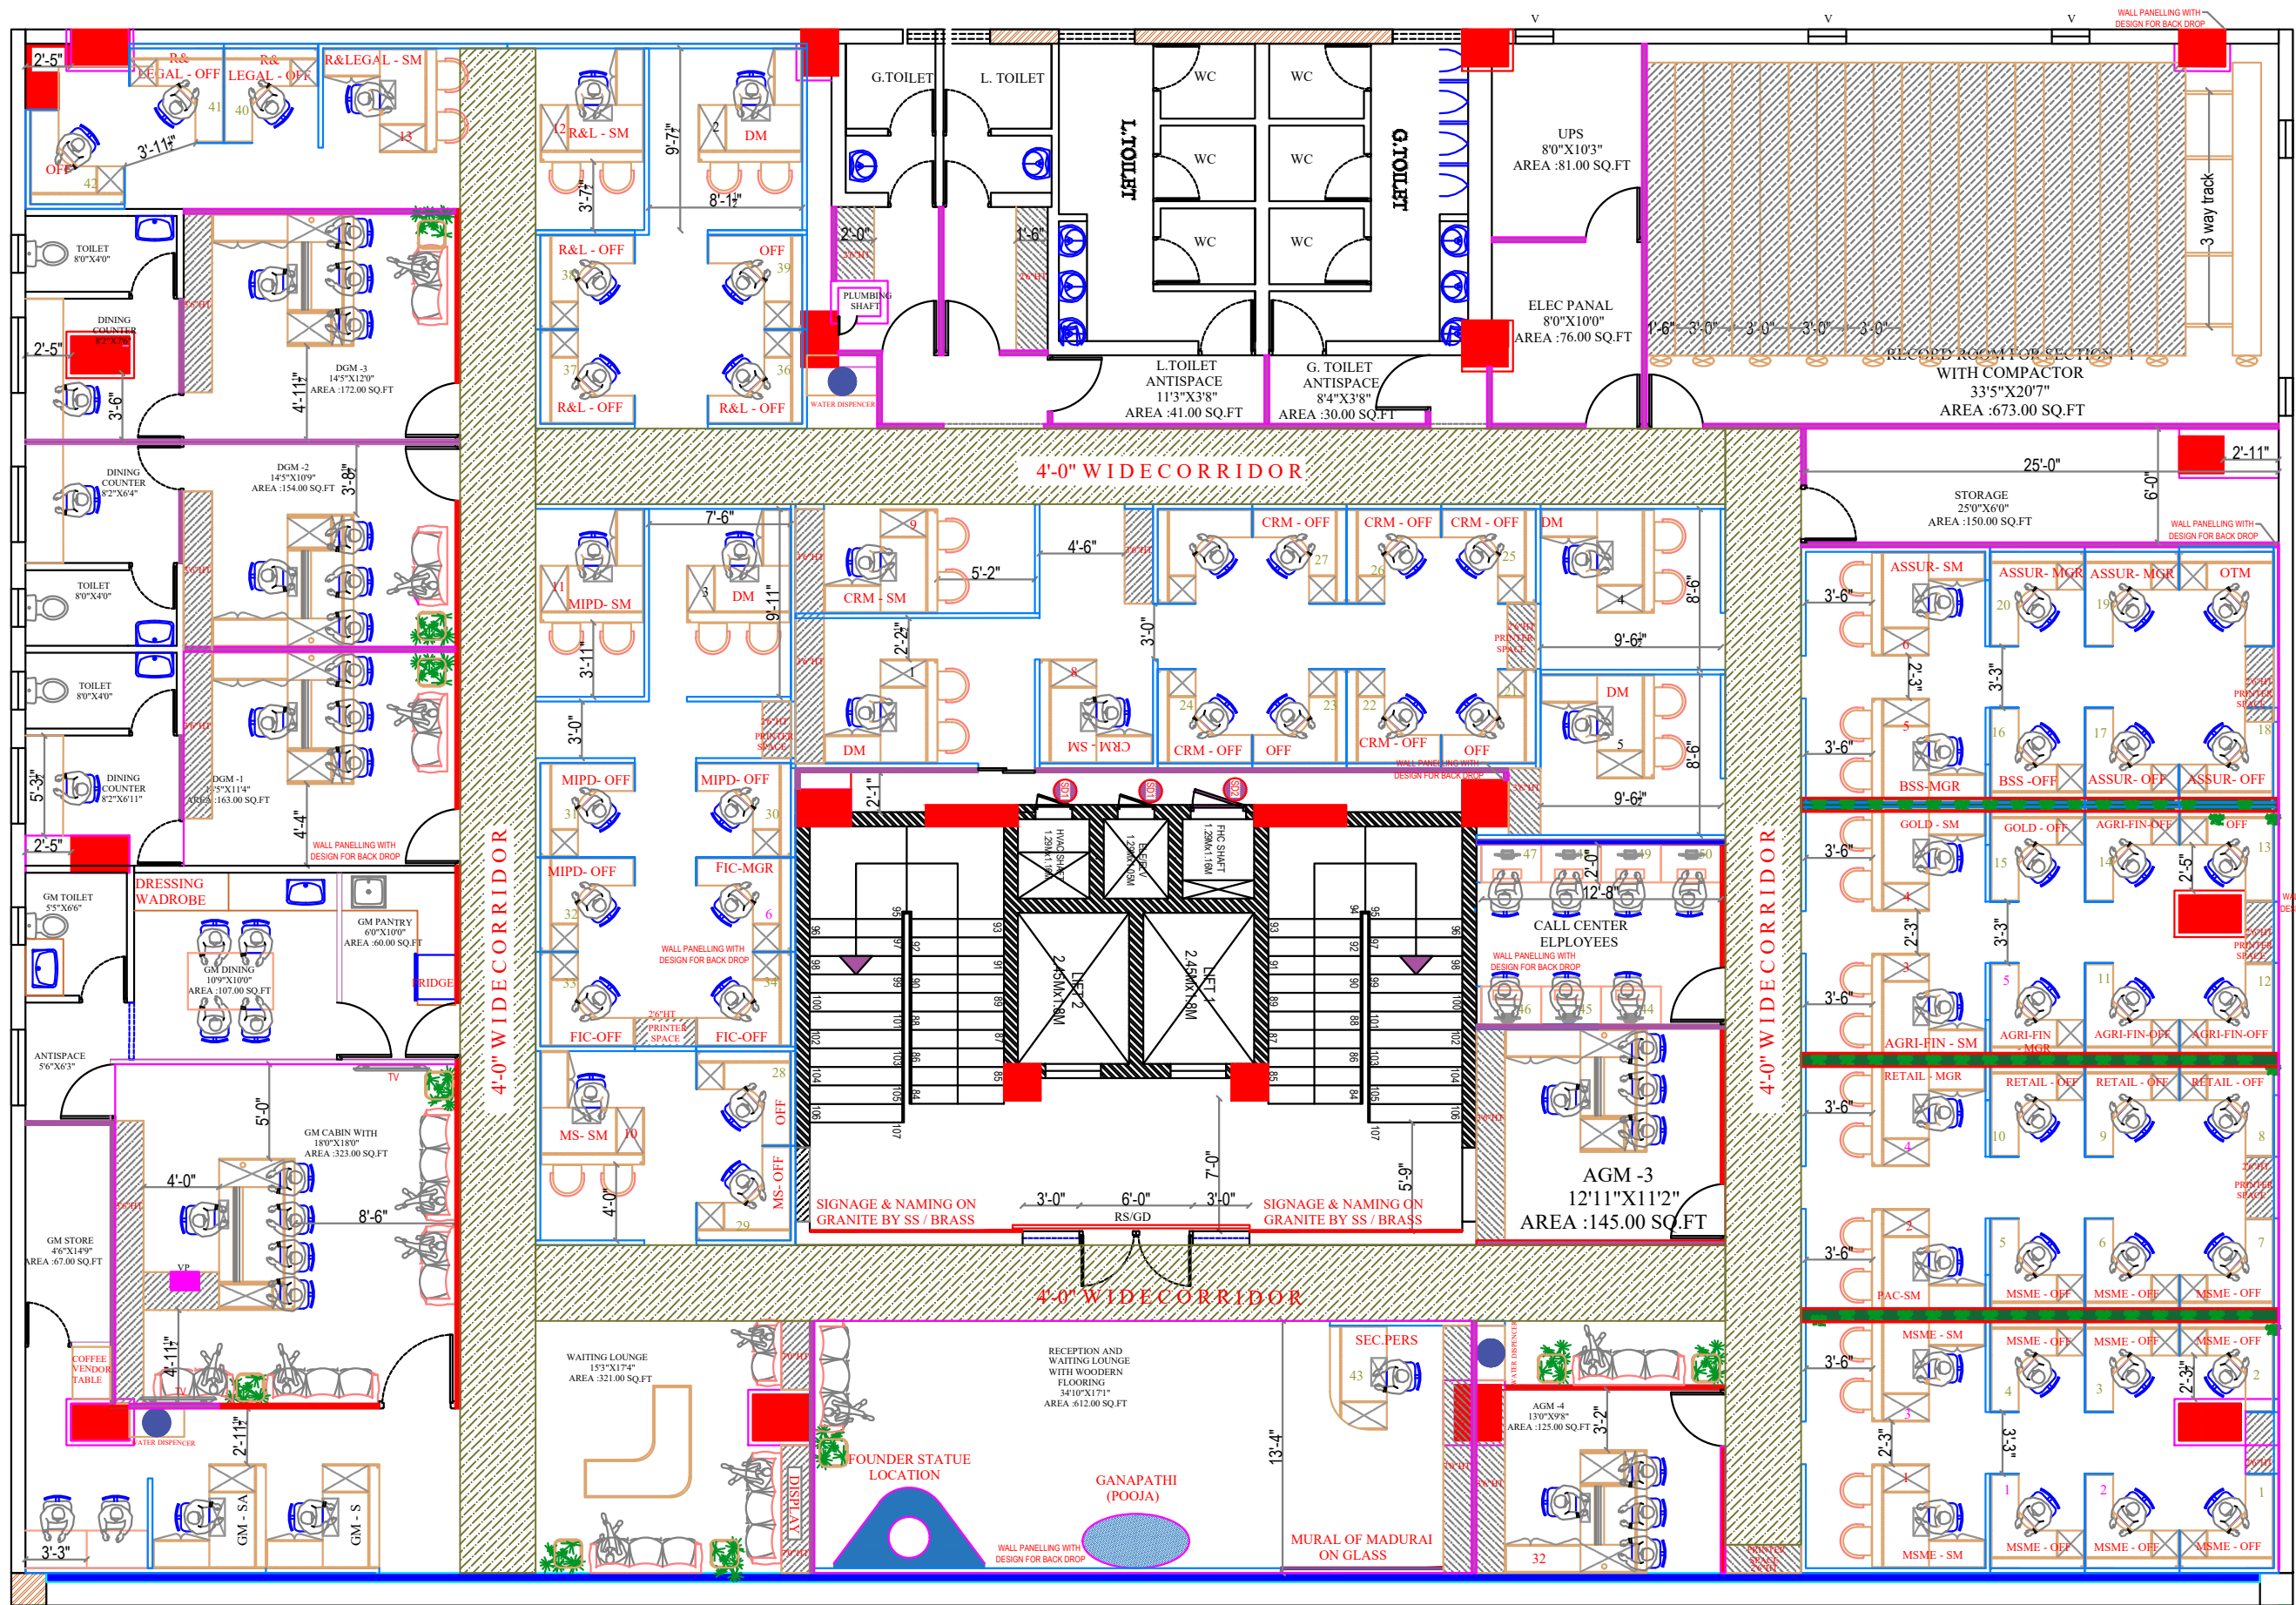

- SEMI GLAZED PARTITION
 - LOW HEIGHT PARTITION
 - FULL GLAZED PARTITION
 - FULL HEIGHT SOLID PARTITION
- | | |
|---------|------|
| GM | - 1 |
| DGM | - 3 |
| DM | - 5 |
| AGM | - 2 |
| SM | - 12 |
| MGR | - 6 |
| OFFICER | - 52 |

CARPET AREA
 SECOND FLOOR - 7845.10 SQ.FT
 THIRD FLOOR - 8129.10 SQ.FT
 TOTAL AREA - 15974.20 SQ.FT
 (EXCLUDED TOILET & STAIRCASE)

JOB NO 1739	PROJECT TITLE : PROPOSED INTERIOR DESIGN FOR CANARA BANK CIRCLE OFFICE SAMBAKULAM ROAD, MADURAI.	DRAWING TITLE : THIRD FLOOR INTERIOR LAYOUT	DESIGN STAGE SCHEME LEVEL	SCALE N.T.S	REV NO REV - 19	ORIENTATION	ARCHITECTS
		DRAWING TYPE : SCHEMATIC DRAWING	Confidential	DATE 29-04-2025	DRN K.D	CHKD K.S	 N

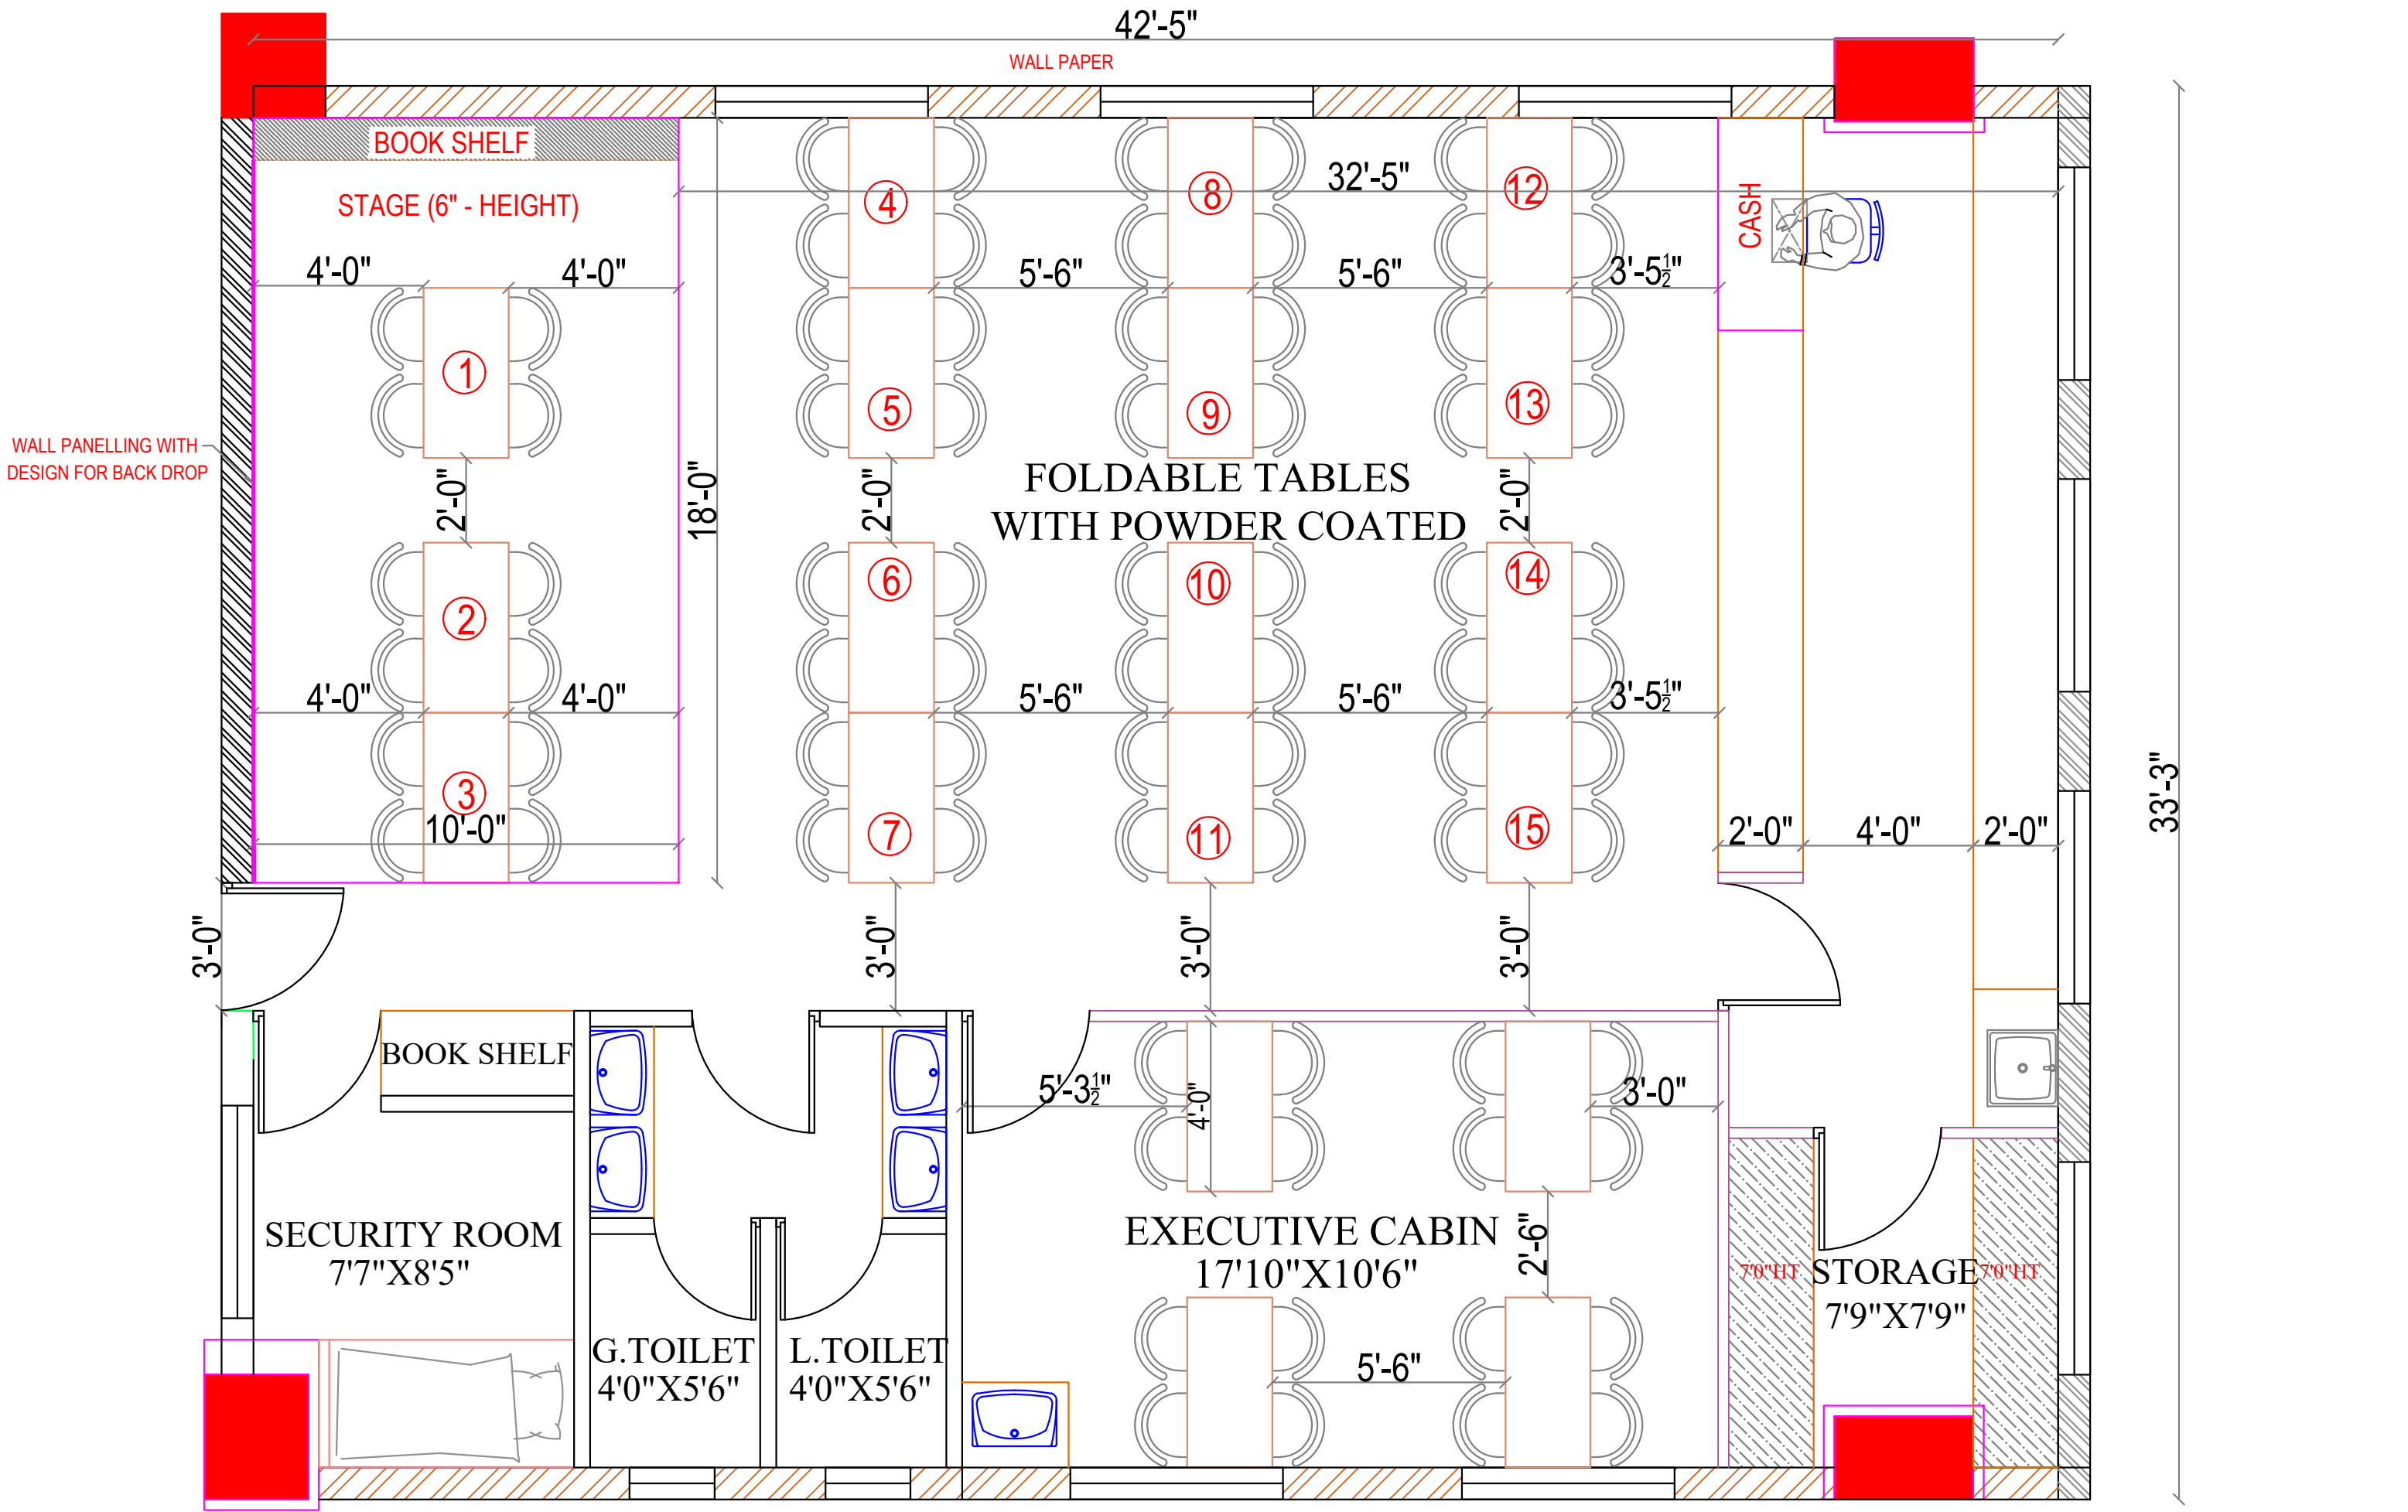


JOB NO	PROJECT TITLE :	PROPOSED INTERIOR DESIGN FOR	DRAWING TITLE :	DESIGN STAGE	SCALE	N.T.S	REV NO	TERR.F-18	ORIENTATION	ARCHITECTS
1739	CANARA BANK CIRCLE OFFICE SAMBAKULAM ROAD, MADURAI.		TERRACE FLOOR DINING LAYOUT	Confidential SCHEME LEVEL	DATE	29-04-2025	DRN	K.D		
		DRAWING TYPE :	SCHEMATIC DRAWING	FINAL COPY	R.DATE	03.10.2025	CHKD	K.S		

TSO DESIGN COMMUNE PVT. LTD.
Architects ■ Planners ■ Interior designers

NEW NO.16,(OLD NO.42), Ground floor, South West Boag Road,
T.Nagar, Chennai - 600017. Ph : 044 - 4212 9252
Telefax : 044 - 2435 0493 E-mail : info@tsodc.com

25'-6"

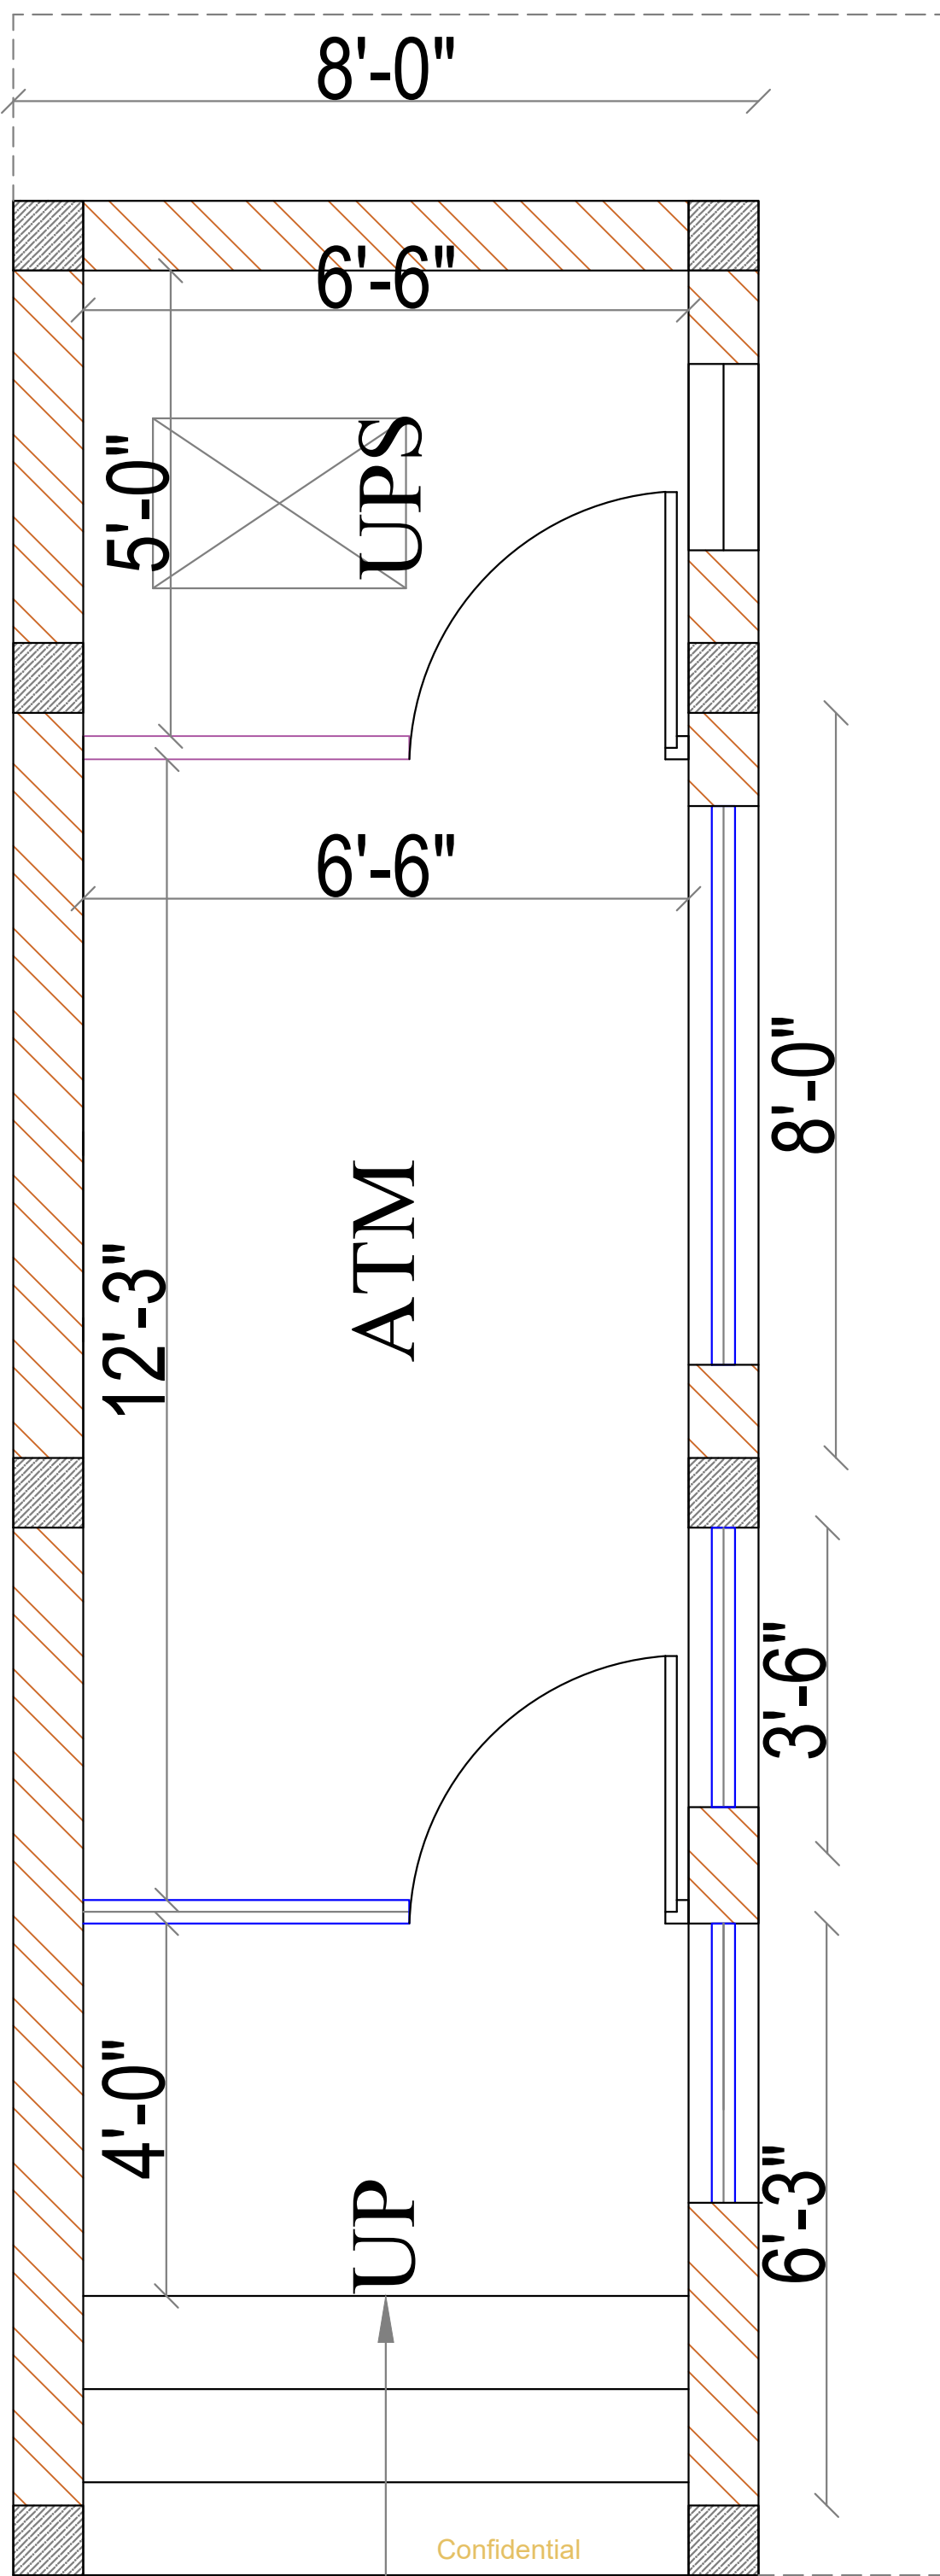

Confidential

JOB NO

1739

PROJECT TITLE :

PROPOSED INTERIOR DESIGN FOR

CANARA BANK CIRCLE OFFICE

SAMBAKULAM ROAD, MADURAI.

DRAWING TITLE :

ATM

DRAWING TYPE :

SCHEMATIC DRAWING

DESIGN STAGE

SCHEME LEVEL

FINAL COPY

SCALE

DATE

R.DATE

N.T.S

29-04-2025

03.10.2025

REV/NO

DRN

CHKD

TERR.F-04

M.G

K.S


ORIENTATION



ARCHITECTS



TSO DESIGN COMMUNE PVT. LTD.
 Architects • Planners • Interior designers
 NEW NO.16, OLD NO.43, Ground floor, South West Bang Road,
 Nagar, Chennai - 600 026.
 Tel: 044-245 9493 E-mail: info@tsoc.com

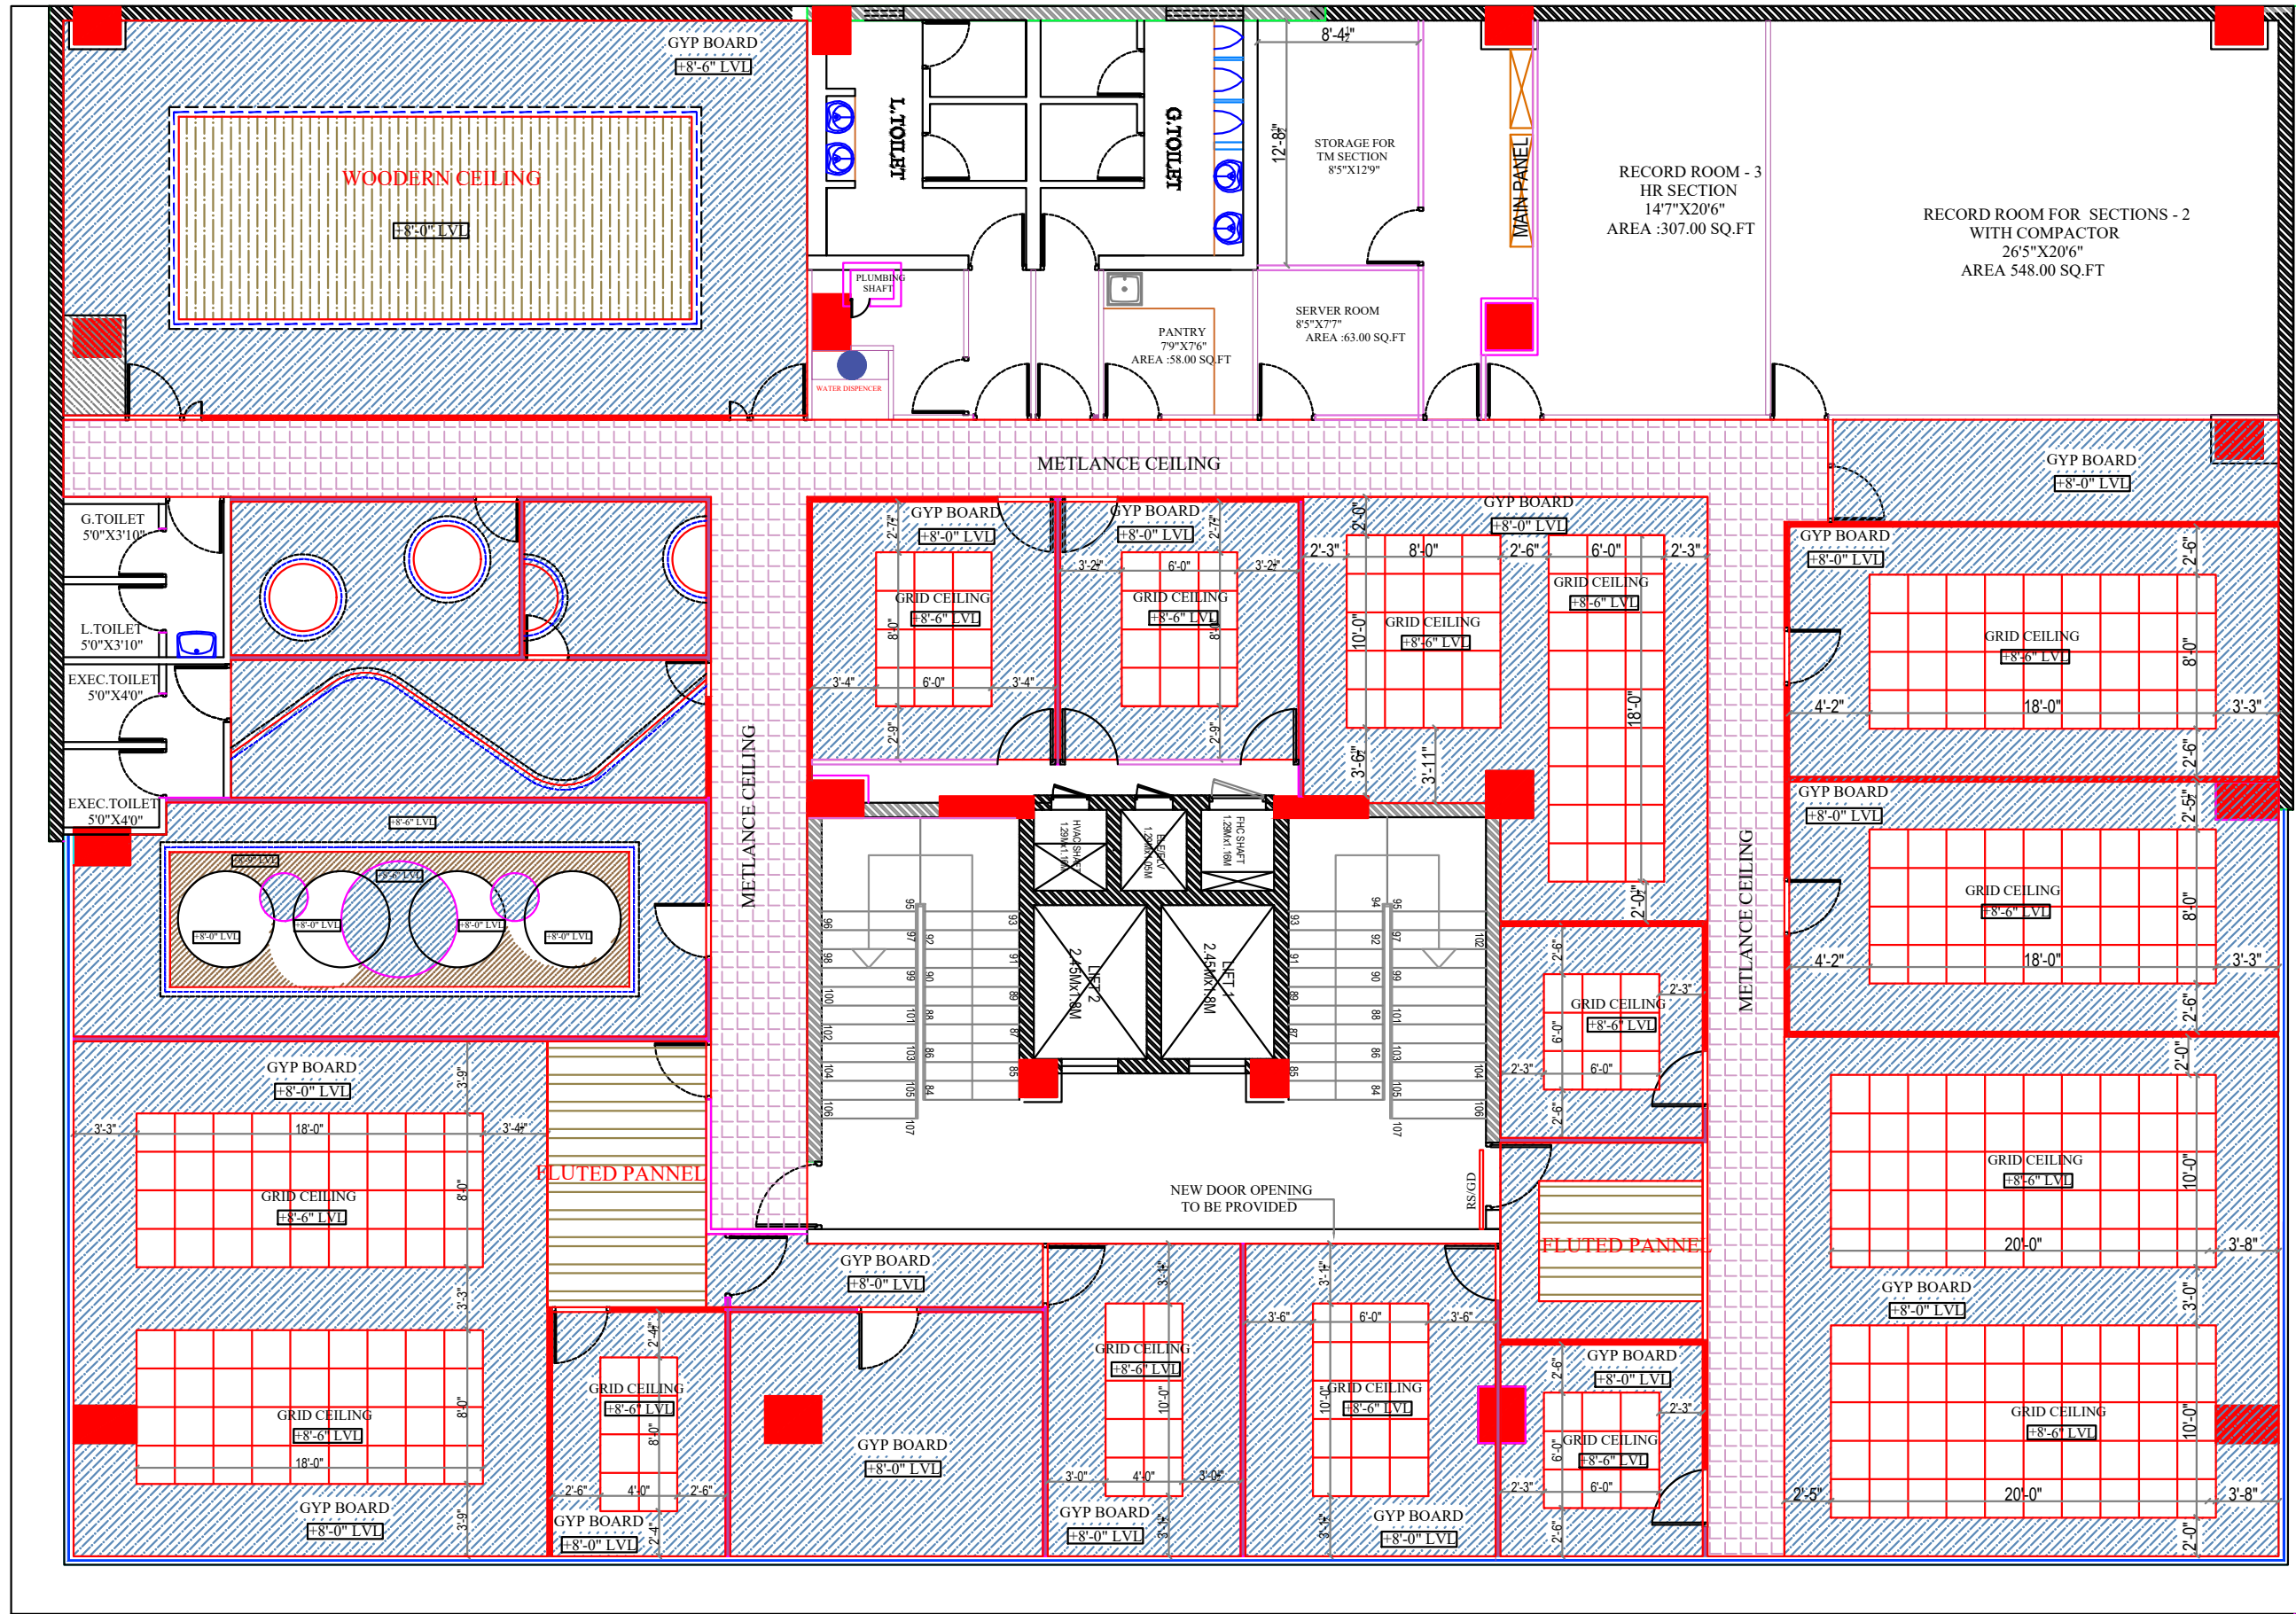


- LOW HEIGHT PARTITION
 - FULL GLAZED PARTITION
 - FULL HEIGHT SOLID PARTITION
- | | |
|---------|------|
| ARM MGR | - 1 |
| AGM | - 2 |
| SM | - 8 |
| MGR | - 8 |
| OFFICER | - 43 |

CARPET AREA
 SECOND FLOOR - 7845.10SQ.FT
 THIRD FLOOR - 8129.10 SQ.FT
 TOTAL AREA - 15974.20 SQ.FT
 (EXCLUDED TOILET & STAIRCASE)

JOB NO	PROJECT TITLE : PROPOSED INTERIOR DESIGN FOR CANARA BANK CIRCLE OFFICE SAMBAKULAM ROAD, MADURAI.	DRAWING TITLE : SECOND FLOOR INTERIOR LAYOUT	DESIGN STAGE SCHEME LEVEL	SCALE N.T.S	REV NO REV - 18	ORIENTATION N	ARCHITECTS TSO DESIGN COMMUNE PVT. LTD. Architects ■ Planners ■ Interior designers
1739		DRAWING TYPE : SCHEMATIC DRAWING	CONFIDENTIAL FINAL COPY	DATE 29-04-2025	DRN K.D		
				R.DATE 03.10.2025	CHKD K.S		

NEW NO.16,(OLD NO.42), Ground floor, South West Boag Road,
 T.Nagar, Chennai - 600017. Ph : 044 - 4212 9252
 Telefax : 044 - 2435 0493 E-mail : info@tsodc.com

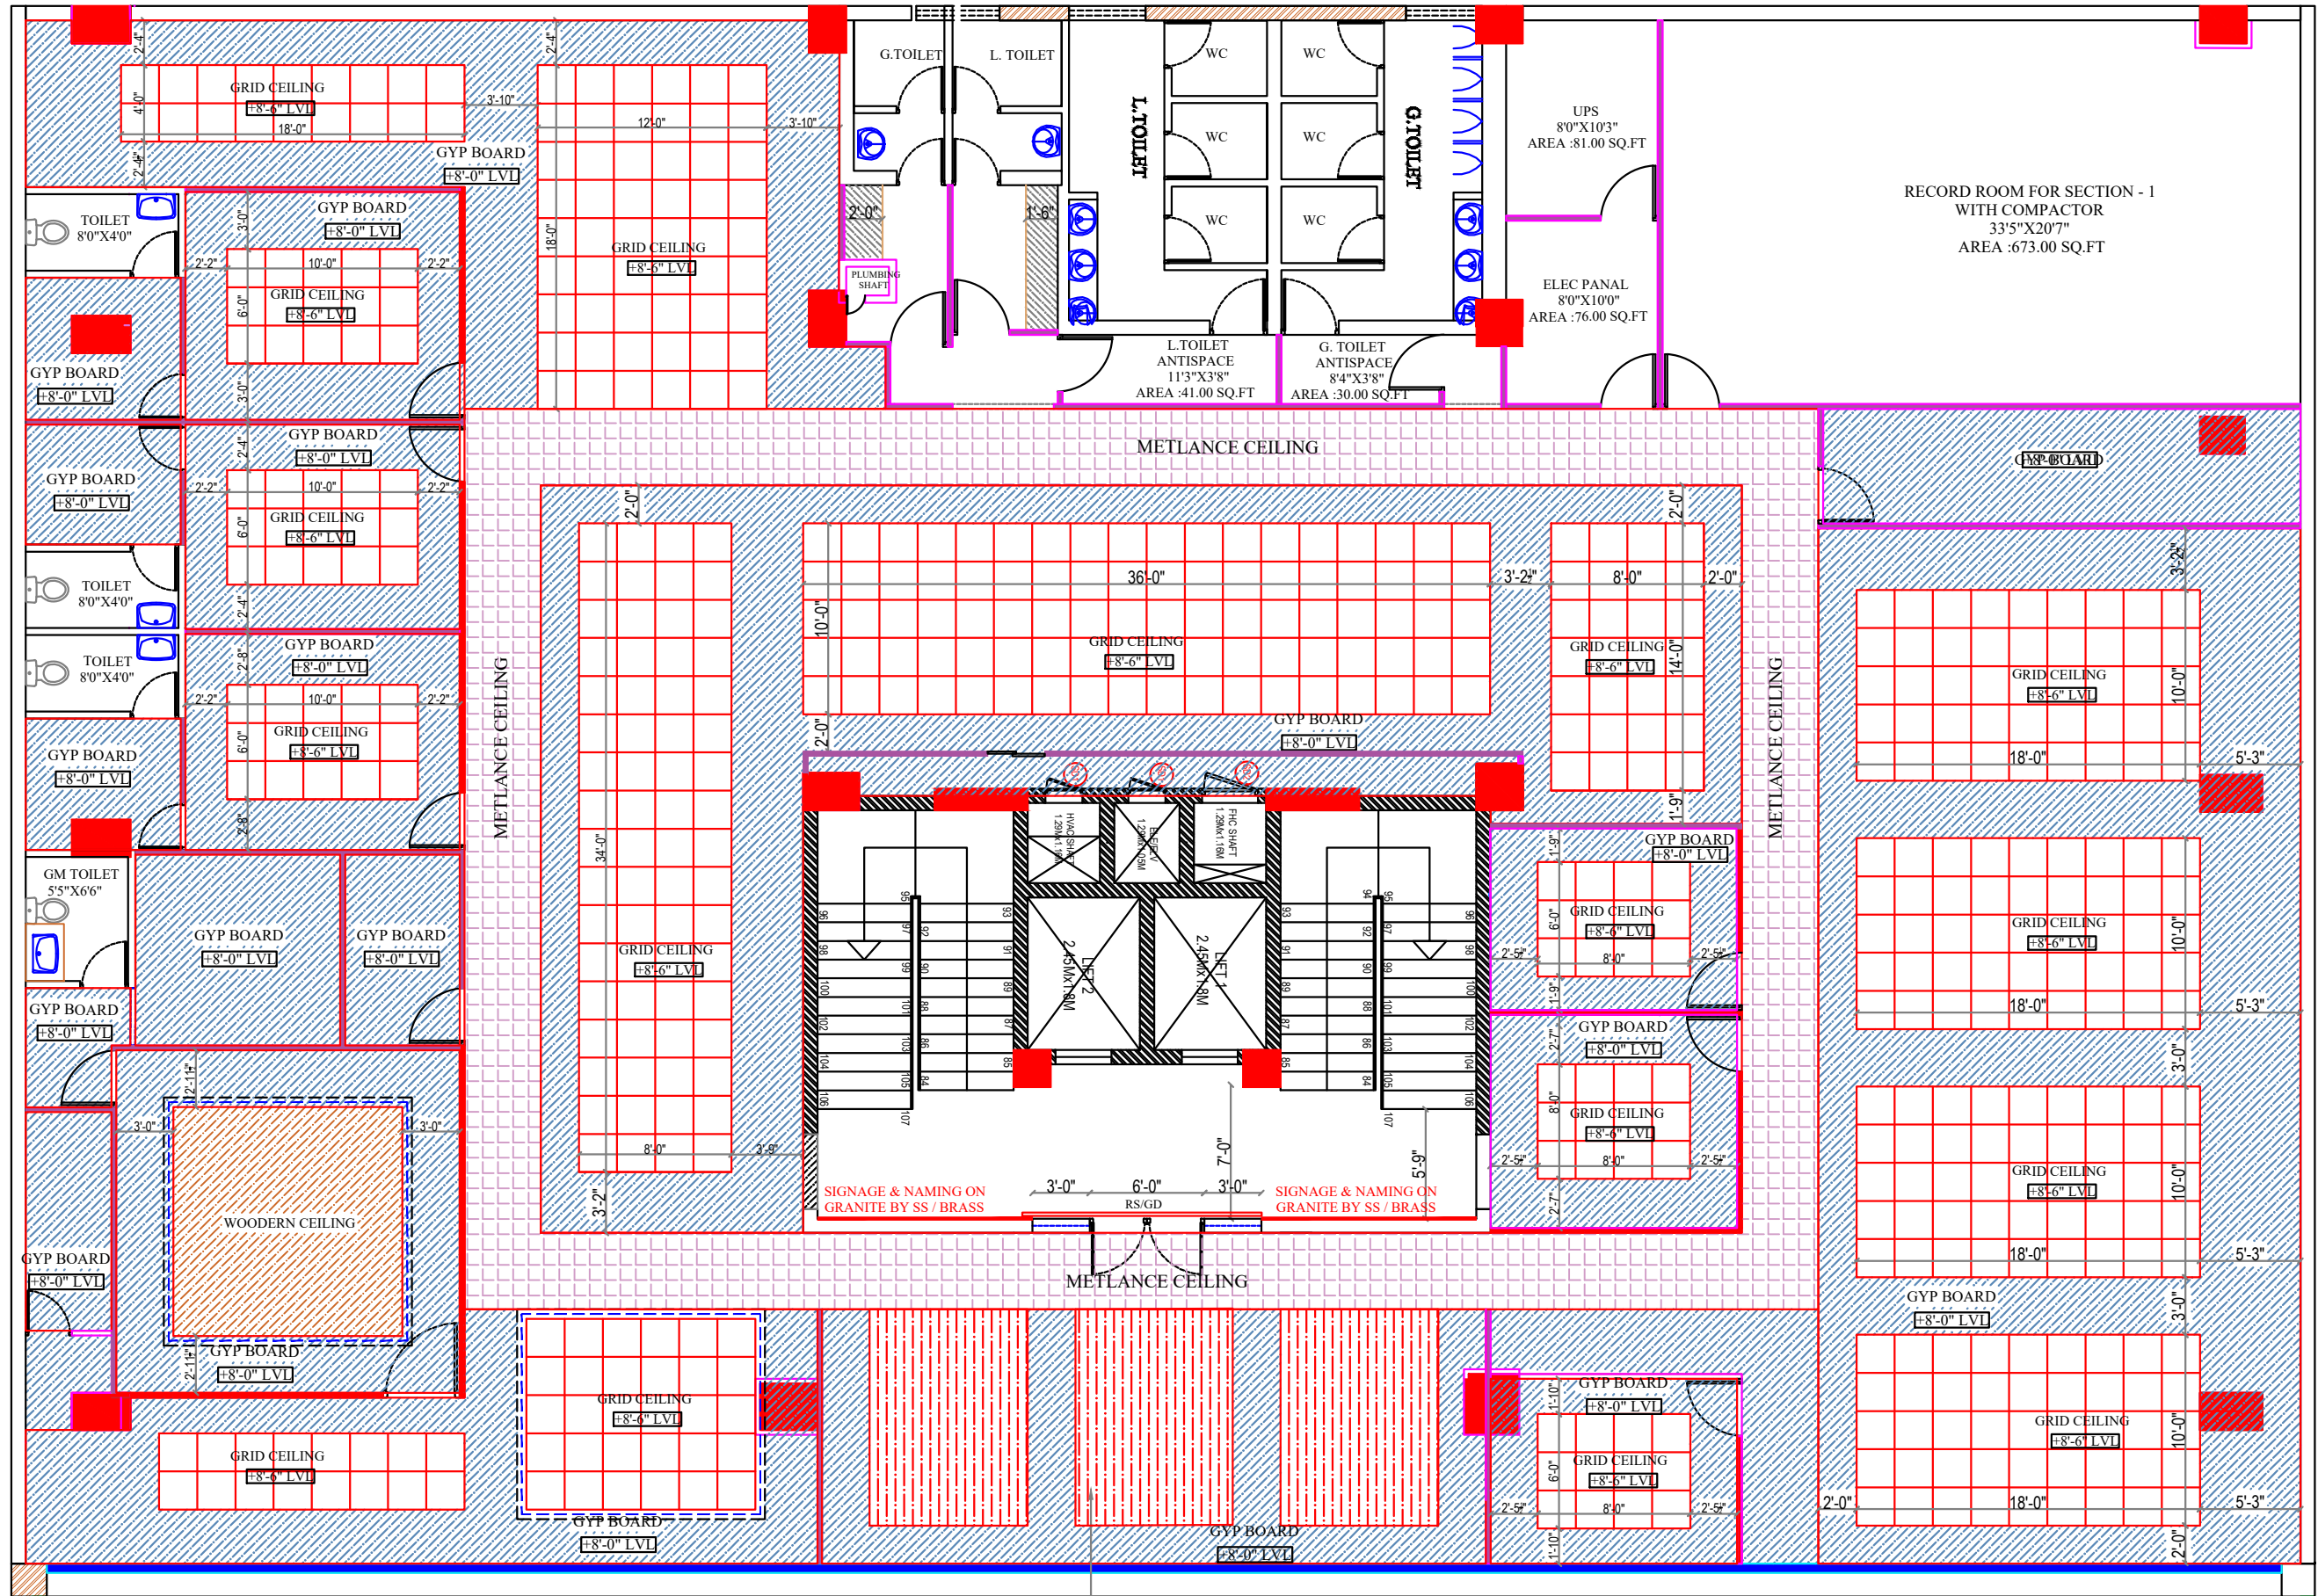

RECORD ROOM FOR SECTION - 1
WITH COMPACTOR
33'5"X20'7"
AREA : 673.00 SQ.FT

UPS
8'0"X10'3"
AREA : 81.00 SQ.FT

ELEC PANAL
8'0"X10'0"
AREA : 76.00 SQ.FT

L. TOILET ANTISPAC
11'3"X3'8"
AREA : 41.00 SQ.FT

G. TOILET ANTISPAC
8'4"X3'8"
AREA : 30.00 SQ.FT

- LOW HEIGHT PARTITION
- FULL GLAZED PARTITION
- FULL HEIGHT SOLID PARTITION


- GM - 1
- DGM - 3
- DM - 5
- AGM - 2
- SM - 12
- MGR - 6
- OFFICER - 52

CARPET AREA
SECOND FLOOR - 7845.10SQ.FT
THIRD FLOOR - 8129.10 SQ.FT
TOTAL AREA - 15974.20 SQ.FT
(EXCLUDED TOILET & STAIRCASE)

STRETCH CEILING WITH
BACK LED LIGHT

JOB NO 1739	PROJECT TITLE : PROPOSED INTERIOR DESIGN FOR CANARA BANK CIRCLE OFFICE SAMBAKULAM ROAD, MADURAI.	DRAWING TITLE :	THIRD FLOOR INTERIOR LAYOUT	DESIGN STAGE	SCHEME LEVEL	SCALE	N.T.S	REV NO	REV - 18	ORIENTATION	ARCHITECTS T.S.O DESIGN COMMUNE PVT. LTD. Architects ■ Planners ■ Interior designers
		DRAWING TYPE :	SCHEMATIC DRAWING			DATE	29-04-2025	DRN	K.D		
					FINAL COPY	R.DATE	03.10.2025	CHKD	K.S		

NEW NO.16,(OLD NO.42), Ground floor, South West Boag Road,
T.Nagar, Chennai - 600017. Ph : 044 - 4212 9252
Telefax : 044 - 2435 0493 E-mail : info@tsoc.com

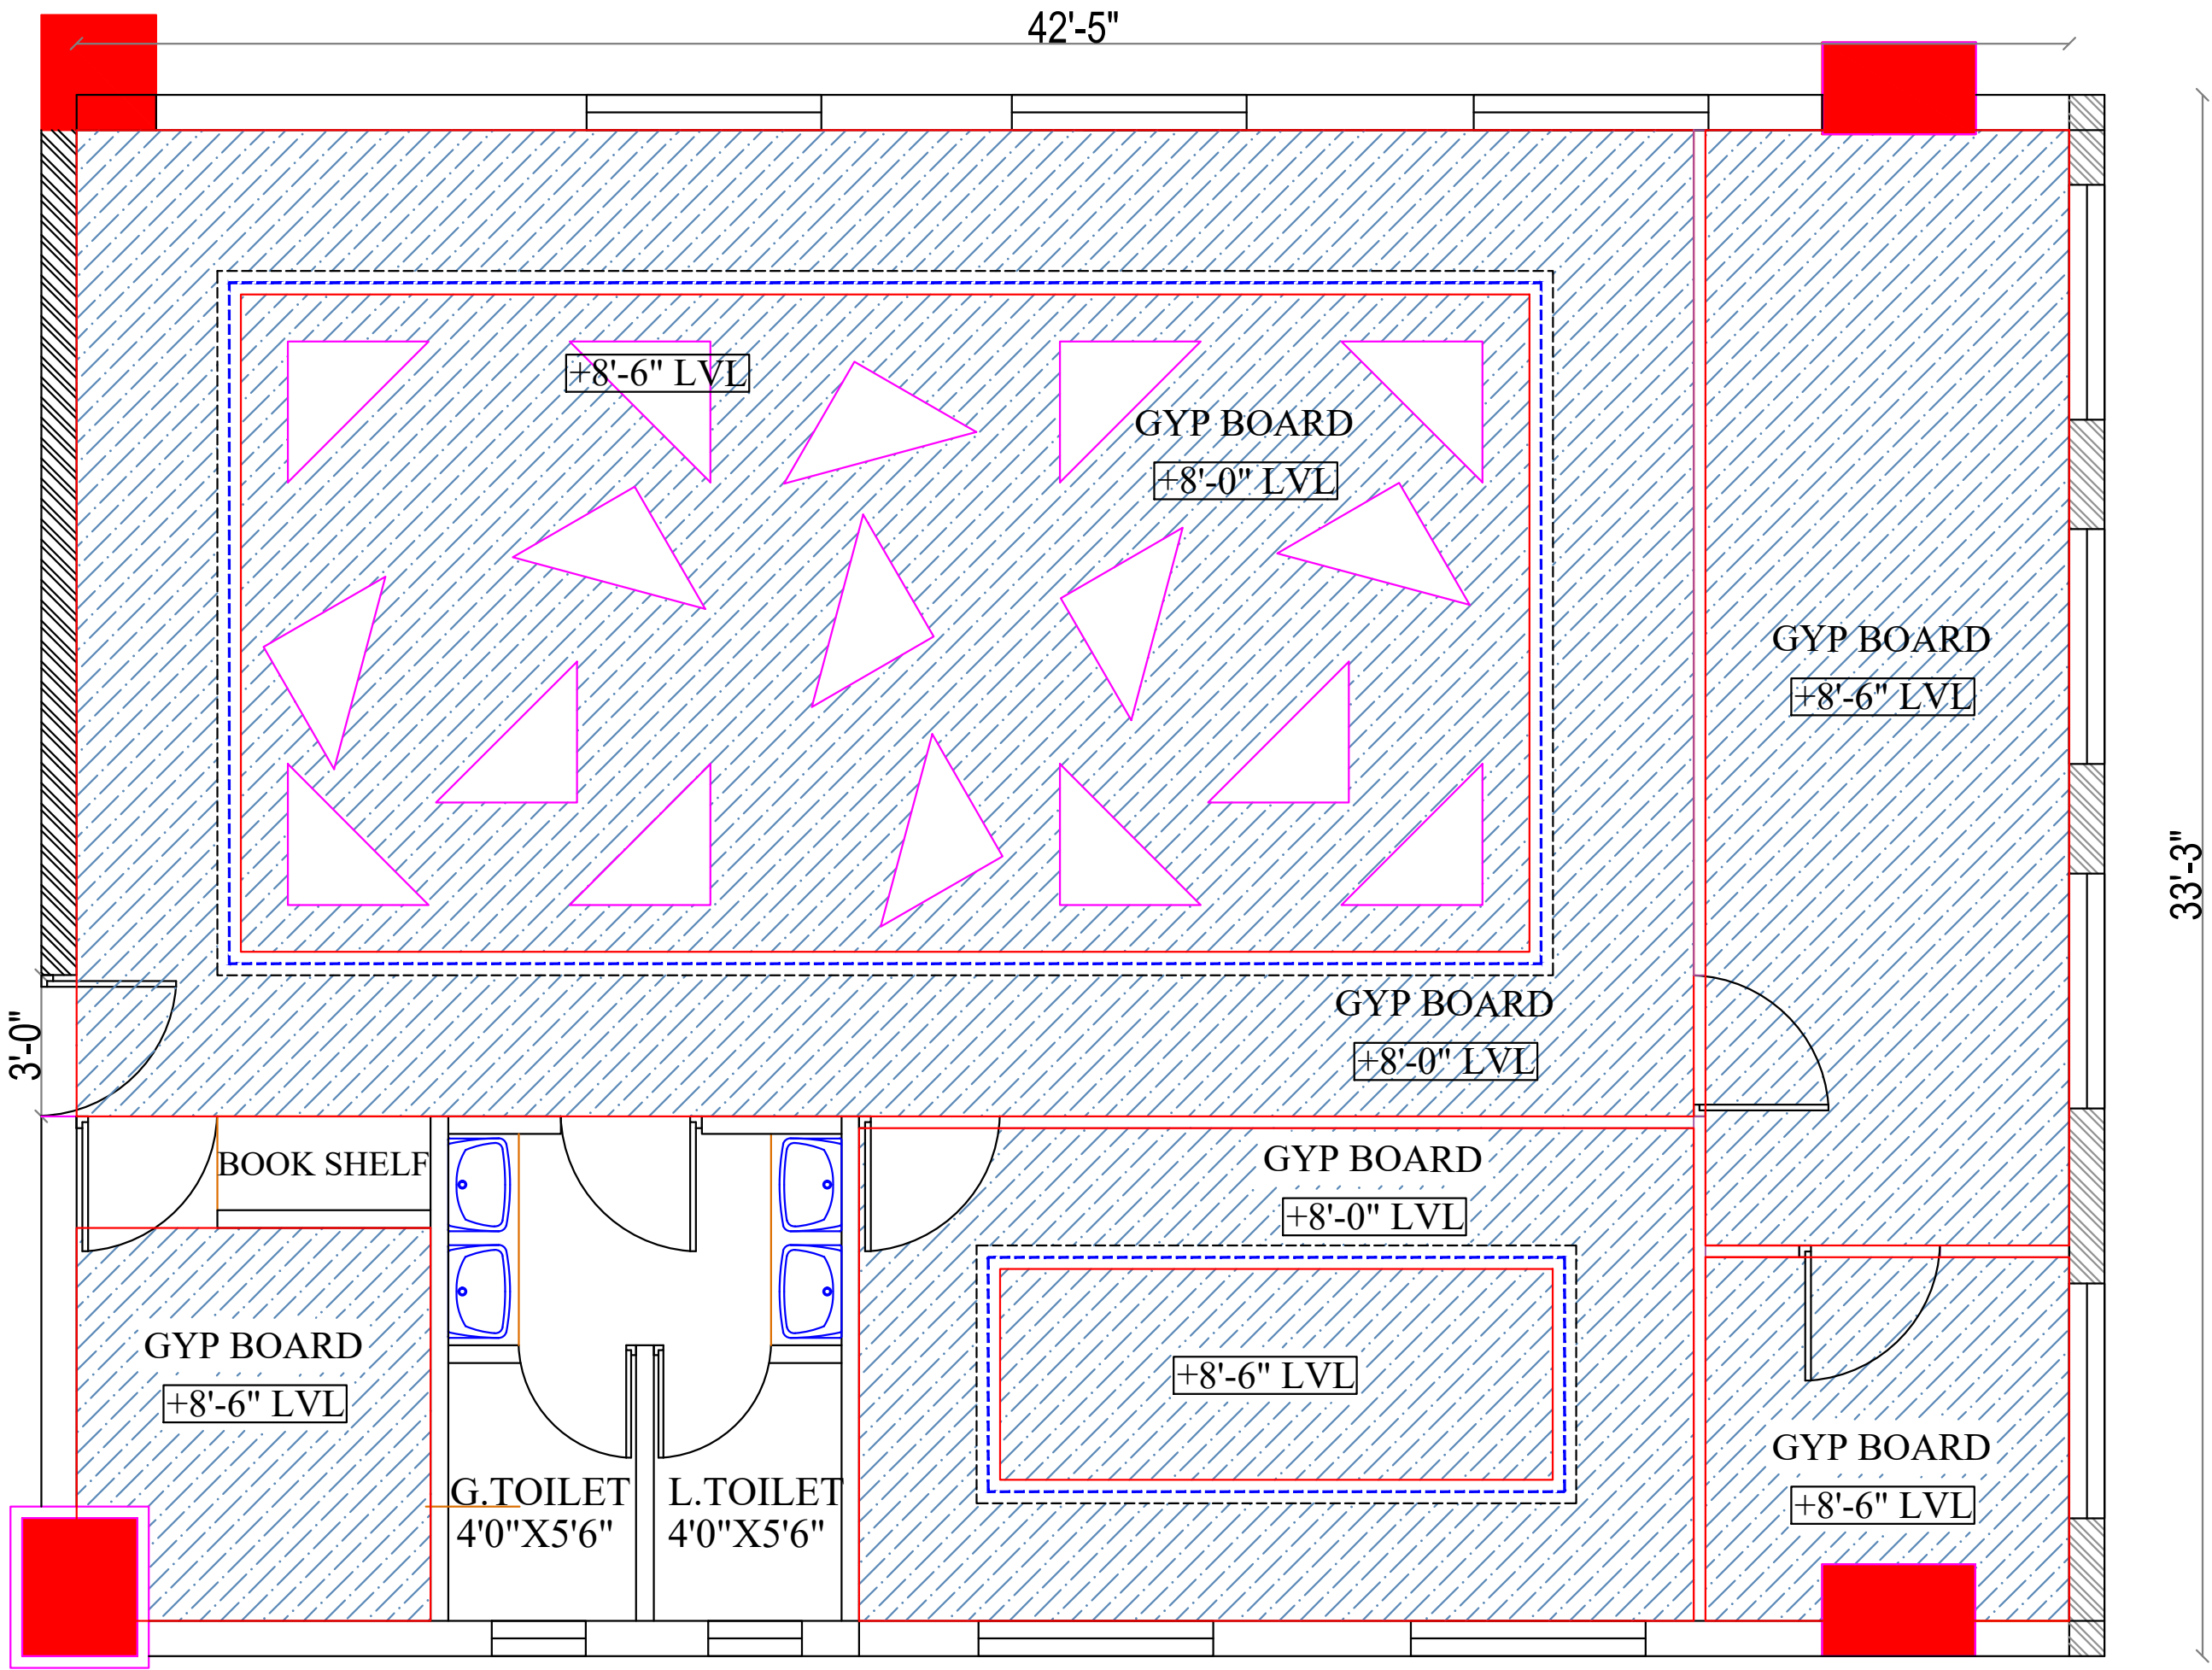

JOB NO	PROJECT TITLE :	PROPOSED INTERIOR DESIGN FOR	DRAWING TITLE :	DESIGN STAGE	SCALE	N.T.S	REV NO	TERR.F-18	ORIENTATION	ARCHITECTS
1739	CANARA BANK CIRCLE OFFICE SAMBAKULAM ROAD, MADURAI.	TERRACE FLOOR DINING LAYOUT	SCHME LEVEL	DATE	29-04-2025	DRN	K.D			TSO DESIGN COMMUNE PVT. LTD. Architects ■ Planners ■ Interior designers <small>NEW NO.16,(OLD NO.42), Ground floor, South West Boag Road, T.Nagar, Chennai - 600017. Ph : 044 - 4212 9252 Telefax : 044 - 2435 0493 E-mail : info@tsodc.com</small>
		DRAWING TYPE :	SCHMEATIC DRAWING	FINAL COPY	R.DATE	03.10.2025	CHKD			

25'-6"

8'-0"

GYP BOARD

+8'-0" LVL

GYP BOARD

+8'-0" LVL

GYP BOARD

+8'-0" LVL

UP

 
8'-0"

3'-6"

6'-3"

Confidential

ARCHITECTS



TSO DESIGN COMMUNE PVT. LTD.
Architects • Planners • Interior designers
NEW NO.16, GILD NO.421, Ground floor, South West Bang Road,
Kadambur, Chennai - 604 722, Tamil Nadu
Phone: 044-245 9495 E-mail: info@tsocorp.com

ORIENTATION



TERR.F-04

M.G
K.S

REV/NO

DRN
CHKD

N.T.S

29-04-2025
03.10.2025

SCALE

DATE
R.DATE

DESIGN STAGE

SCHEME LEVEL
FINAL COPY

DRAWING TITLE : ATM


DRAWING TYPE : SCHEMATIC DRAWING

PROPOSED INTERIOR DESIGN FOR

CANARA BANK CIRCLE OFFICE
SAMBAKULAM ROAD, MADURAI.

PROJECT TITLE :


JOB NO
1739

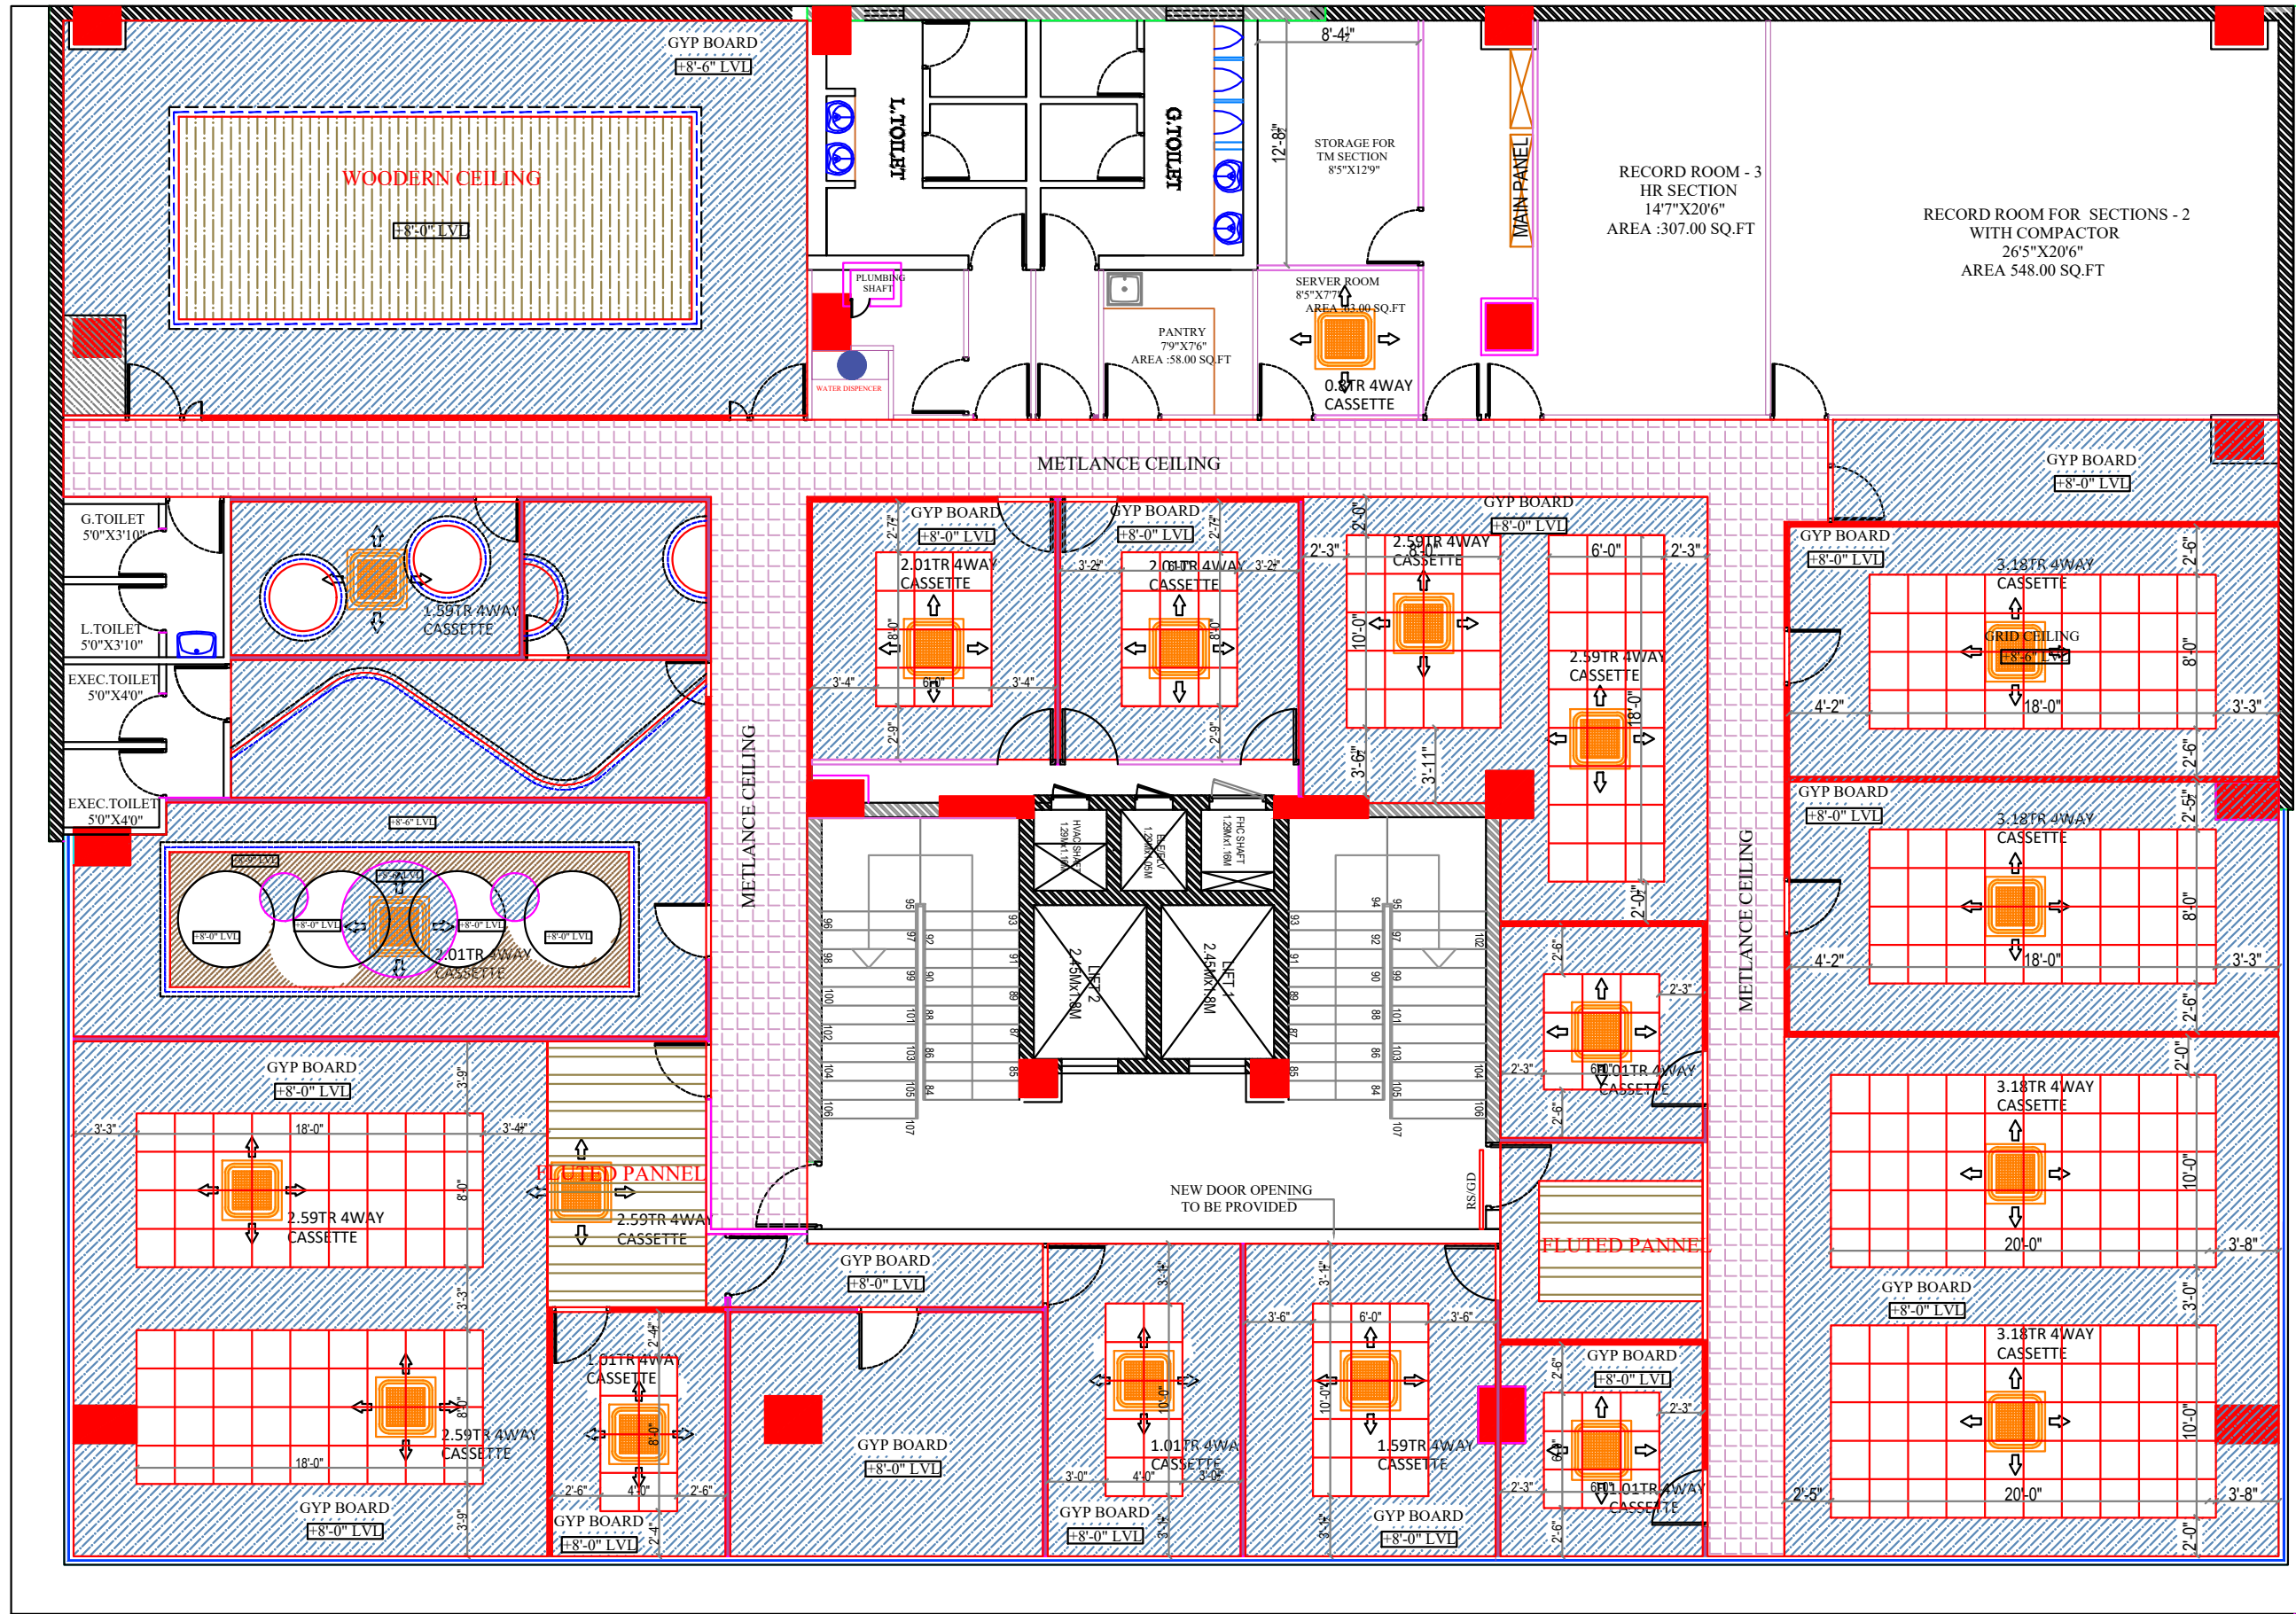

- LOW HEIGHT PARTITION
 - FULL GLAZED PARTITION
 - FULL HEIGHT SOLID PARTITION
- | | |
|--------------|--|
| ARM MGR - 1 | |
| AGM - 2 | |
| SM - 8 | |
| MGR - 8 | |
| OFFICER - 43 | |

CARPET AREA
 SECOND FLOOR - 7845.10SQ.FT
 THIRD FLOOR - 8129.10 SQ.FT
 TOTAL AREA - 15974.20 SQ.FT
 (EXCLUDED TOILET & STAIRCASE)

JOB NO	PROJECT TITLE :	PROPOSED INTERIOR DESIGN FOR	DRAWING TITLE :	DESIGN STAGE	SCALE	N.T.S	REV NO	REV - 18	ORIENTATION	ARCHITECTS
1739	CANARA BANK CIRCLE OFFICE SAMBAKULAM ROAD, MADURAI.		SECOND FLOOR - AC LAYOUT	SCHEME LEVEL	DATE	29-04-2025	DRN	K.D		
			DRAWING TYPE :	WORKING DRAWING	FINAL COPY	R.DATE	03.10.2025	CHKD		

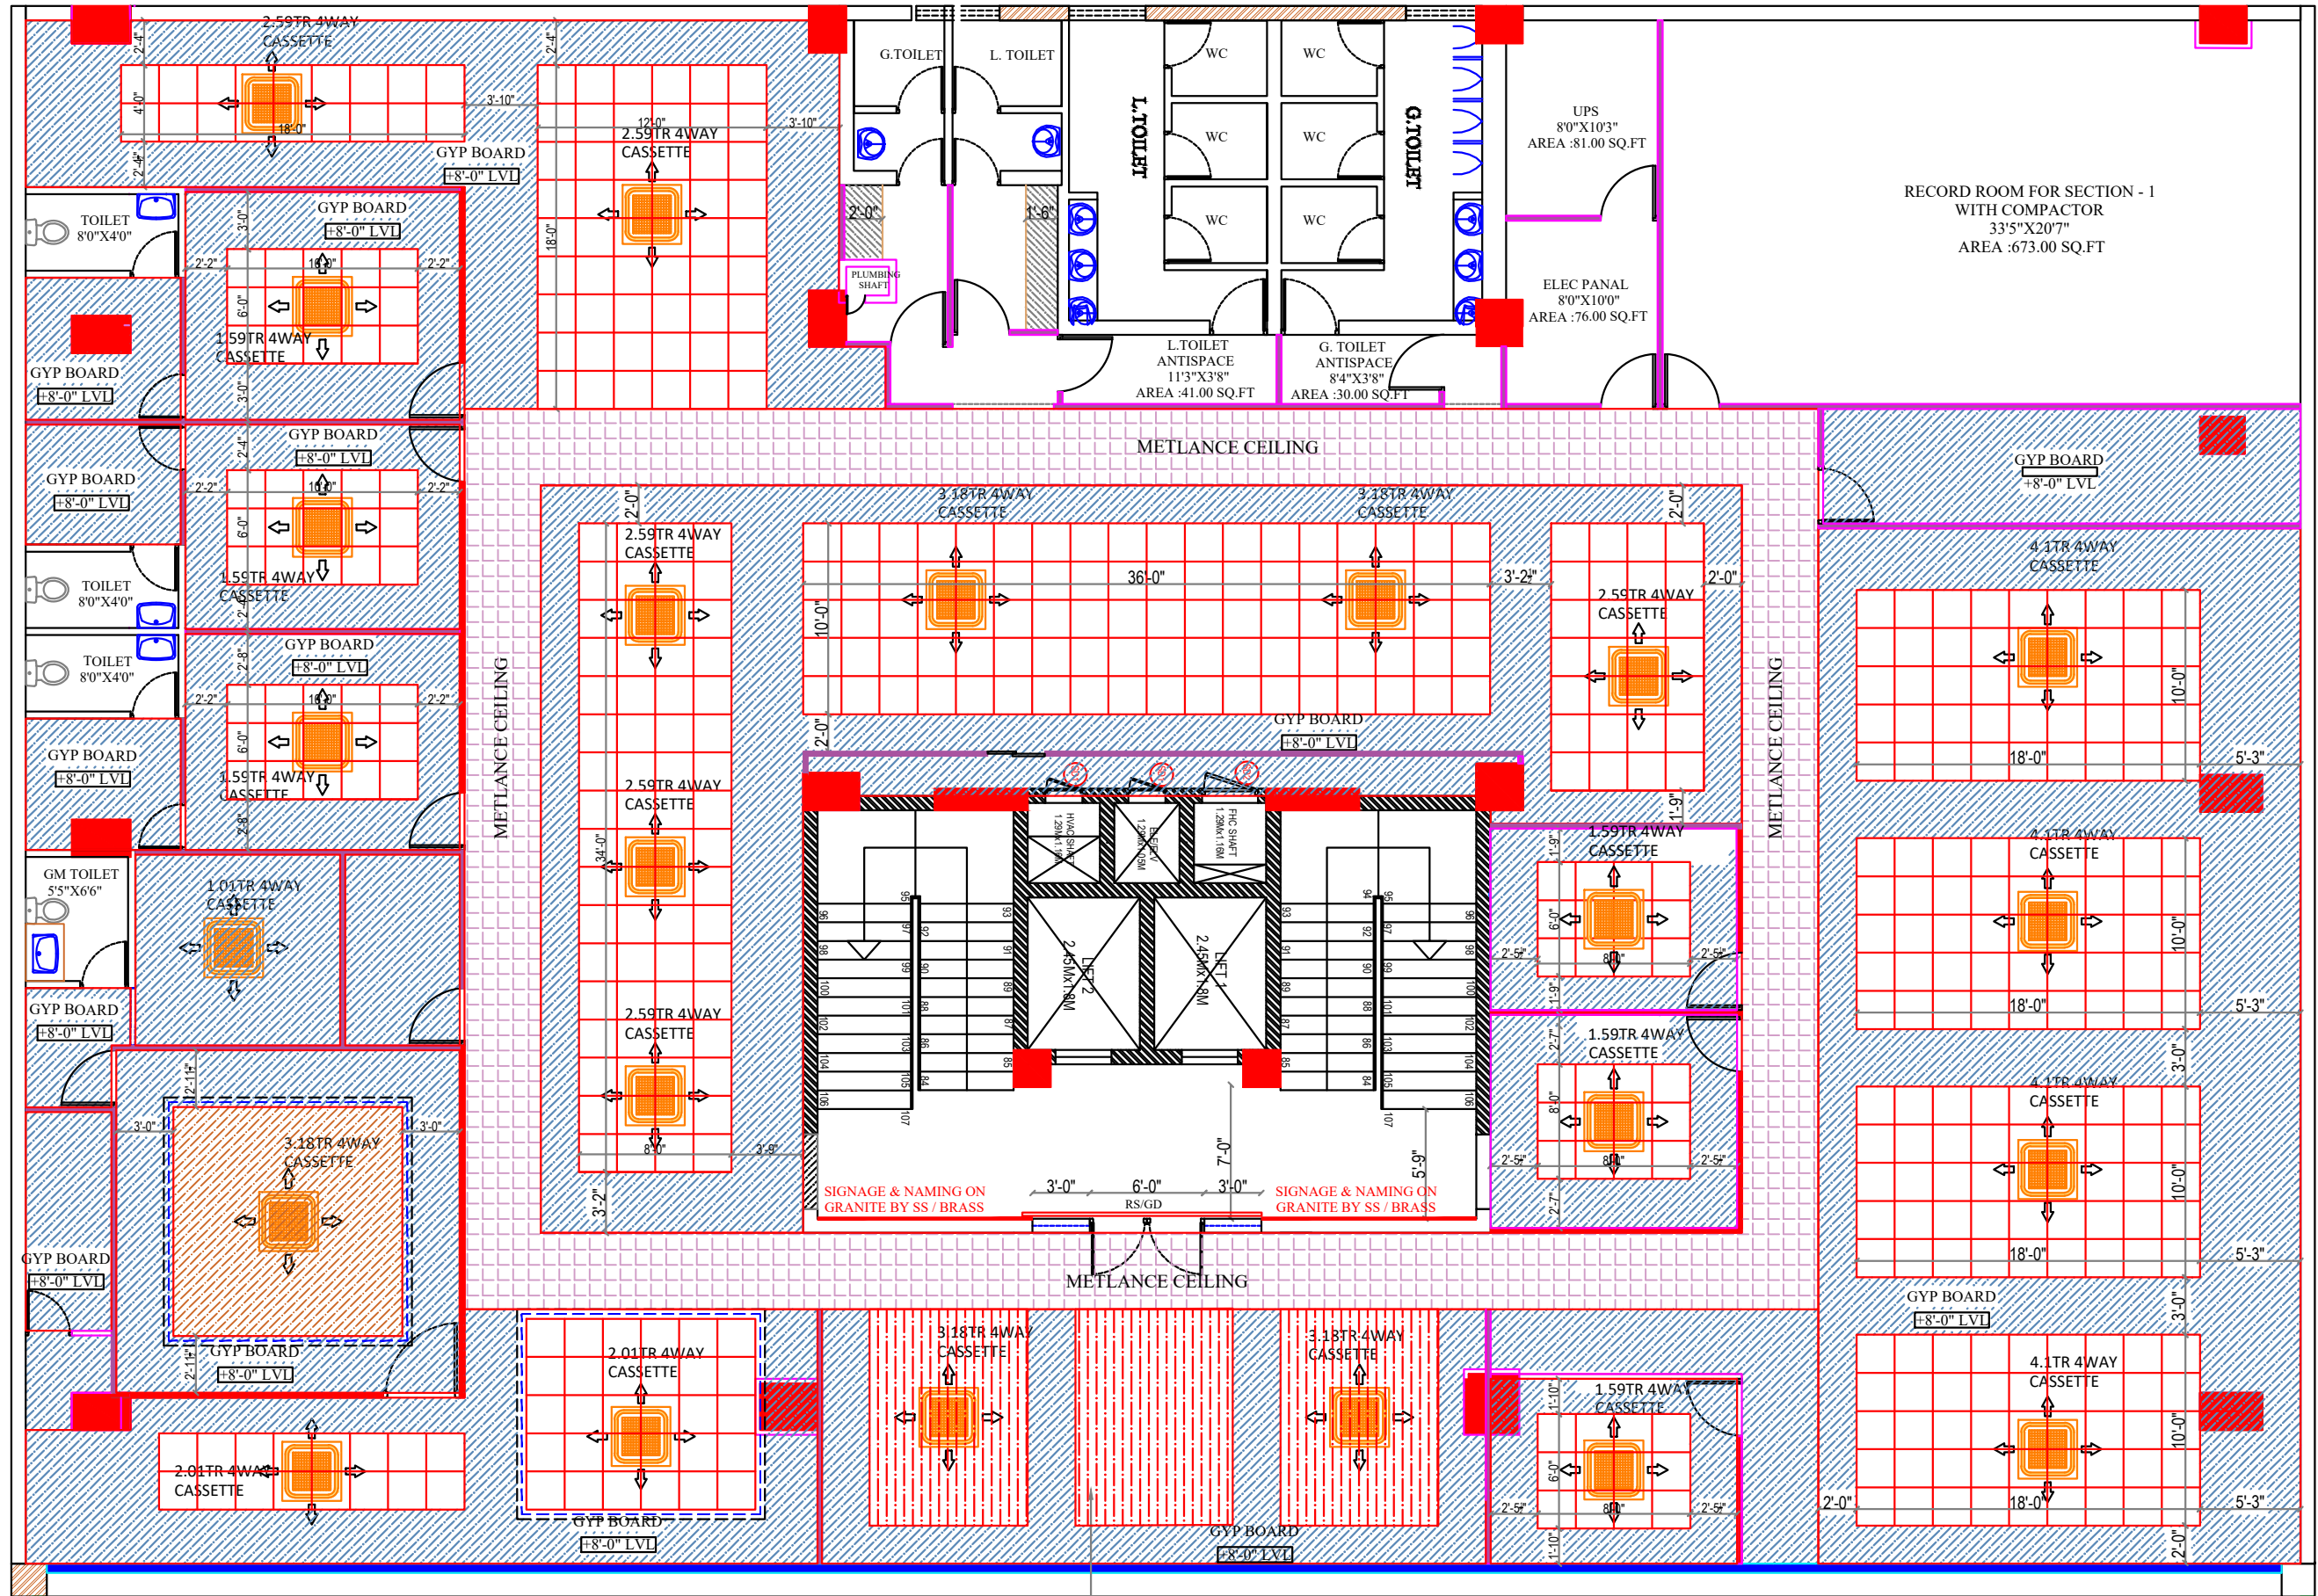

RECORD ROOM FOR SECTION - 1
WITH COMPACTOR
33'5"X20'7"
AREA : 673.00 SQ.FT

UPS
8'0"X10'3"
AREA : 81.00 SQ.FT

ELEC PANAL
8'0"X10'0"
AREA : 76.00 SQ.FT

METLANCE CEILING

METLANCE CEILING


STRETCH CEILING WITH
BACK LED LIGHT

- LOW HEIGHT PARTITION
- FULL GLAZED PARTITION
- FULL HEIGHT SOLID PARTITION

GM	- 1
DGM	- 3
DM	- 5
AGM	- 2
SM	- 12
MGR	- 6
OFFICER	- 52

CARPET AREA
SECOND FLOOR - 7845.10SQ.FT
THIRD FLOOR - 8129.10 SQ.FT
TOTAL AREA - 15974.20 SQ.FT
(EXCLUDED TOILET & STAIRCASE)

JOB NO 1739	PROJECT TITLE : PROPOSED INTERIOR DESIGN FOR CANARA BANK CIRCLE OFFICE SAMBAKULAM ROAD, MADURAI.	DRAWING TITLE :	THIRD FLOOR - AC LAYOUT	DESIGN STAGE	SCHEME LEVEL	SCALE	N.T.S	REV NO	REV - 18	ORIENTATION	ARCHITECTS T.S.O DESIGN COMMUNE PVT. LTD. Architects ■ Planners ■ Interior designers
		DRAWING TYPE :	WORKING DRAWING		FINAL COPY	DATE	29-04-2025	DRN	K.D		
						R.DATE	03.10.2025	CHKD	K.S		

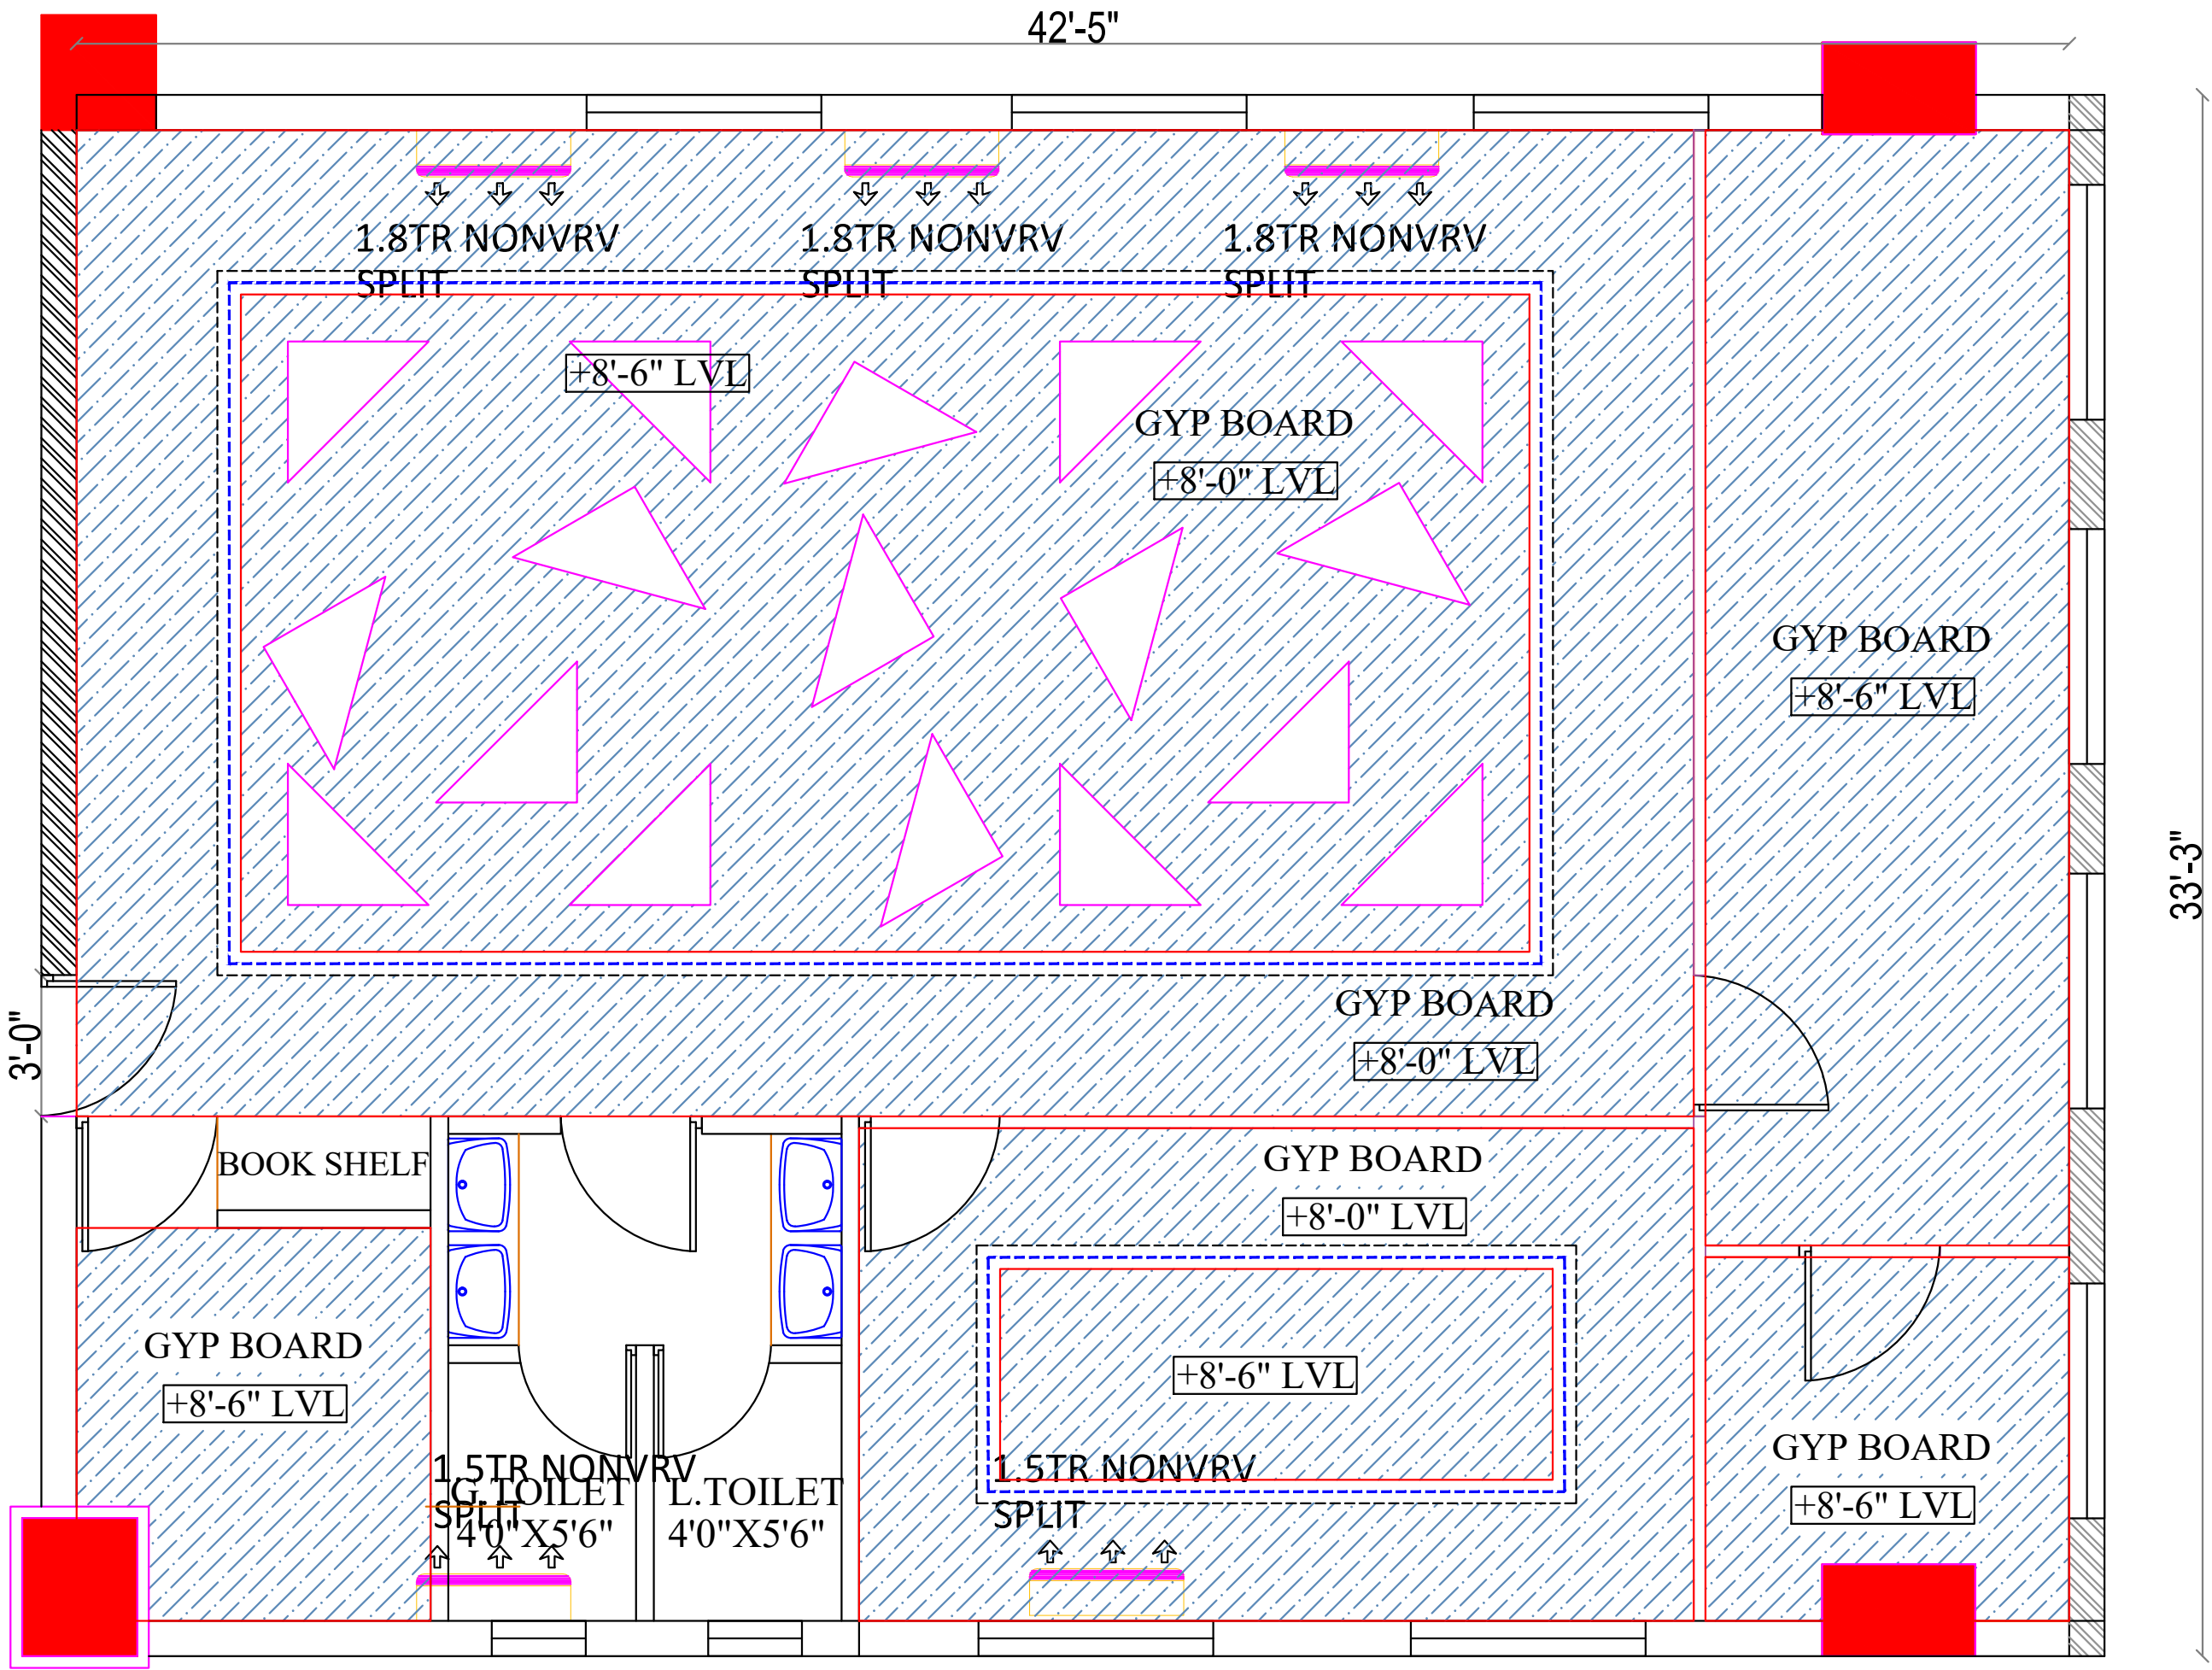

3'-0"

42'-5"

33'-3"

1.8TR NONVRV

1.8TR NONVRV

1.8TR NONVRV

SPLIT

SPLIT

SPLIT

+8'-6" LVL

GYP BOARD

+8'-0" LVL

GYP BOARD

+8'-6" LVL

GYP BOARD

+8'-0" LVL

BOOK SHELF

GYP BOARD

+8'-0" LVL

GYP BOARD

+8'-6" LVL

1.5TR NONVRV

SPLIT

4'0" X 5'6"

L. TOILET

4'0" X 5'6"

1.5TR NONVRV

SPLIT

+8'-6" LVL

GYP BOARD

+8'-6" LVL

JOB NO	PROJECT TITLE :	PROPOSED INTERIOR DESIGN FOR	DRAWING TITLE :	DESIGN STAGE	SCALE	N.T.S	REV NO	TERR.F-18	ORIENTATION	ARCHITECTS
1739	CANARA BANK CIRCLE OFFICE SAMBAKULAM ROAD, MADURAI.	TERRACE FLOOR DINING LAYOUT	WORKING DRAWING	Confidential SCHEME LEVEL	DATE	29-04-2025	DRN	K.D	N	
				FINAL COPY	R.DATE	03.10.2025	CHKD	K.S		

TSO DESIGN COMMUNE PVT. LTD.
Architects ■ Planners ■ Interior designers
NEW NO.16,(OLD NO.42), Ground floor, South West Boag Road,
T.Nagar, Chennai - 600017. Ph : 044 - 4212 9252
Telefax : 044 - 2435 0493 E-mail : info@tsodc.com

25'-6"

8'-0"

GYP BOARD

+8'-0" LVL

0.8TR NONVRV
SPLIT

GYP BOARD

+8'-0" LVL

0.8TR NONVRV
SPLIT

GYP BOARD

+8'-0" LVL

UP

 
8'-0"

3'-6"

6'-3"

Confidential

ARCHITECTS



TSO DESIGN COMMUNE PVT. LTD.
Architects • Planners • Interior designers
NEW NO.16, OLD NO.421, Ground floor, South West Bang Road,
Bangalore, Karnataka 560025.
Phone: 044-245 9495 E-mail: info@tsocorp.com

ORIENTATION



TERR.F-04

M.G
K.S

REV/NO

DRN
CHKD

N.T.S

29-04-2025
03.10.2025

SCALE

DATE
R.DATE

DESIGN STAGE

SCHEME LEVEL
FINAL COPY

ATM

SCHEMATIC DRAWING

DRAWING TITLE :

ATM

DRAWING TYPE :

SCHEMATIC DRAWING

PROPOSED INTERIOR DESIGN FOR

CANARA BANK CIRCLE OFFICE
SAMBAKULAM ROAD, MADURAI.

PROJECT TITLE :

1739

JOB NO

1739




LEGEND	
	2 Nos.6A UPS Power Socket Outlet
	2 Nos.6A RAW Power Socket Outlet
	1 Nos.6A Raw Power Socket Outlet
	Modular Type 25/32A A/C Socket
	6/16ARaw Power Socket Outlet
	Data Socket
	Telephone Outlet
	6A AC Power Socket @CEILING LVL.
	Distribution Board

JOB NO 1739	PROJECT TITLE : PROPOSED INTERIOR DESIGN FOR CANARA BANK CIRCLE OFFICE SAMBAKULAM ROAD, MADURAI.	DRAWING TITLE :	POWER LAYOUT - SECOND FLOOR	DESIGN STAGE	SCALE	N.T.S	REV NO	REV - 04	ORIENTATION	ARCHITECTS TSO DESIGN COMMUNE PVT. LTD. Architects ■ Planners ■ Interior designers NEW NO.16,(OLD NO.42), Ground floor, South West Boag Road, T.Nagar, Chennai - 600017. Ph : 044 - 4212 9252 Telefax : 044 - 2435 0490 E-mail : info@tsodc.com
		DRAWING TYPE :	WORKING DRAWING	Confidential SCHEME LEVEL	DATE	29-04-2025	DRN	HARI G		
				FINAL COPY	R.DATE	26.10.2025	CHKD	G.G		



LEGEND	
	2 Nos.6A UPS Power Socket Outlet
	2 Nos.6A RAW Power Socket Outlet
	1 Nos.6A Raw Power Socket Outlet
	Modular Type 25/32A A/C Socket
	6/16ARaw Power Socket Outlet
	Data Socket
	Telephone Outlet
	6A AC Power Socket @CEILING LVL.
	Distribution Board

JOB NO	PROJECT TITLE :	PROPOSED INTERIOR DESIGN FOR	DRAWING TITLE :	DESIGN STAGE	SCALE	N.T.S	REV NO	REV - 04	ORIENTATION	ARCHITECTS TSO DESIGN COMMUNE PVT. LTD. Architects ■ Planners ■ Interior designers NEW NO.16,(OLD NO.42), Ground floor, South West Boag Road, T.Nagar, Chennai - 600017. Ph : 044 - 4212 9252 Telefax : 044 - 2435 0493 E-mail : info@tsoc.com
1739		CANARA BANK CIRCLE OFFICE	POWER LAYOUT - THIRD FLOOR	Confidential SCHEME LEVEL	DATE	29-04-2025	DRN	HARI G		
		SAMBAKULAM ROAD, MADURAI.	DRAWING TYPE :	WORKING DRAWING	R.DATE	26.10.2025	CHKD	G.G		

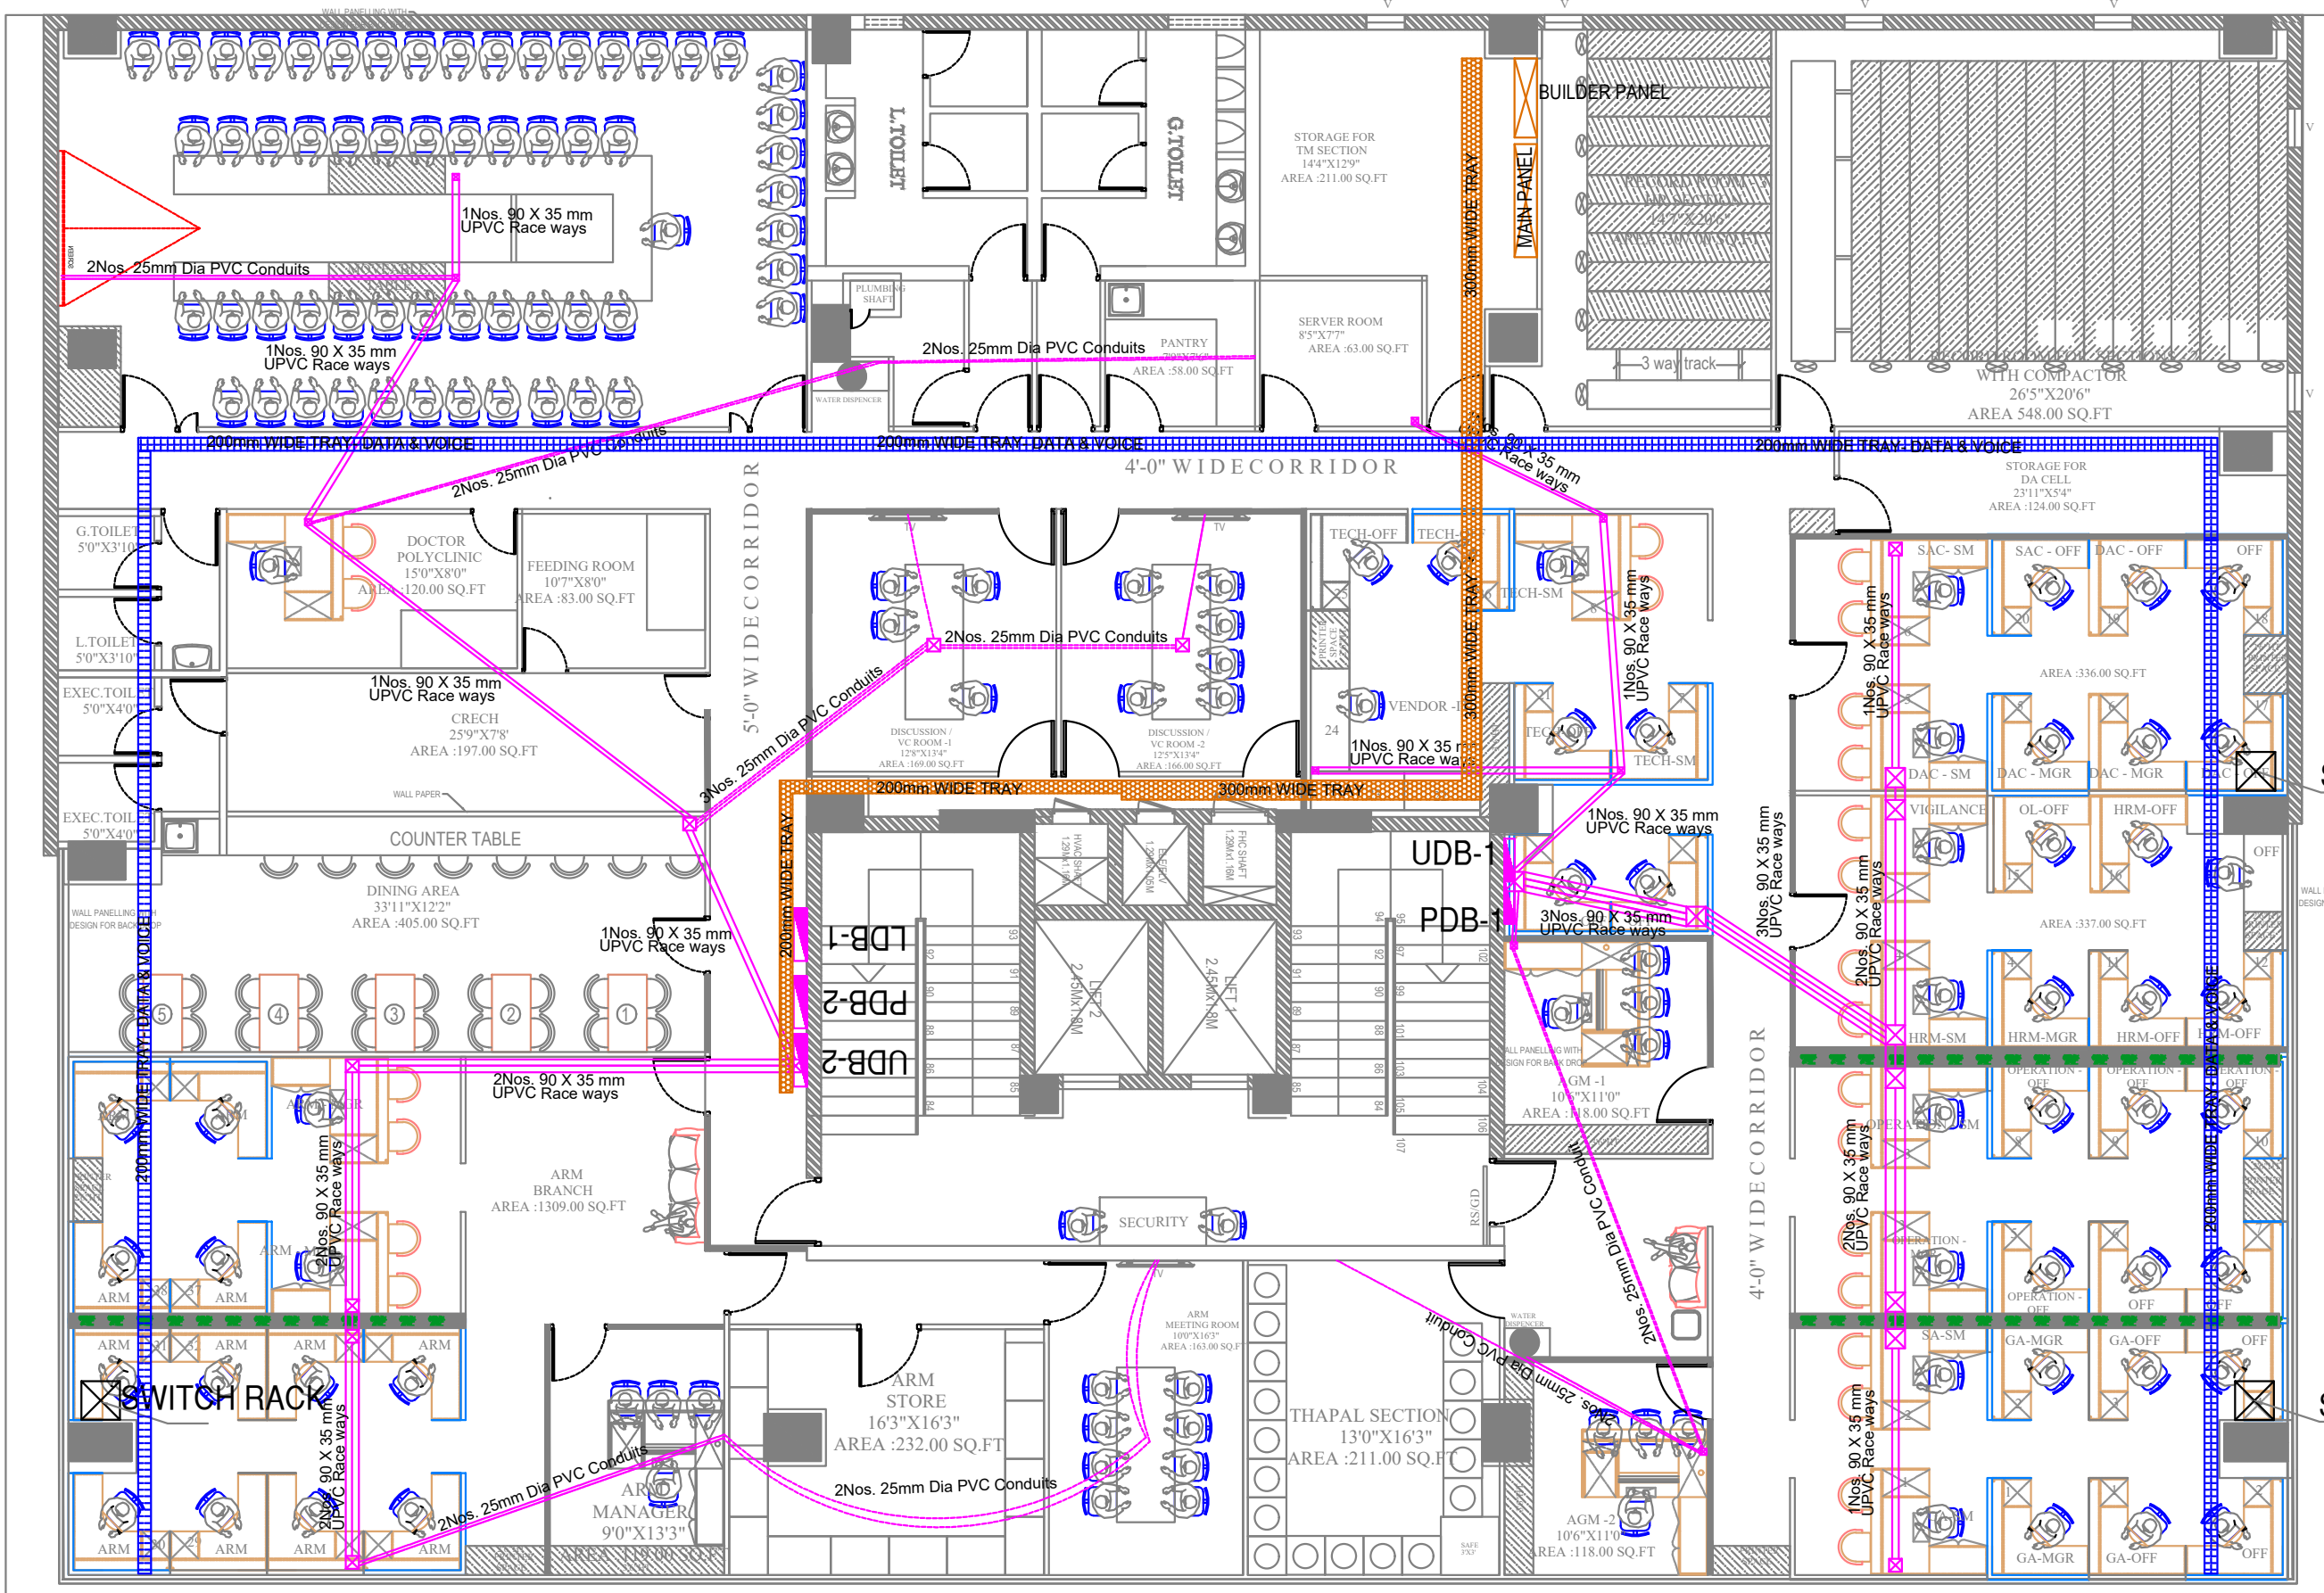


SWITCH RACK

SWITCH RACK


LEGEND	
	RAW & UPS POWER RACEWAYS
	FLOOR JUNCTION BOXES
	25MM DIA PVC CONDUITS
	POWER CABLE TRAY
	DATA & VOICE CABLE TRAY

JOB NO	PROJECT TITLE :	PROPOSED INTERIOR DESIGN FOR	DRAWING TITLE :	FLOOR RACEWAYS & CABLE TRAY LAYOUT	DESIGN STAGE	SCALE	N.T.S	REV NO	REV - 04	ORIENTATION	ARCHITECTS TSO DESIGN COMMUNE PVT. LTD. Architects ■ Planners ■ Interior designers NEW NO.16,(OLD NO.42), Ground floor, South West Boag Road, T.Nagar, Chennai - 600017. Ph : 044 - 4212 9252 Telefax : 044 - 2435 0490 E-mail : info@tdc.com
1739		CANARA BANK CIRCLE OFFICE		SECOND FLOOR	SCHEME LEVEL	DATE	29-04-2025	DRN	HARI G		
		SAMBAKULAM ROAD, MADURAI.	DRAWING TYPE :	WORKING DRAWING	FINAL COPY	R.DATE	26.10.2025	CHKD	G.G		

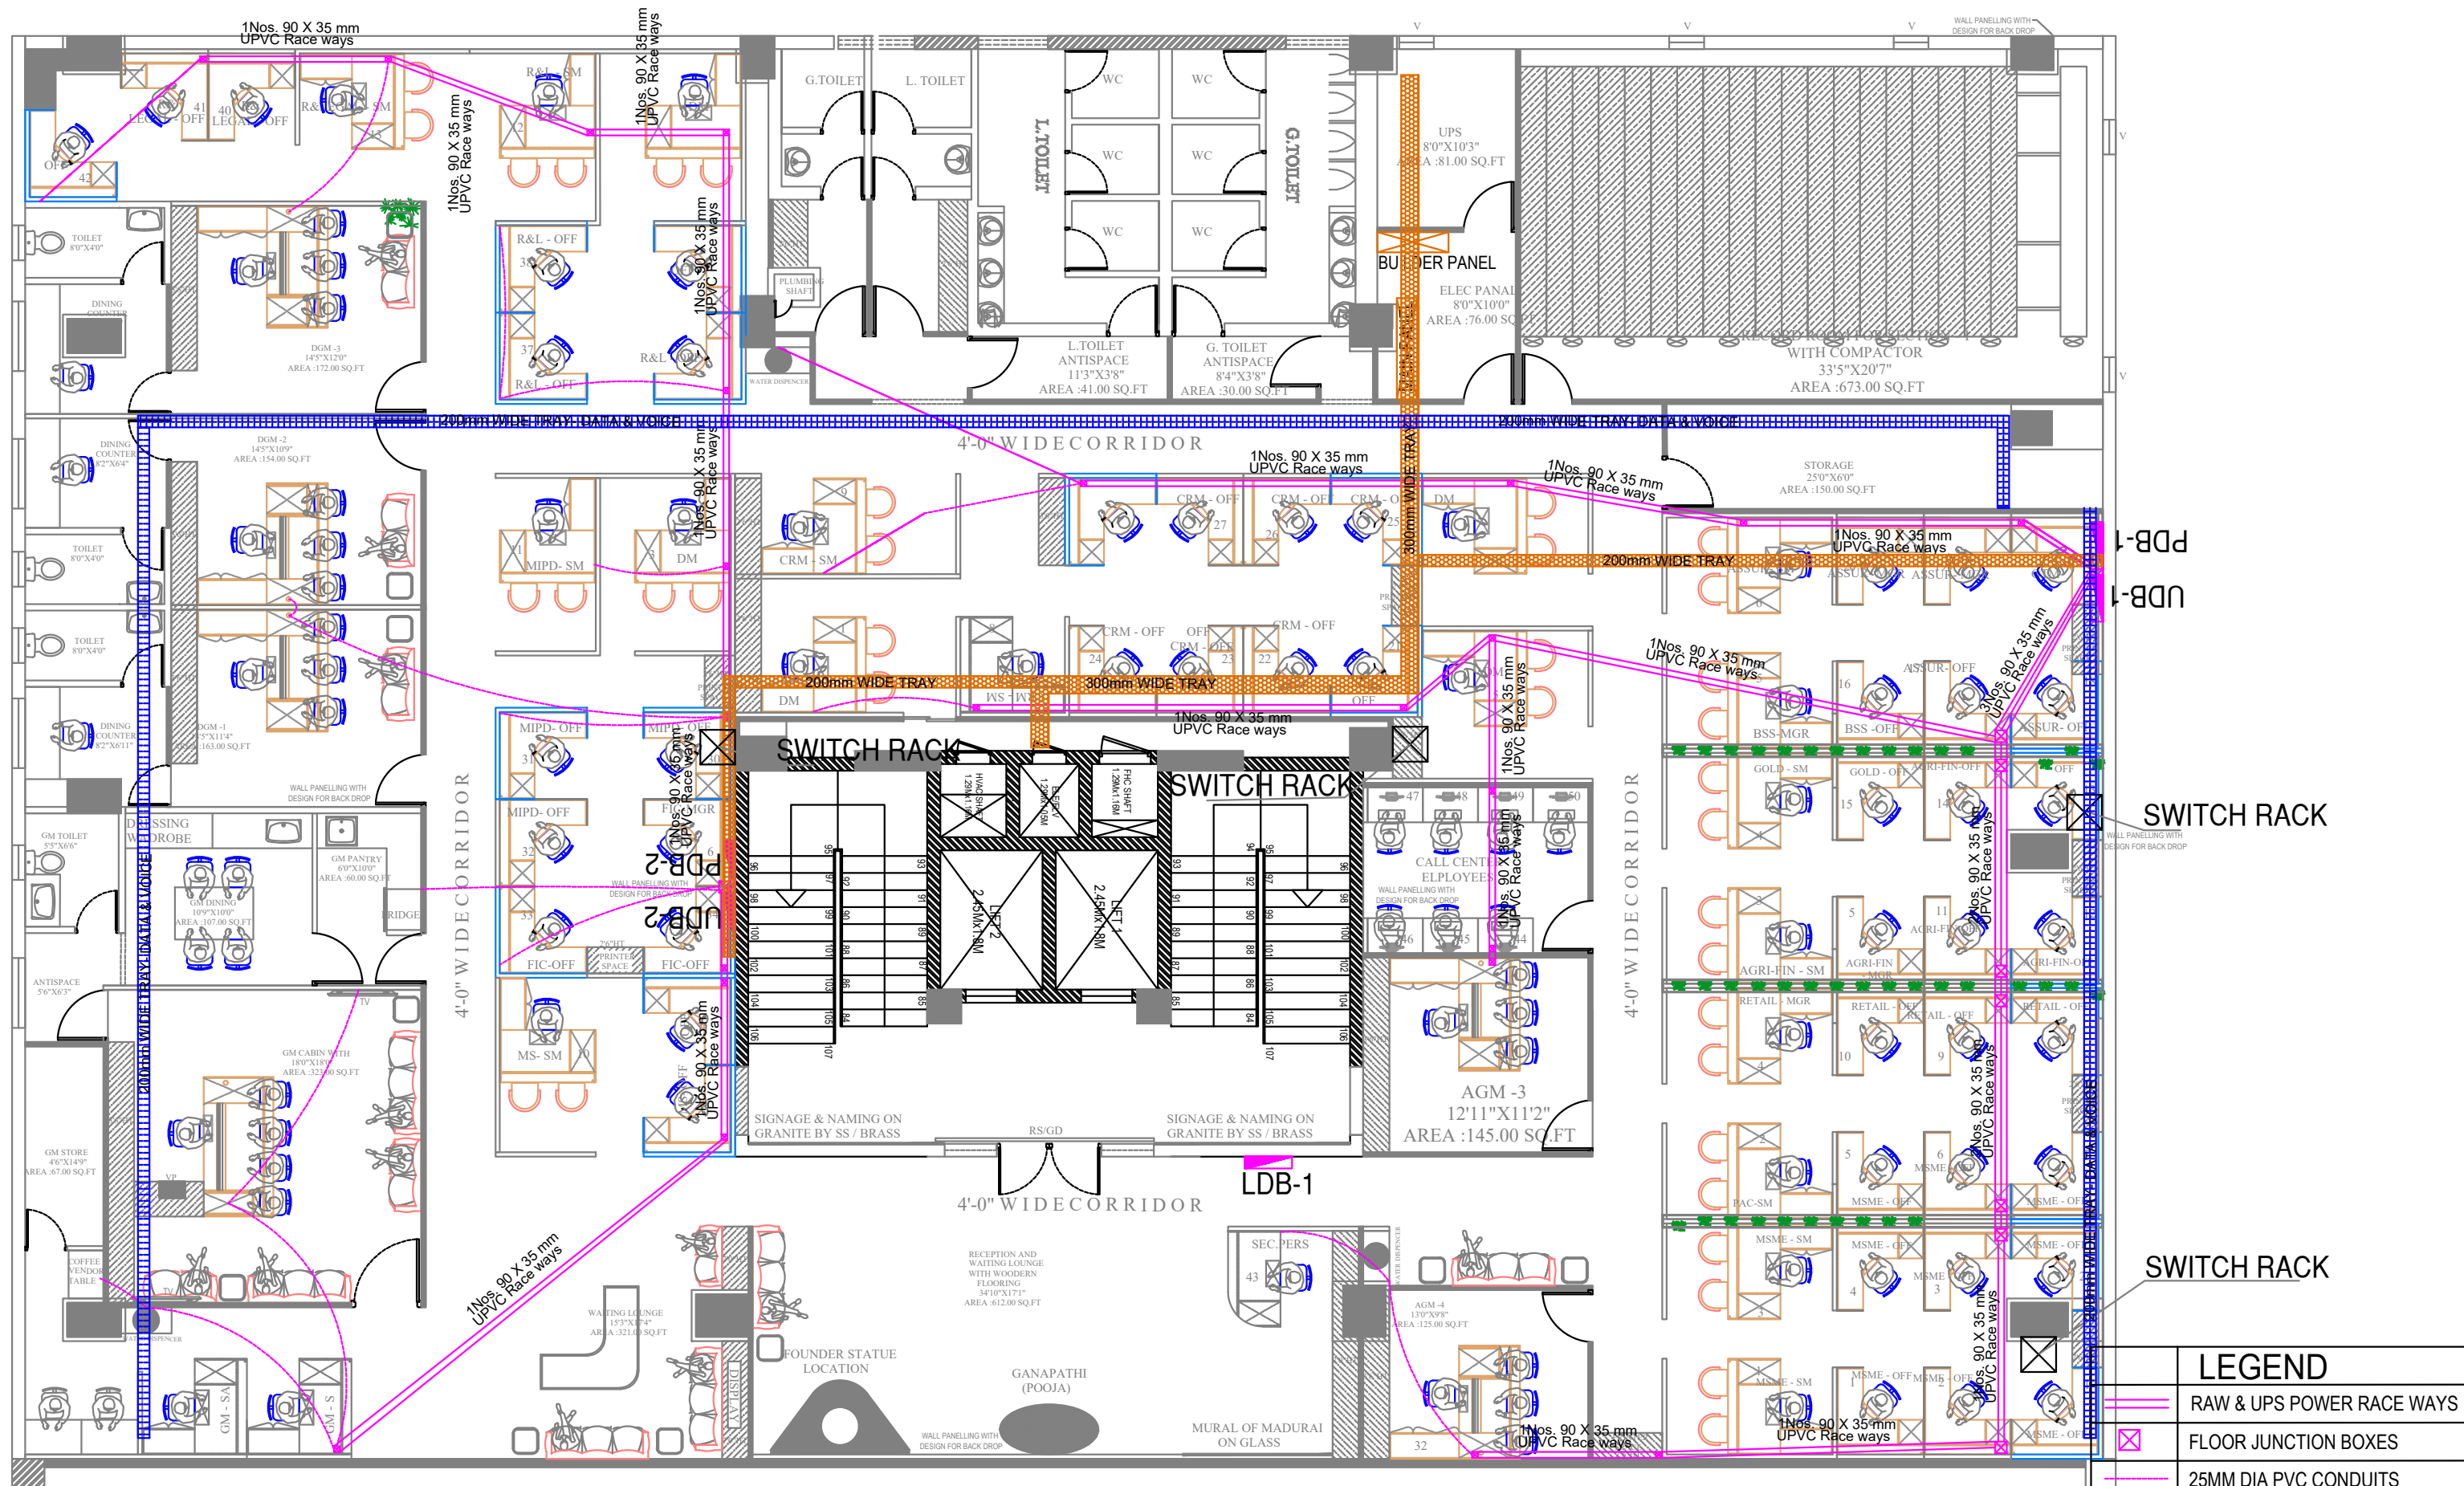

LEGEND	
	RAW & UPS POWER RACEWAYS
	FLOOR JUNCTION BOXES
	25MM DIA PVC CONDUITS
	POWER CABLE TRAY
	DATA & VOICE CABLE TRAY


JOB NO	PROJECT TITLE :	PROPOSED INTERIOR DESIGN FOR	DRAWING TITLE :	DESIGN STAGE	SCALE	N.T.S	REV NO	REV - 04	ORIENTATION	ARCHITECTS
1739	CANARA BANK CIRCLE OFFICE		FLOOR RACEWAYS & CABLE TRAY LAYOUT	Scheme Level	DATE	29-04-2025	DRN	HARI G		
	SAMBAKULAM ROAD, MADURAI.		THIRD FLOOR	Working Drawing	R.DATE	26.10.2025	CHKD	G.G		
<p style="text-align: center;">Confidential</p> <p style="text-align: right;">TSO DESIGN COMMUNE PVT. LTD. Architects ■ Planners ■ Interior designers</p> <p style="text-align: right; font-size: small;">NEW NO.16,(OLD NO.42), Ground floor, South West Boag Road, T.Nagar, Chennai - 600017. Ph : 044 - 4212 9252 Telefax : 044 - 2435 0493 E-mail : info@tsodc.com</p>										

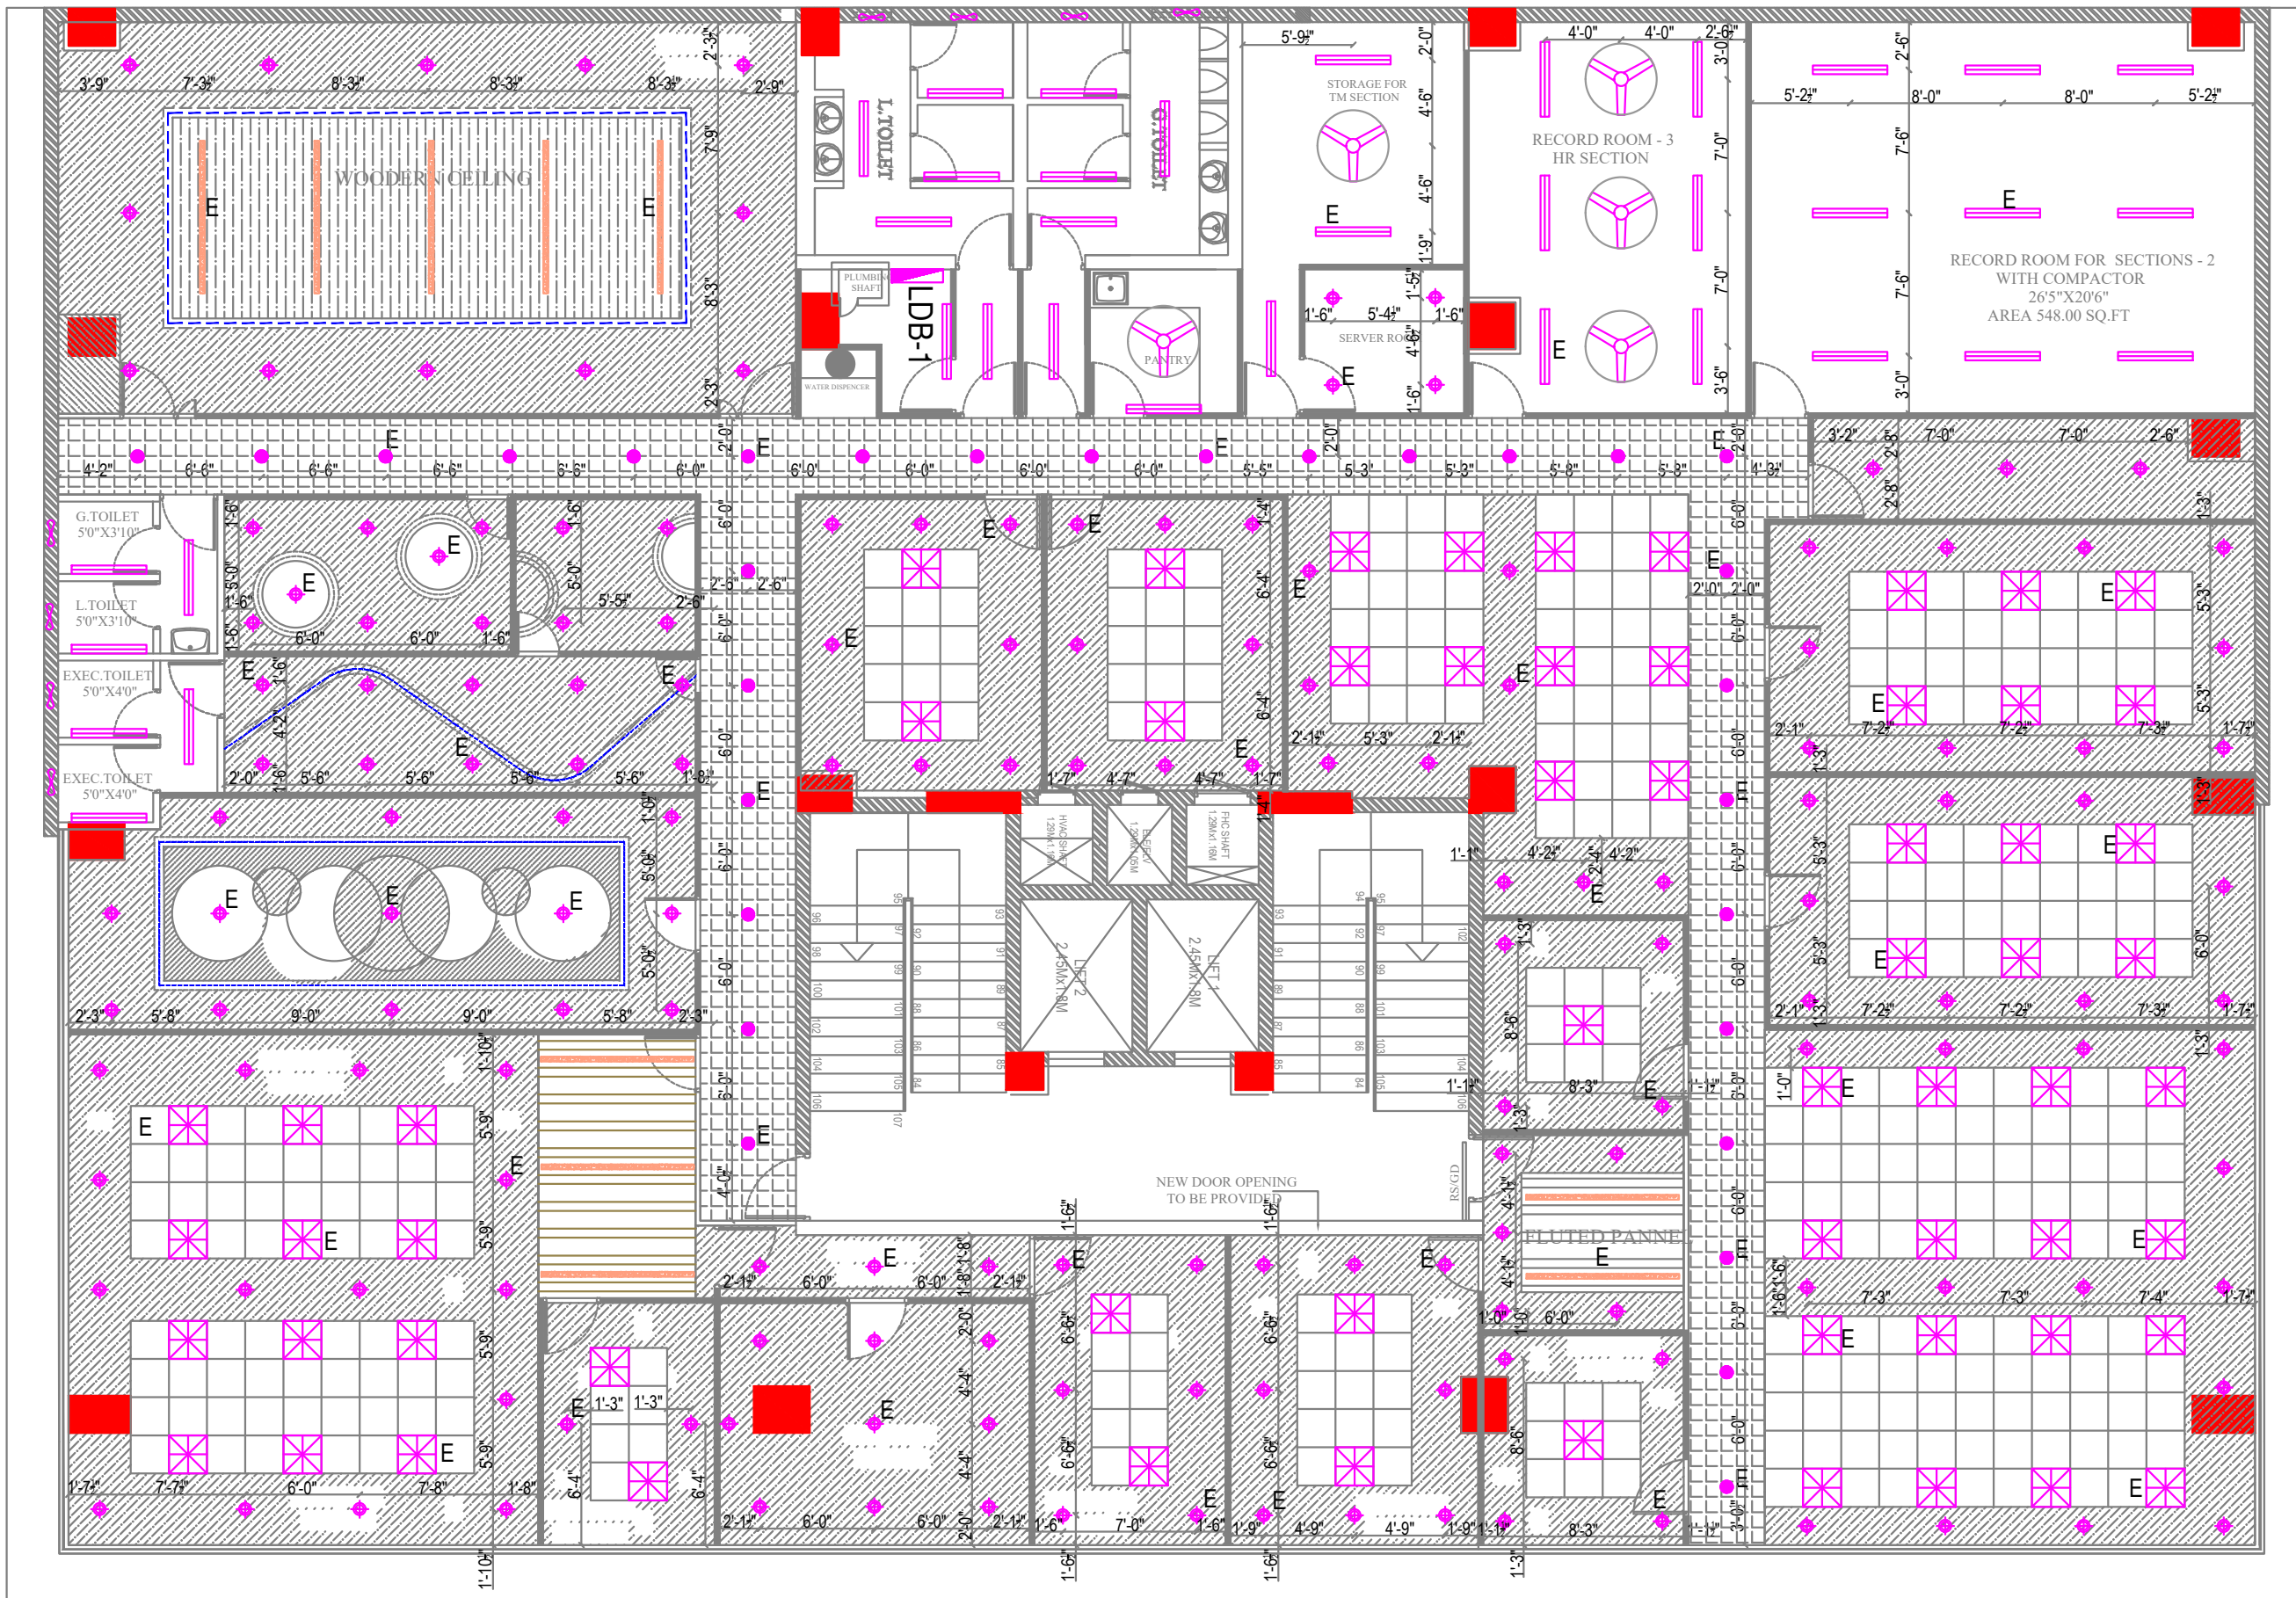

LEGEND

	2' X 2' - 36 W LED FITTING
	15 W LED DOWN LIGHT
	4' - 1 x 20 W LED BATTEN FITTING WITH BATTERY BACKUP
	WALL MOUNTING FAN
	CEILING FAN
	EXHAUST FAN
	EMERGENCY LIGHT
	STRIP LIGHT
	LINEAR SUSPENDED LIGHT
	SUSPENDED LIGHT - 20W


JOB NO 1739	PROJECT TITLE : PROPOSED INTERIOR DESIGN FOR CANARA BANK CIRCLE OFFICE SAMBAKULAM ROAD, MADURAI.	LIGHTING LAYOUT - SECOND FLOOR	DESIGN STAGE Confidential SCHEME LEVEL	SCALE N.T.S	REV NO 03	ORIENTATION 	ARCHITECTS TSO DESIGN COMMUNE PVT. LTD. Architects ■ Planners ■ Interior designers <small>NEW NO.16,(OLD NO.42), Ground floor, South West Boag Road, T.Nagar, Chennai - 600017. Ph : 044 - 4212 9252 Telefax : 044 - 2435 0493 E-mail : info@tdc.com</small>
		SCHEMATIC DRAWING	FINAL COPY	DATE 29-04-2025	DRN HARI G	CHKD G.G	

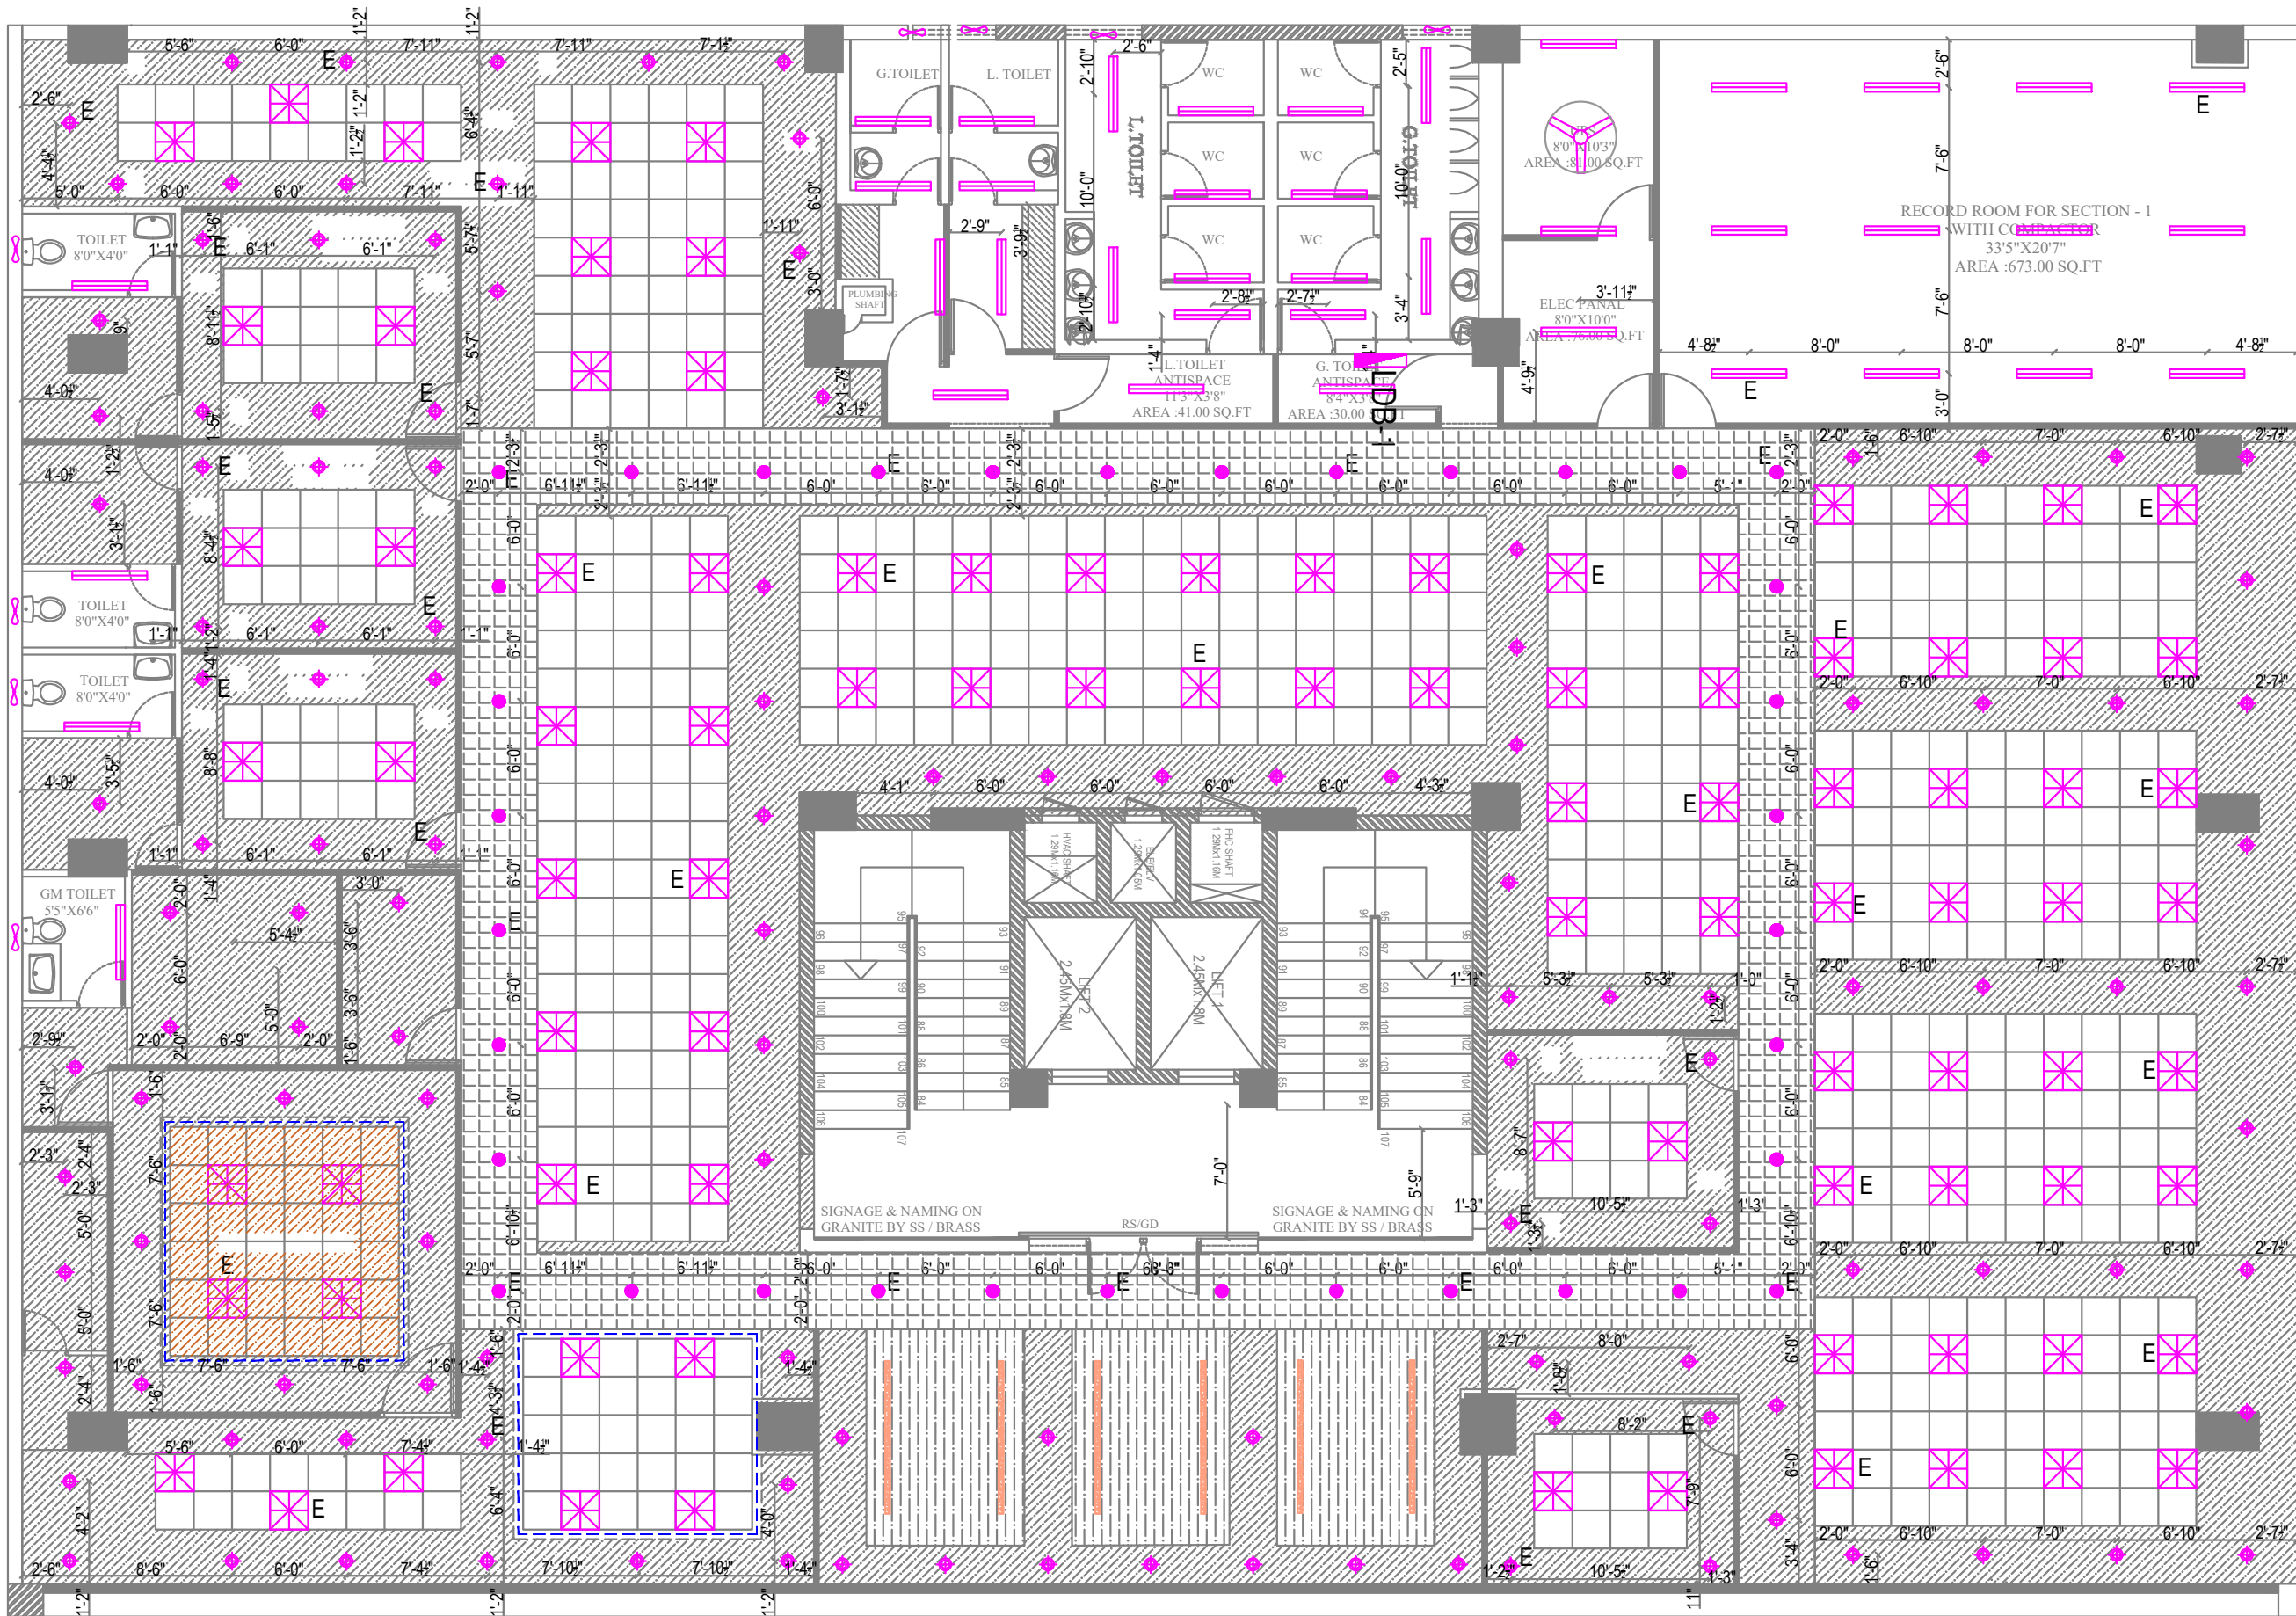

LEGEND

	2' X 2' - 36 W LED FITTING
	15 W LED DOWN LIGHT
	4' - 1 x 20 W LED BATTEN FITTING WITH BATTERY BACKUP
	WALL MOUNTING FAN
	CEILING FAN
	EXHAUST FAN
	EMERGENCY LIGHT
	STRIP LIGHT
	LINEAR SUSPENDED LIGHT
	SUSPENDED LIGHT - 20W


JOB NO	PROJECT TITLE :	PROPOSED INTERIOR DESIGN FOR	DRAWING TITLE :	DESIGN STAGE	SCALE	N.T.S	REV NO	03	ORIENTATION	ARCHITECTS
1739	CANARA BANK CIRCLE OFFICE SAMBAKULAM ROAD, MADURAI.		LIGHTING LAYOUT - THIRD FLOOR	Scheme Level	DATE	29-04-2025	DRN	HARI G		
			DRAWING TYPE :	Schematic Drawing	Final Copy	R.DATE	27.09.2025	CHKD		
<p>TSO DESIGN COMMUNE PVT. LTD. Architects ■ Planners ■ Interior designers</p> <p>NEW NO.16,(OLD NO.42), Ground floor, South West Boag Road, T.Nagar, Chennai - 600017. Ph : 044 - 4212 9252 Telefax : 044 - 2435 0493 E-mail : info@tsoc.com</p>										

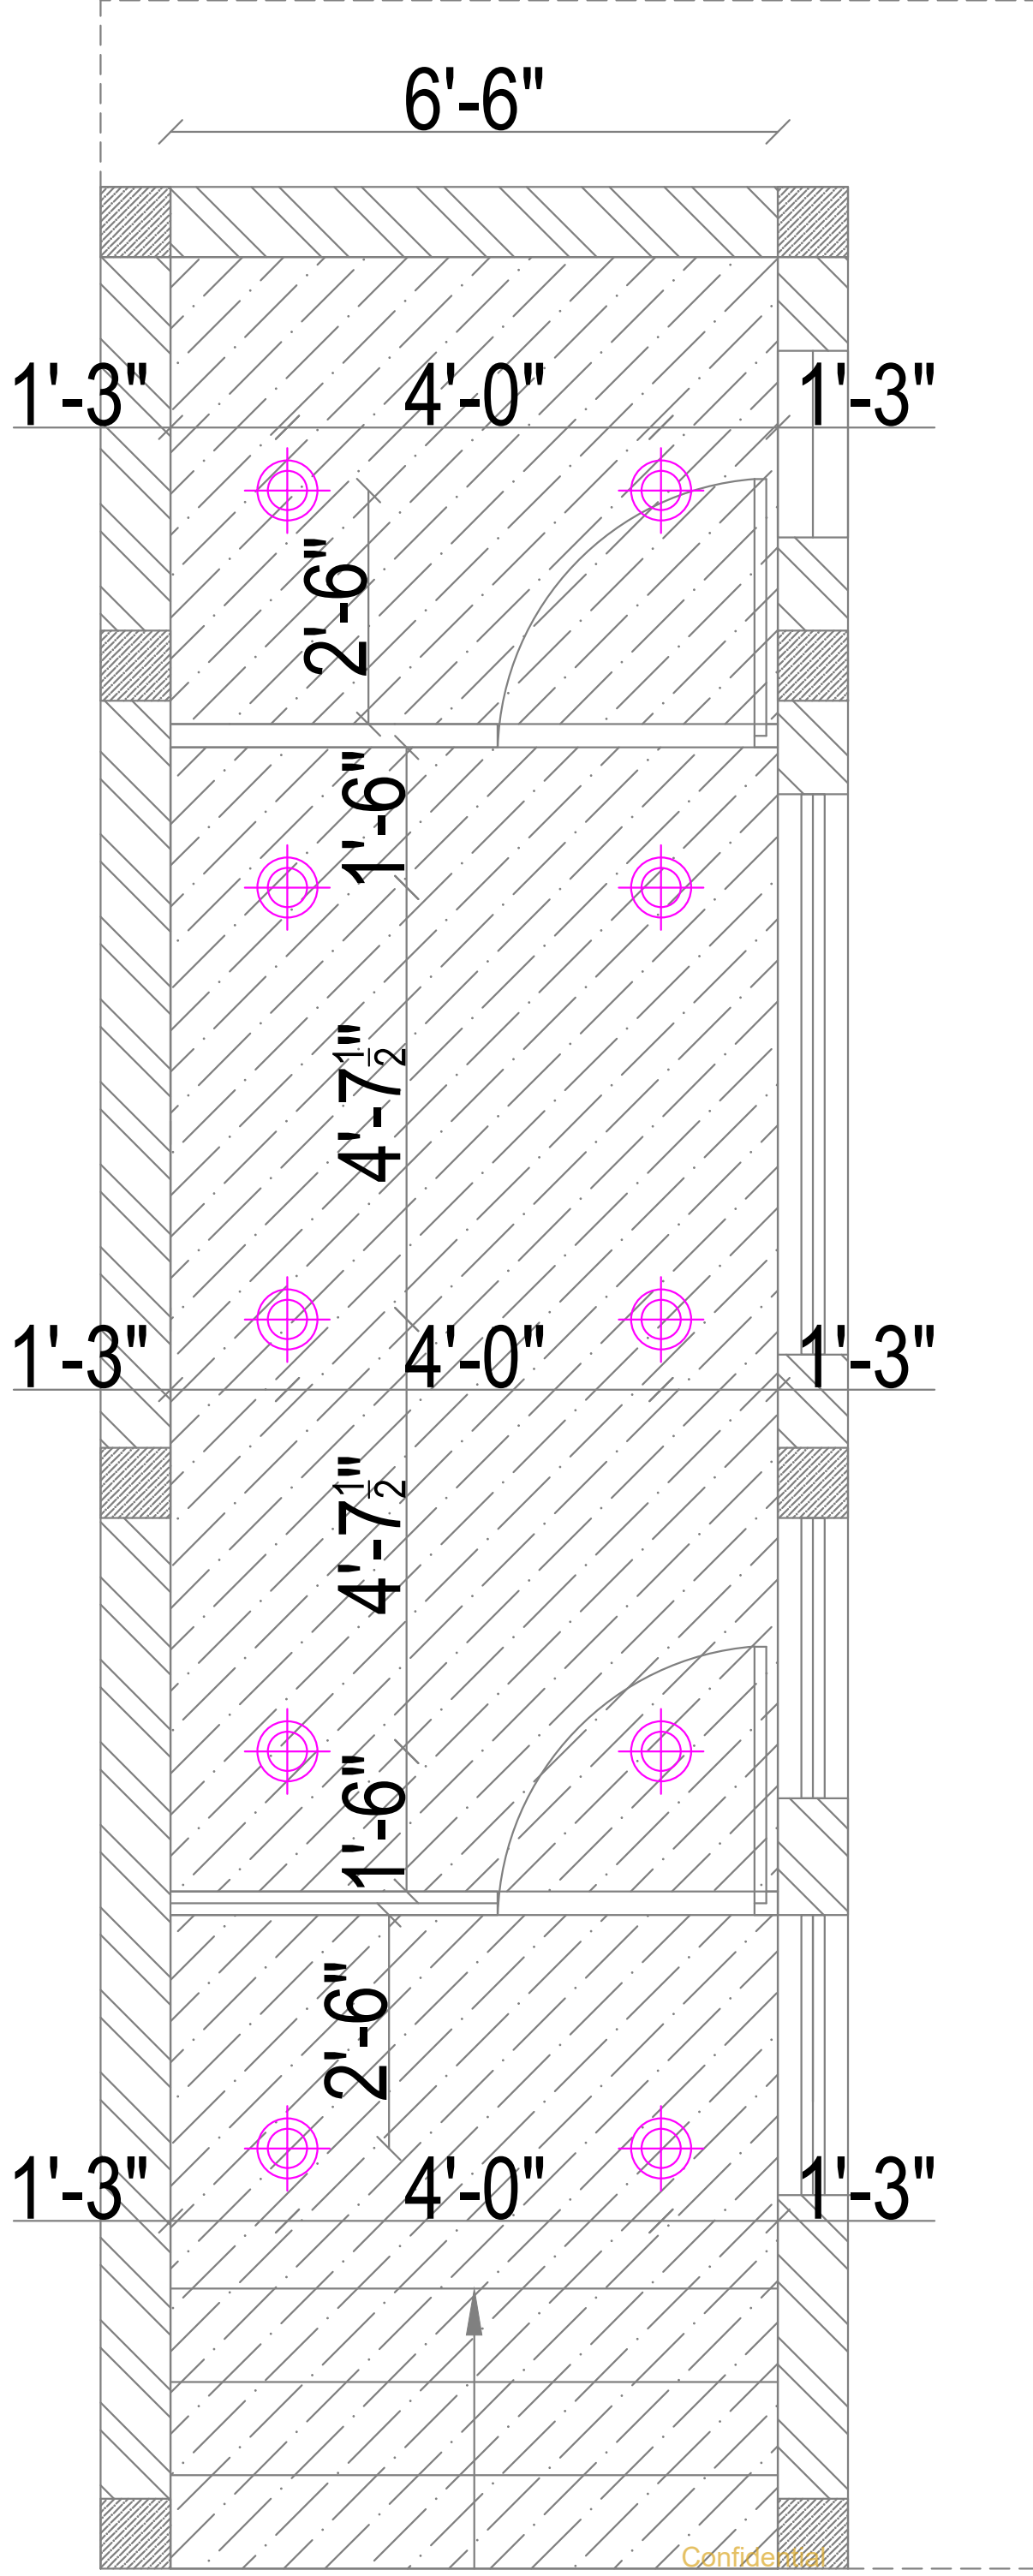

Confidential


LEGEND	
	15 W LED DOWN LIGHT
	4' - 1 x 20 W LED BATTEN FITTING WITH BATTERY BACKUP
	CEILING FAN
	EXHAUST FAN
	STRIP LIGHT

JOB NO 1739	PROJECT TITLE : CANARA BANK CIRCLE OFFICE SAMBAKULAM ROAD, MADURAI.		PROPOSED INTERIOR DESIGN FOR	DRAWING TITLE : LIGHTING LAYOUT - ATM		DRAWING TYPE : SCHEMATIC DRAWING		DESIGN STAGE SCHEME LEVEL FINAL COPY	SCALE DATE R.DATE	N.T.S 29-04-2025 27.09.2025	REV/NO DRN CHKD	01 HARI G G.G	ORIENTATION 	ARCHITECTS 	TSO DESIGN COMMUNE PVT. LTD. Architects • Planners • Interior designers NEW NO.16, GILD NO.421, Ground floor, South West Bang Road, Angkor, Coimbatore, Tamil Nadu, India - 641 012, 642 002. Tel: 042-2435 9493 E-mail: info@tsodesign.com
	DATE	R.DATE	CHKD	G.G	DATE	R.DATE	CHKD	G.G	DATE	R.DATE	CHKD	G.G	ORIENTATION	ARCHITECTS	ARCHITECTS

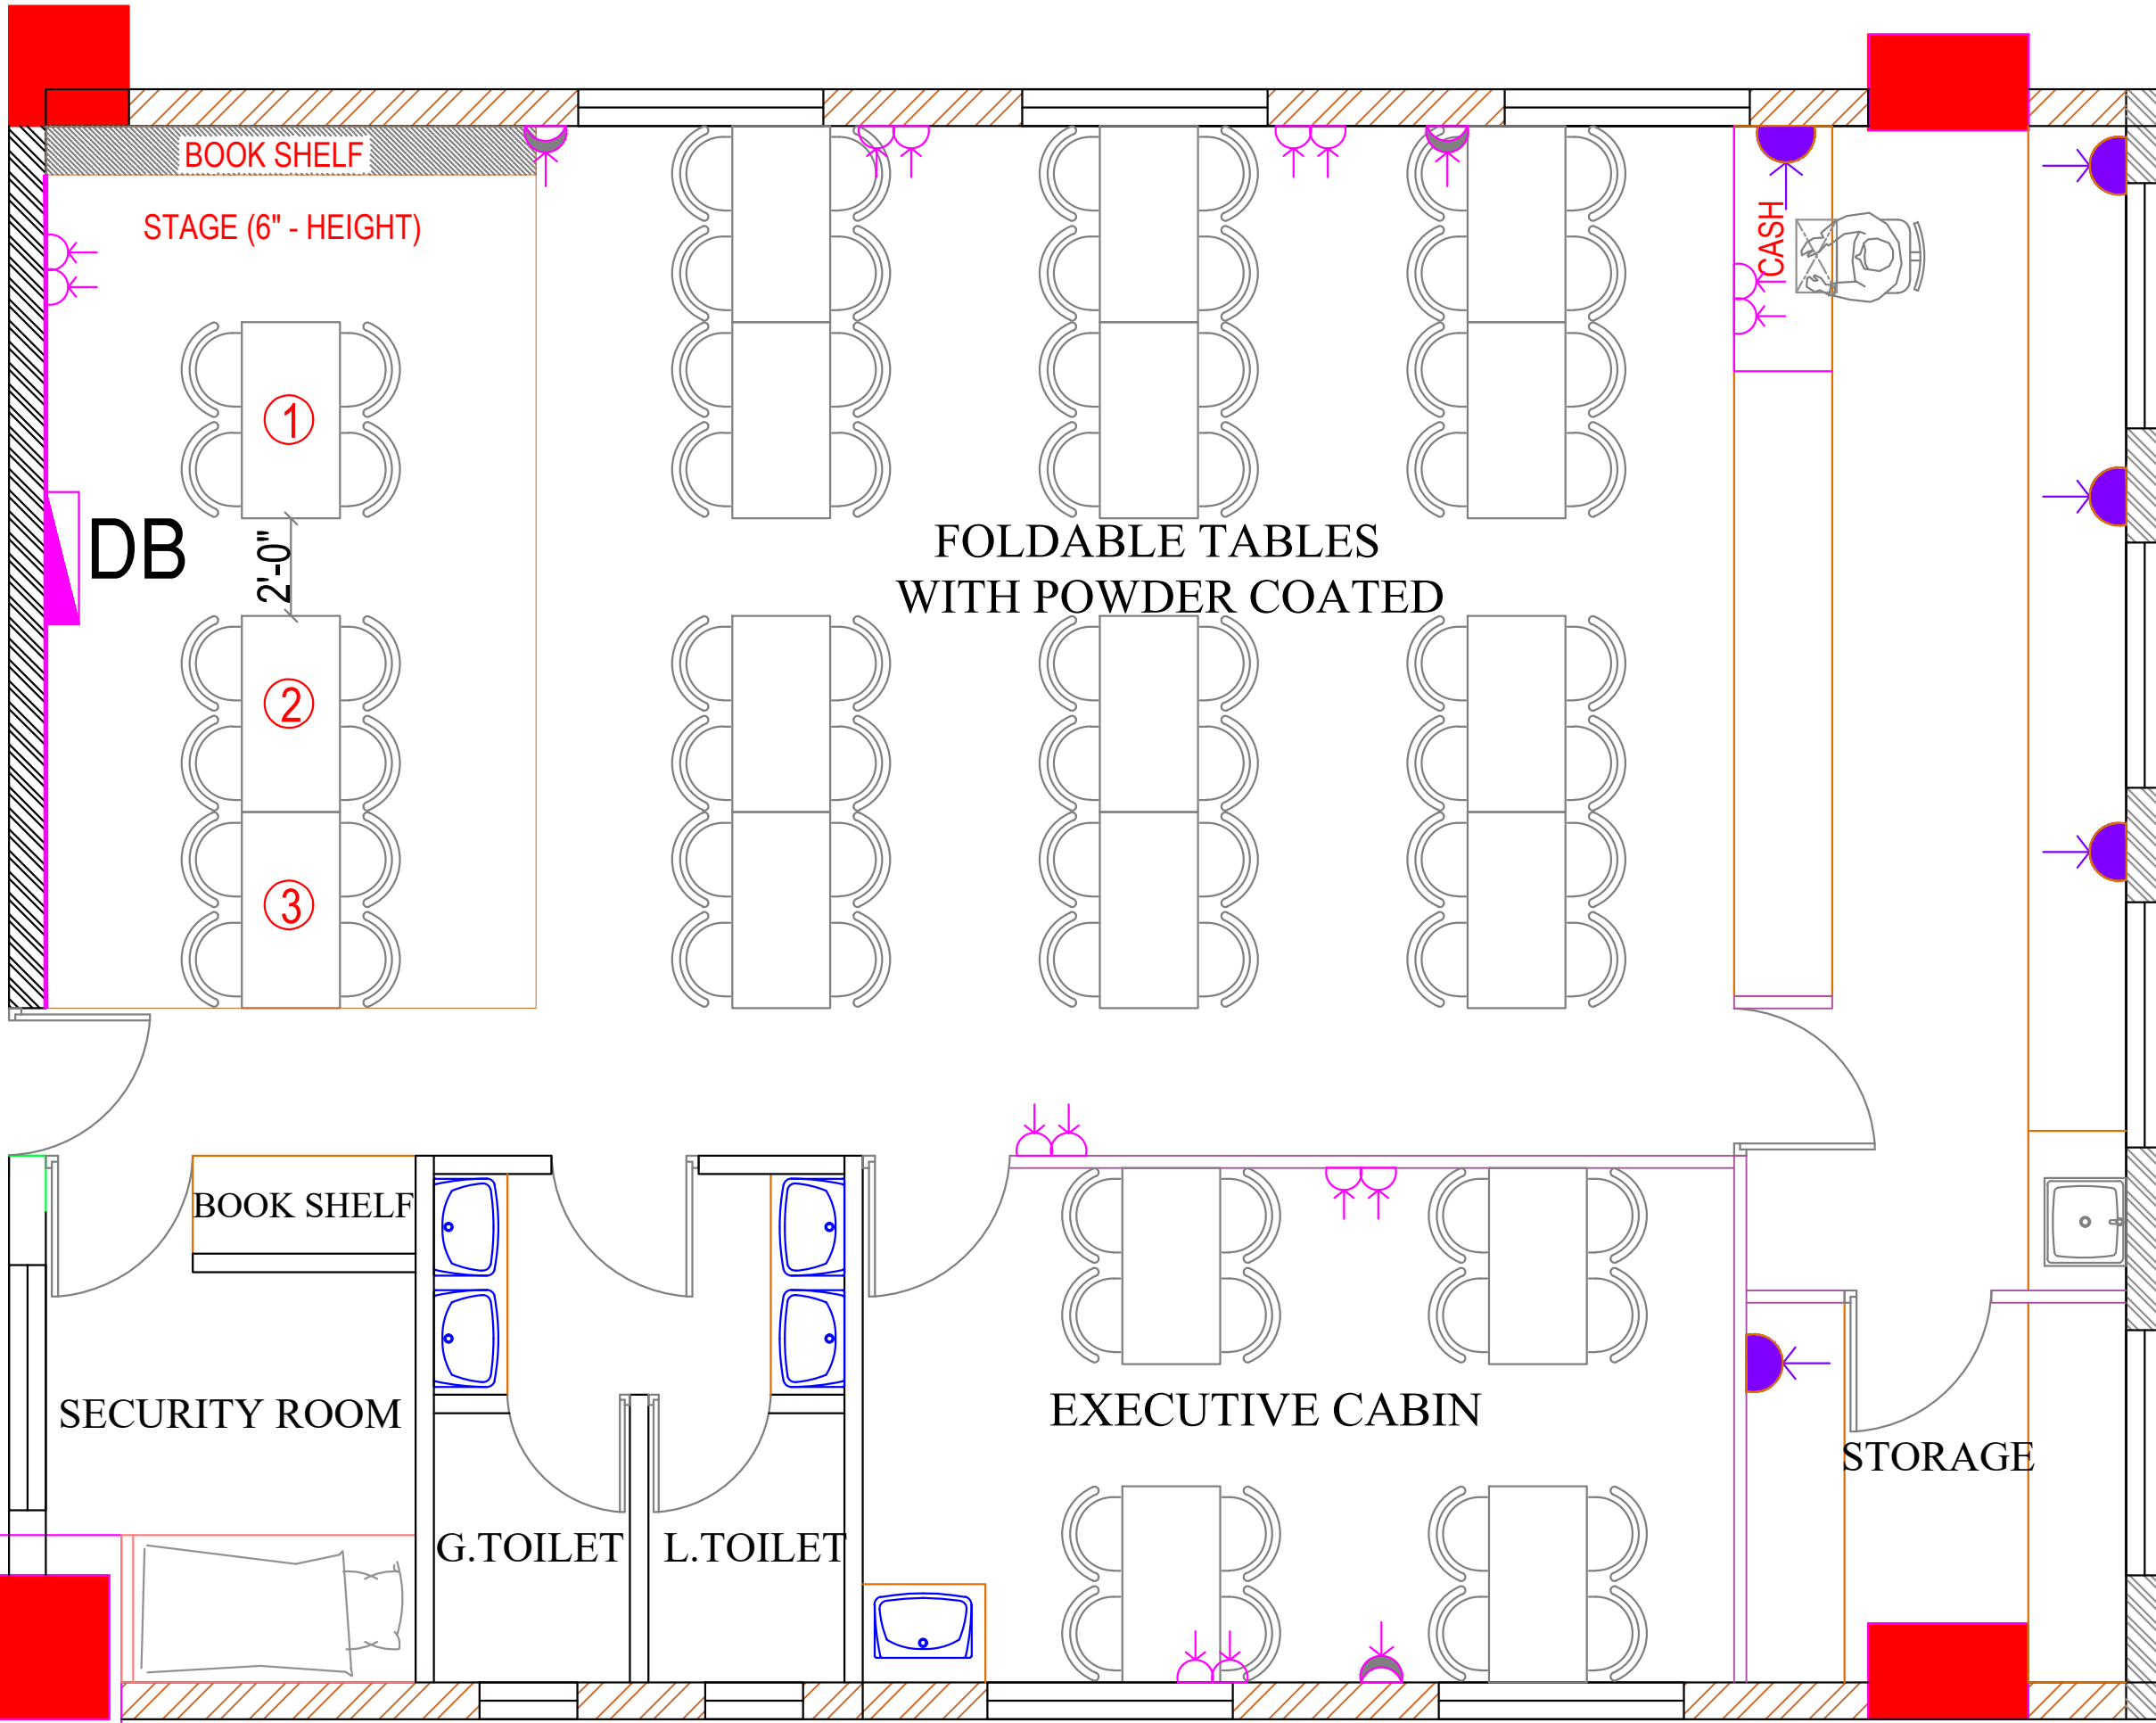

LEGEND	
	3 Nos.6A UPS Power Socket Outlet
	2 Nos.6A RAW Power Socket Outlet
	1 Nos.6A Raw Power Socket Outlet
	Modular Type 25/32A A/C Socket
	6/16ARaw Power Socket Outlet
	Data Socket
	Telephone Outlet
	6A AC Power Socket @CEILING LVL.
	Distribution Board

JOB NO 1739	PROJECT TITLE : PROPOSED INTERIOR DESIGN FOR CANARA BANK CIRCLE OFFICE SAMBAKULAM ROAD, MADURAI.	DRAWING TITLE :	POWER LAYOUT - TERRACE FLOOR	DESIGN STAGE	SCHEME LEVEL	SCALE	N.T.S	REV NO	02	ORIENTATION	ARCHITECTS TSO DESIGN COMMUNE PVT. LTD. Architects ■ Planners ■ Interior designers <small>NEW NO.16,(OLD NO.42), Ground floor, South West Boag Road, T.Nagar, Chennai - 600017. Ph : 044 - 4212 9252 Telefax : 044 - 2435 0493 E-mail : info@tsodc.com</small>
		DRAWING TYPE :	SCHEMATIC DRAWING		CONFIDENTIAL	DATE	29-04-2025	DRN	HARI G		
					FINAL COPY	R.DATE	27.09.205	CHKD	G.G		

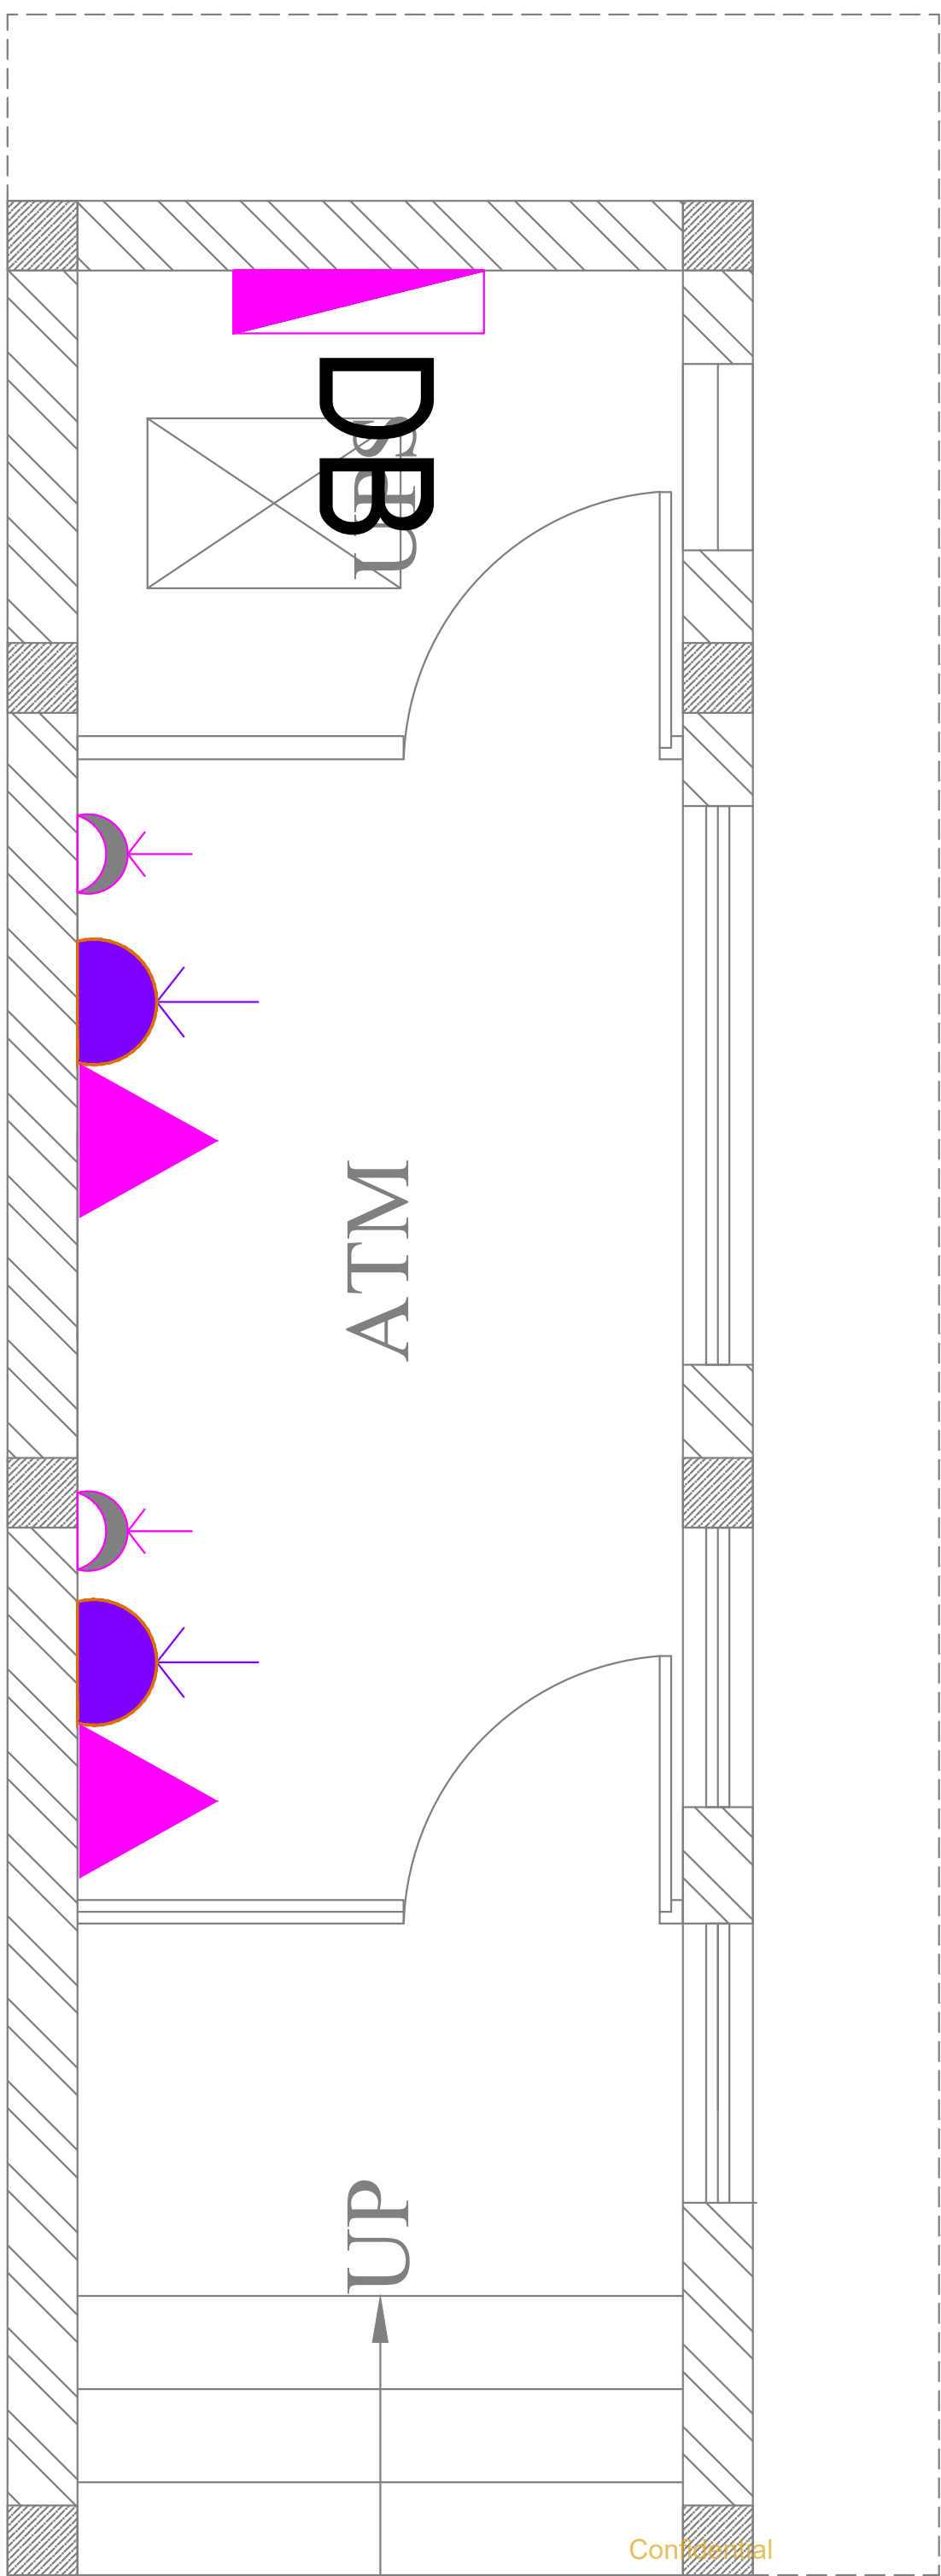


Confidential

LEGEND	
	Modular Type 25/32A A/C Socket
	6/16Raw Power Socket Outlet
	Data Socket
	Distribution Board

JOB NO 1739	PROJECT TITLE : PROPOSED INTERIOR DESIGN FOR CANARA BANK CIRCLE OFFICE SAMBAKULAM ROAD, MADURAI.		DRAWING TITLE : POWER LAYOUT - ATM	DESIGN STAGE SCHEME LEVEL FINAL COPY	SCALE DATE	N.T.S 29-04-2025	REV/NO DRN	ORIENTATION HARI G	ARCHITECTS
			DRAWING TYPE : SCHEMATIC DRAWING		R.DATE	27.09.2025	CHKD CHKD	G.G	ARCHITECTS

TSO DESIGN COMMUNE PVT. LTD.
Architects • Planners • Interior designers
NEW NO.16, OLD NO.421, Ground floor, South West Bang Road,
Madrasi, Chennai - 600 026.
Tel: 044-2435 9493 E-mail: info@tsocorp.com

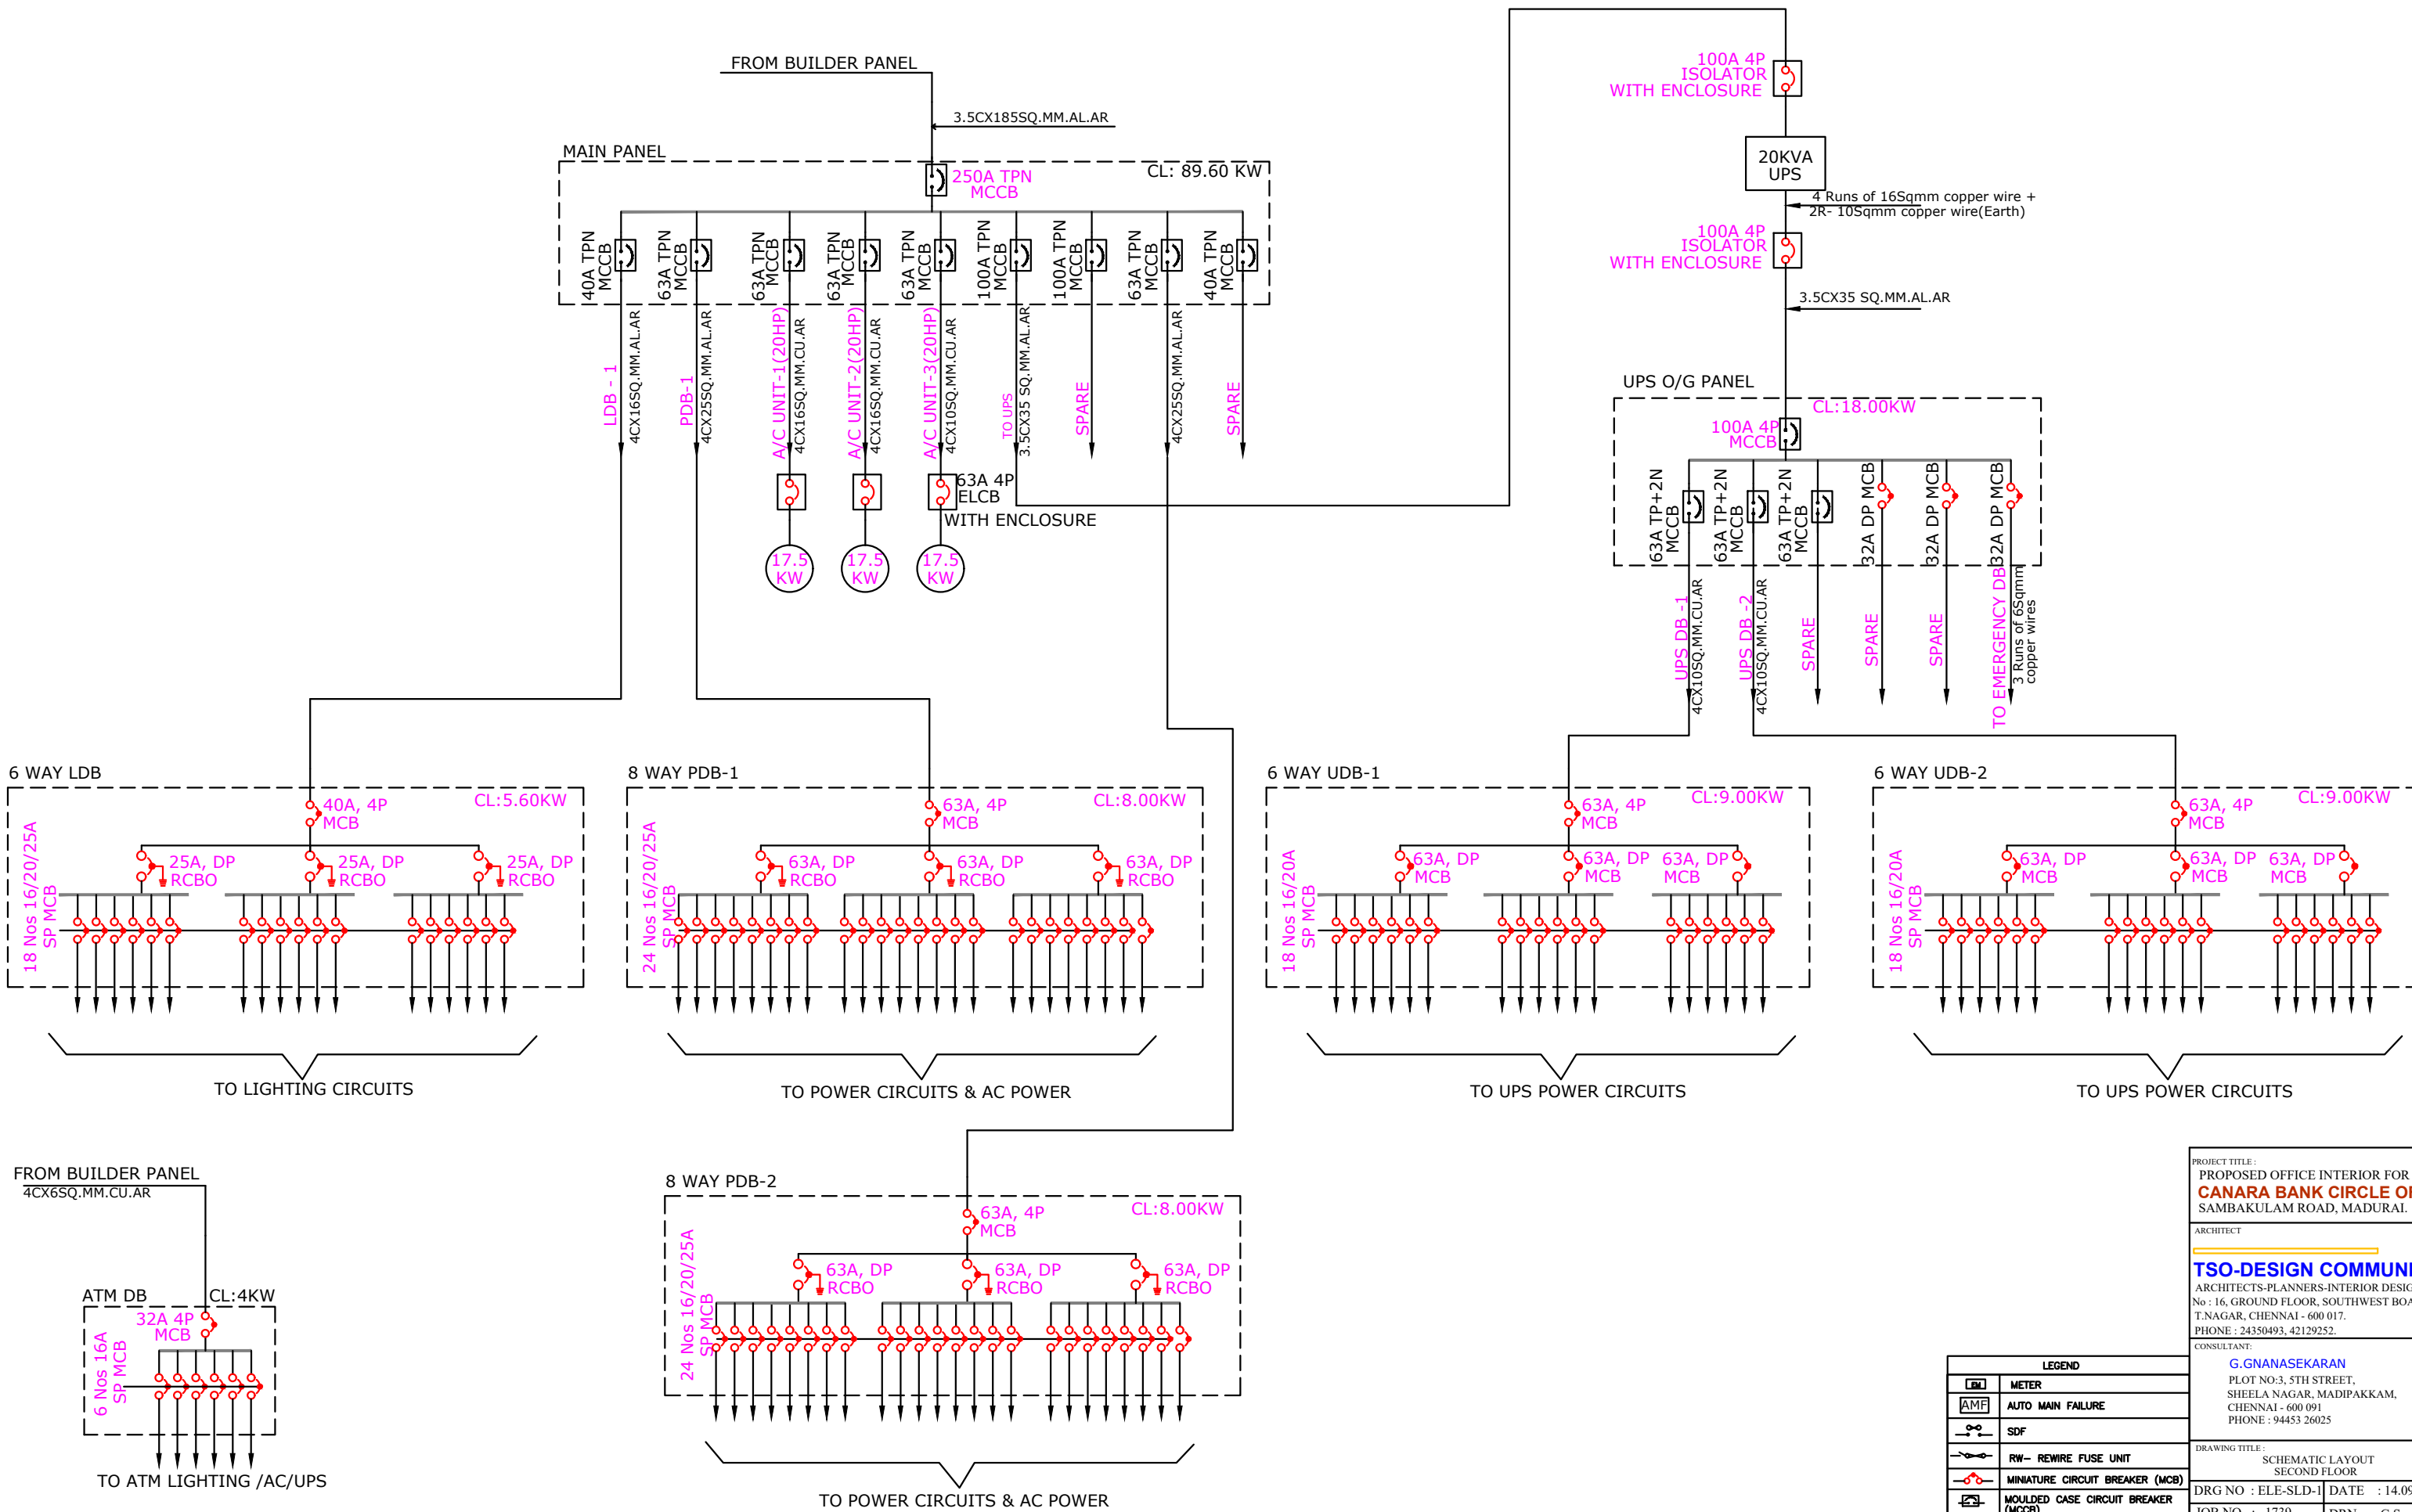

Confidential


PROJECT TITLE:
**PROPOSED OFFICE INTERIOR FOR
 CANARA BANK CIRCLE OFFICE**
 SAMBAKULAM ROAD, MADURAI.

ARCHITECT
TSO-DESIGN COMMUNE
 ARCHITECTS-PLANNERS-INTERIOR DESIGNERS
 No : 16, GROUND FLOOR, SOUTHWEST BOAG ROAD,
 T.NAGAR, CHENNAI - 600 017.
 PHONE : 24350493, 42129252.

CONSULTANT:
G.GNANASEKARAN
 PLOT NO:3, 5TH STREET,
 SHEELA NAGAR, MADIPAKKAM,
 CHENNAI - 600 091
 PHONE : 94453 26025

LEGEND	
	METER
	AUTO MAIN FAILURE
	SDF
	RW- REWIRE FUSE UNIT
	MINIATURE CIRCUIT BREAKER (MCB)
	MOULDED CASE CIRCUIT BREAKER (MCCB)
	EARTH LEAKAGE CIRCUIT BREAKER (ELCB)

DRAWING TITLE: SCHEMATIC LAYOUT SECOND FLOOR	
DRG NO : ELE-SLD-1	DATE : 14.09.2025
JOB NO : 1739	DRN : G.S.
SCALE : NTS	CHECKED : G.G.

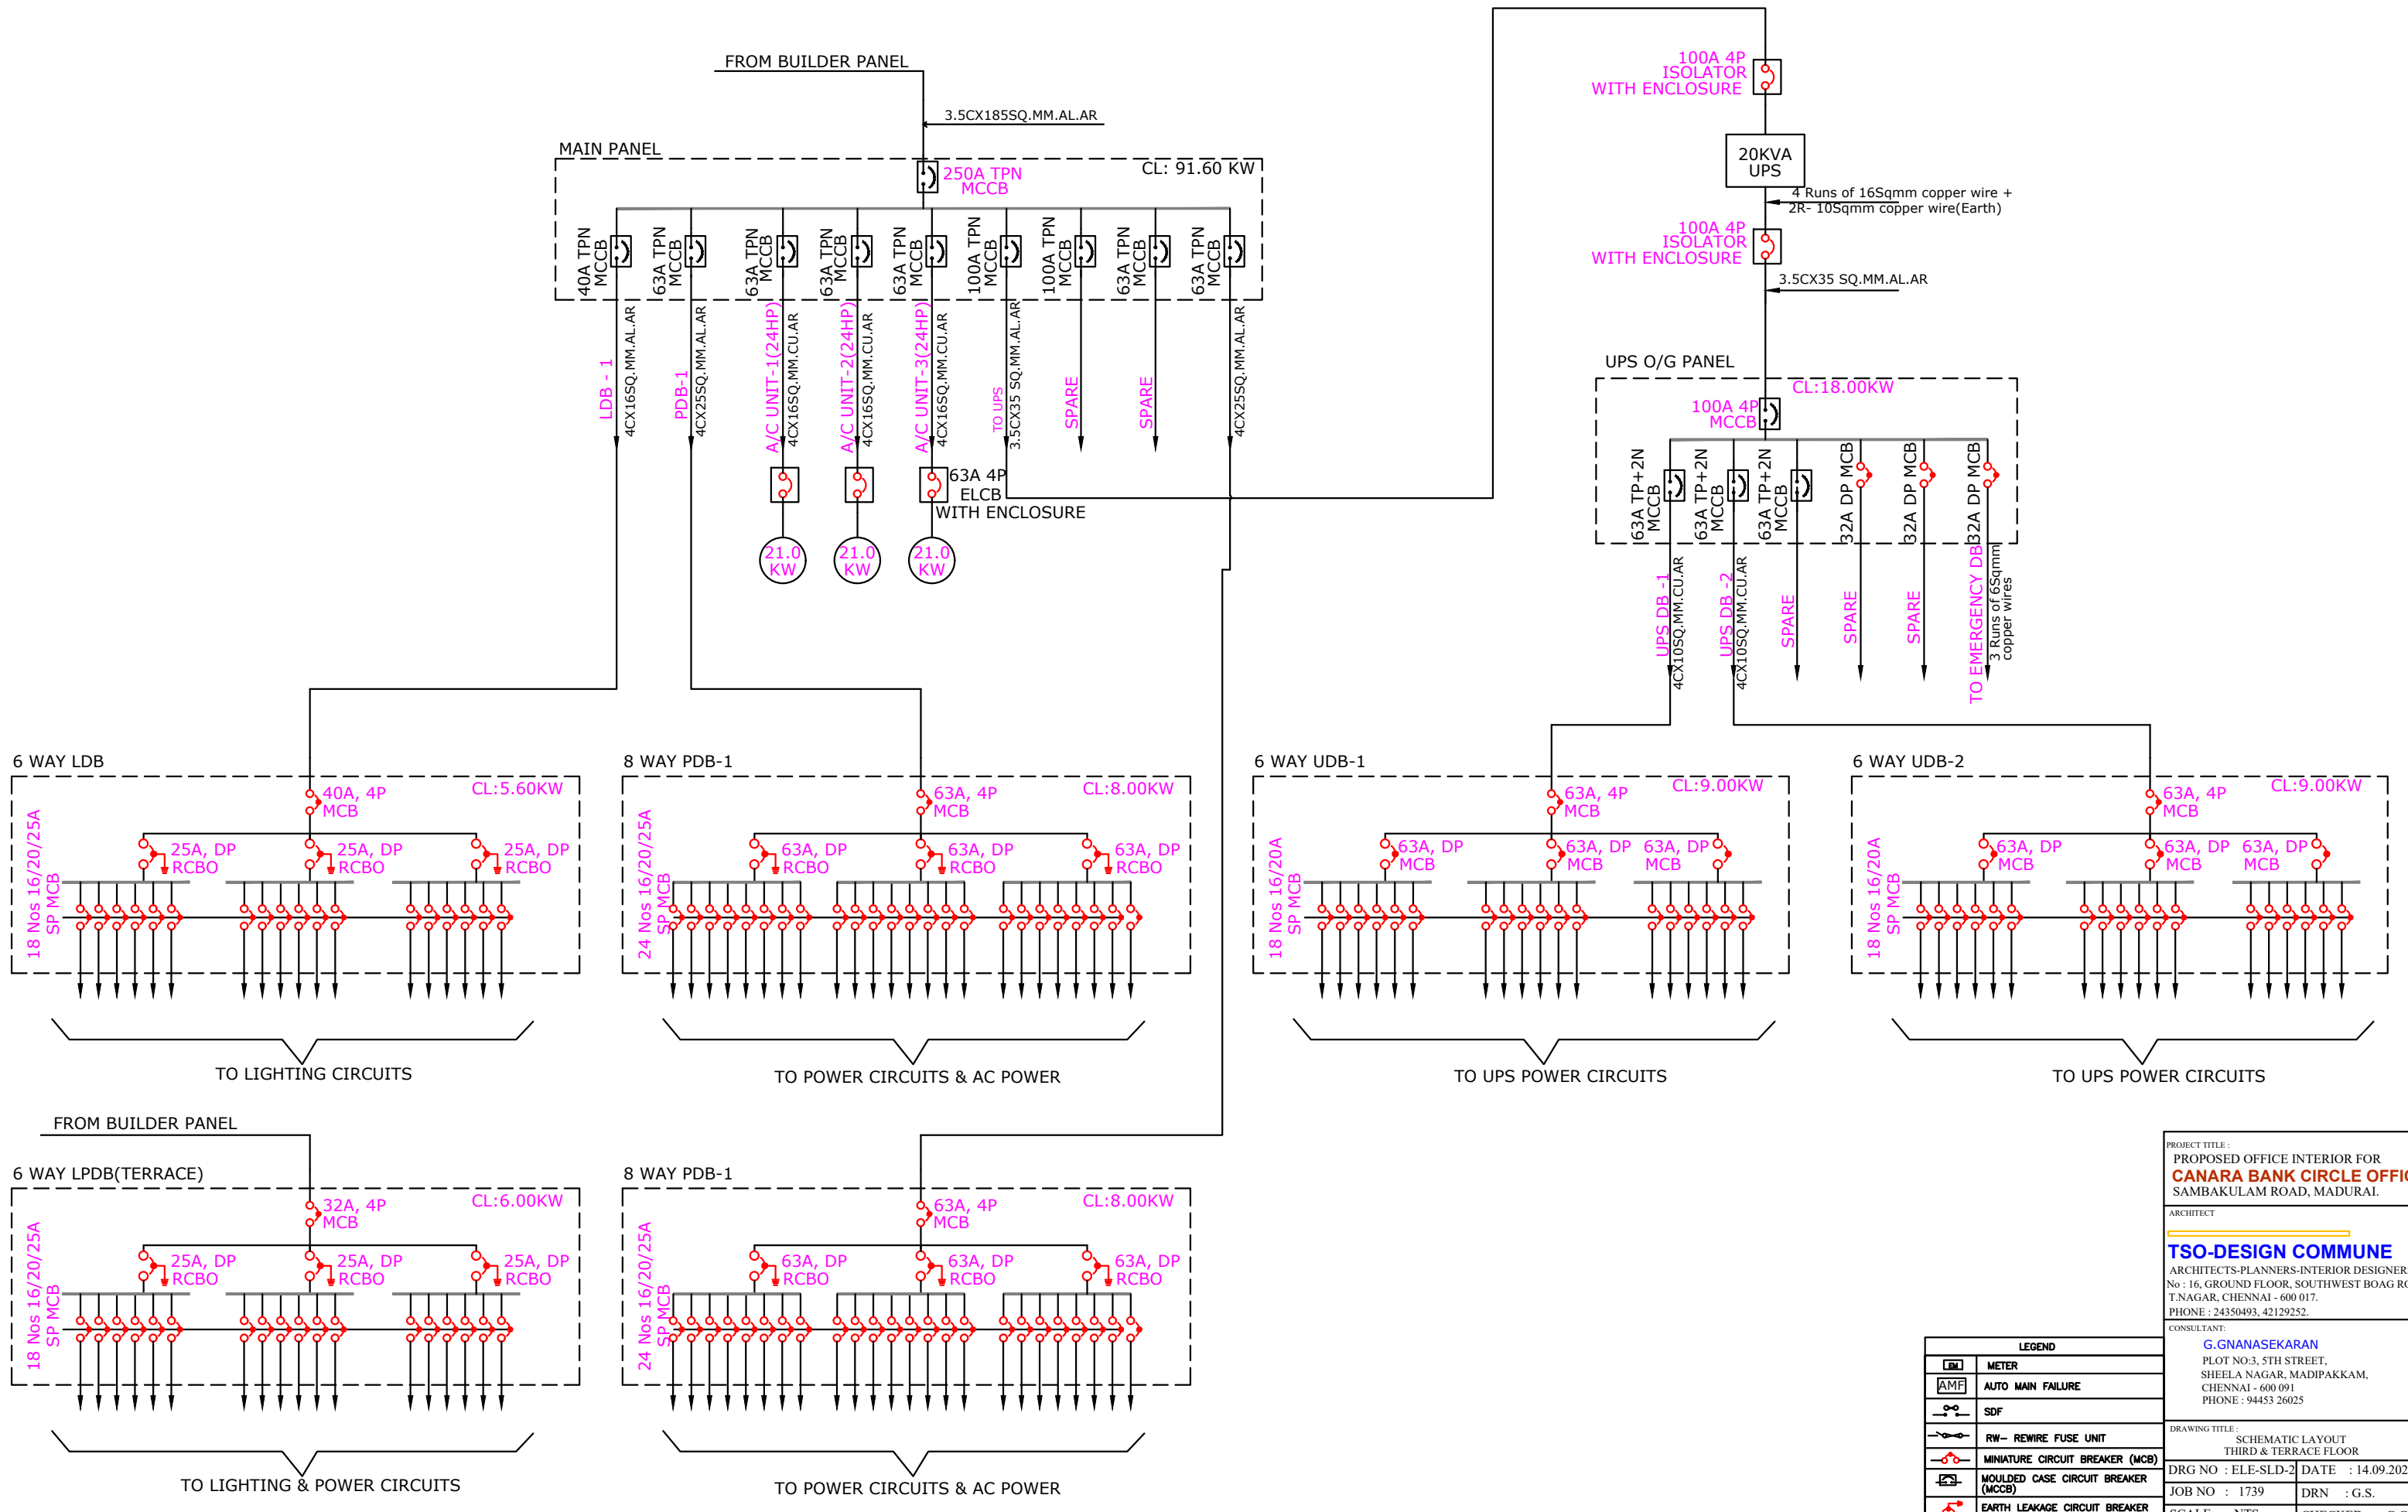

Confidential

PROJECT TITLE :
PROPOSED OFFICE INTERIOR FOR CANARA BANK CIRCLE OFFICE
 SAMBAKULAM ROAD, MADURAI.


ARCHITECT
TSO-DESIGN COMMUNE
 ARCHITECTS-PLANNERS-INTERIOR DESIGNERS
 No : 16, GROUND FLOOR, SOUTHWEST BOAG ROAD
 T.NAGAR, CHENNAI - 600 017.
 PHONE : 24350493, 42129252.

CONSULTANT:
G.GNANASEKARAN
 PLOT NO:3, 5TH STREET,
 SHEELA NAGAR, MADIPAKKAM,
 CHENNAI - 600 091
 PHONE : 94453 26025

DRAWING TITLE :
 SCHEMATIC LAYOUT
 THIRD & TERRACE FLOOR


DRG NO : ELE-SLD-2 DATE : 14.09.2025
 JOB NO : 1739 DRN : G.S.
 SCALE : NTS CHECKED : G.G.

LEGEND	
	METER
	AUTO MAIN FAILURE
	SDF
	RW- REWIRE FUSE UNIT
	MINIATURE CIRCUIT BREAKER (MCB)
	MOULDED CASE CIRCUIT BREAKER (MCCB)
	EARTH LEAKAGE CIRCUIT BREAKER (ELCB)

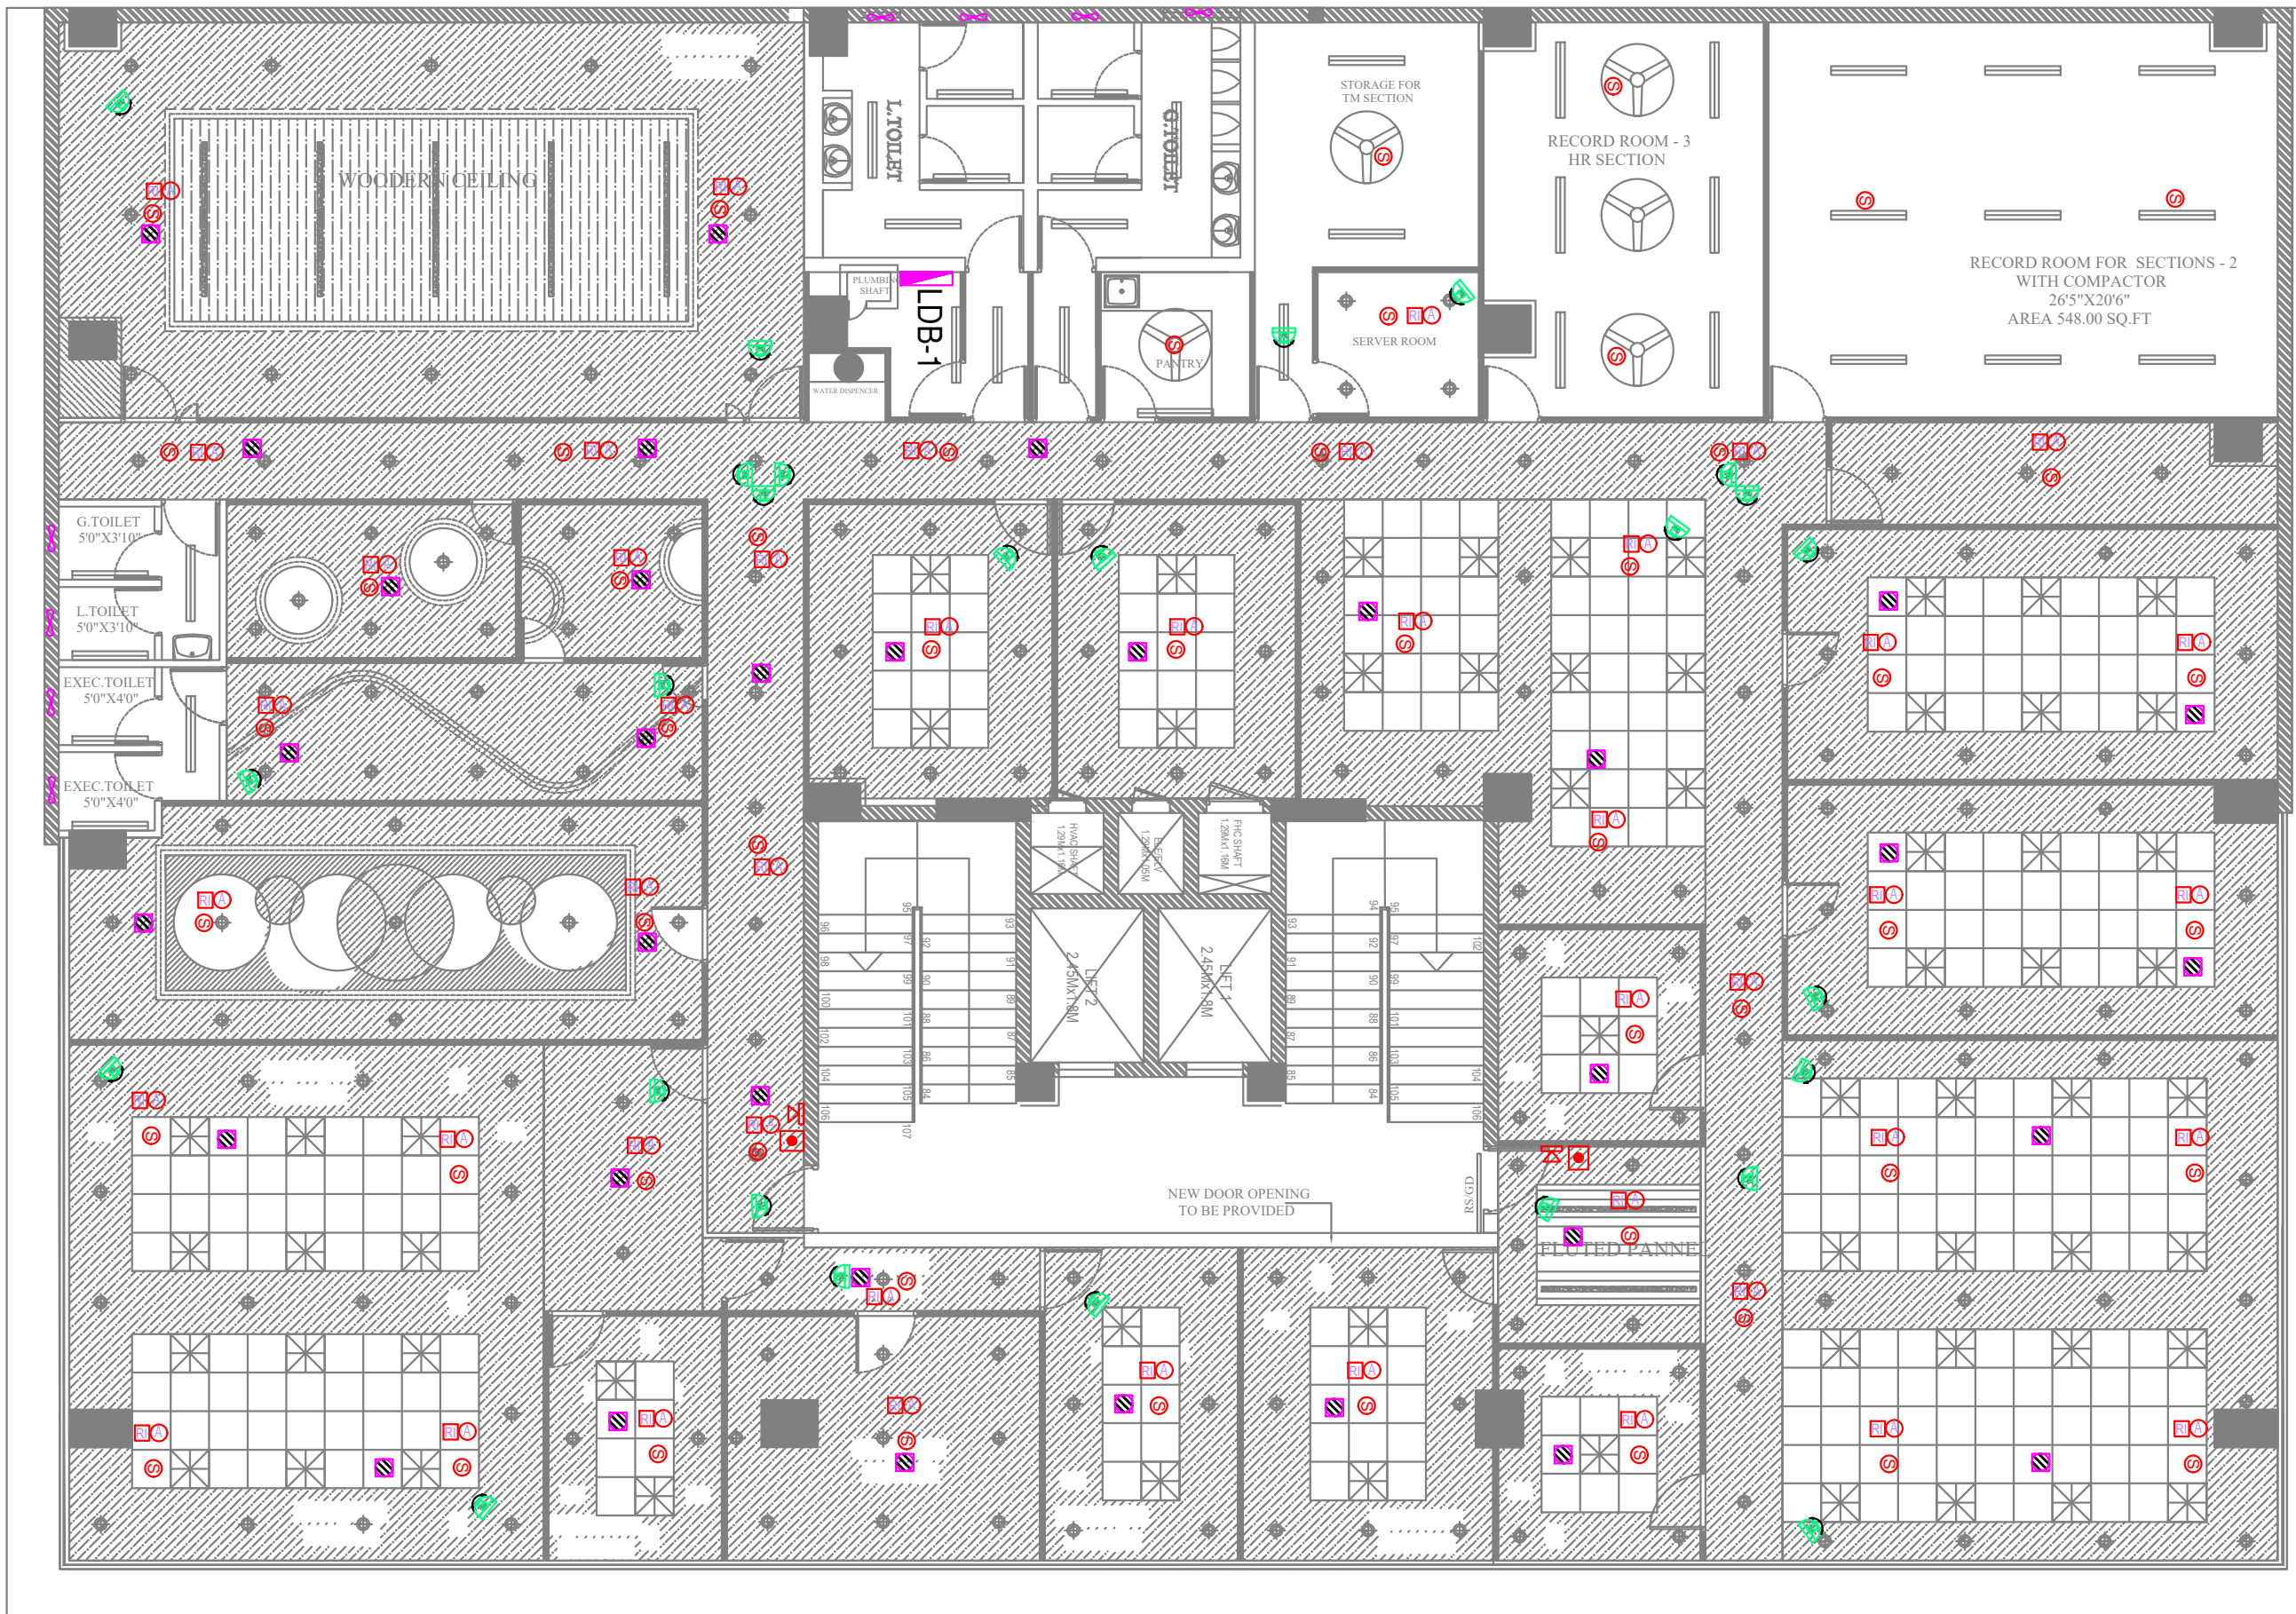


LEGEND	
	SMOKE DETECTOR
	HOOTER
	MANUAL CALL POINT
	CEILING SPEAKER
	HEAT DETECTOR
	ABOVE SMOKE DETECTOR
	RESPONSE INDICATOR
	CAMERA

JOB NO 1739	PROJECT TITLE : PROPOSED INTERIOR DESIGN FOR CANARA BANK CIRCLE OFFICE SAMBAKULAM ROAD, MADURAI.	FIRE ALARM LAYOUT - SECOND FLOOR	DESIGN STAGE	SCALE	N.T.S	REV NO	REV - 01	ORIENTATION 	ARCHITECTS TSO DESIGN COMMUNE PVT. LTD. Architects ■ Planners ■ Interior designers
			SCHMATIC DRAWING	DATE	29-04-2025	DRN	HARI G		
			SCHEME LEVEL	R.DATE	06.09.2025	CHKD	G.G		

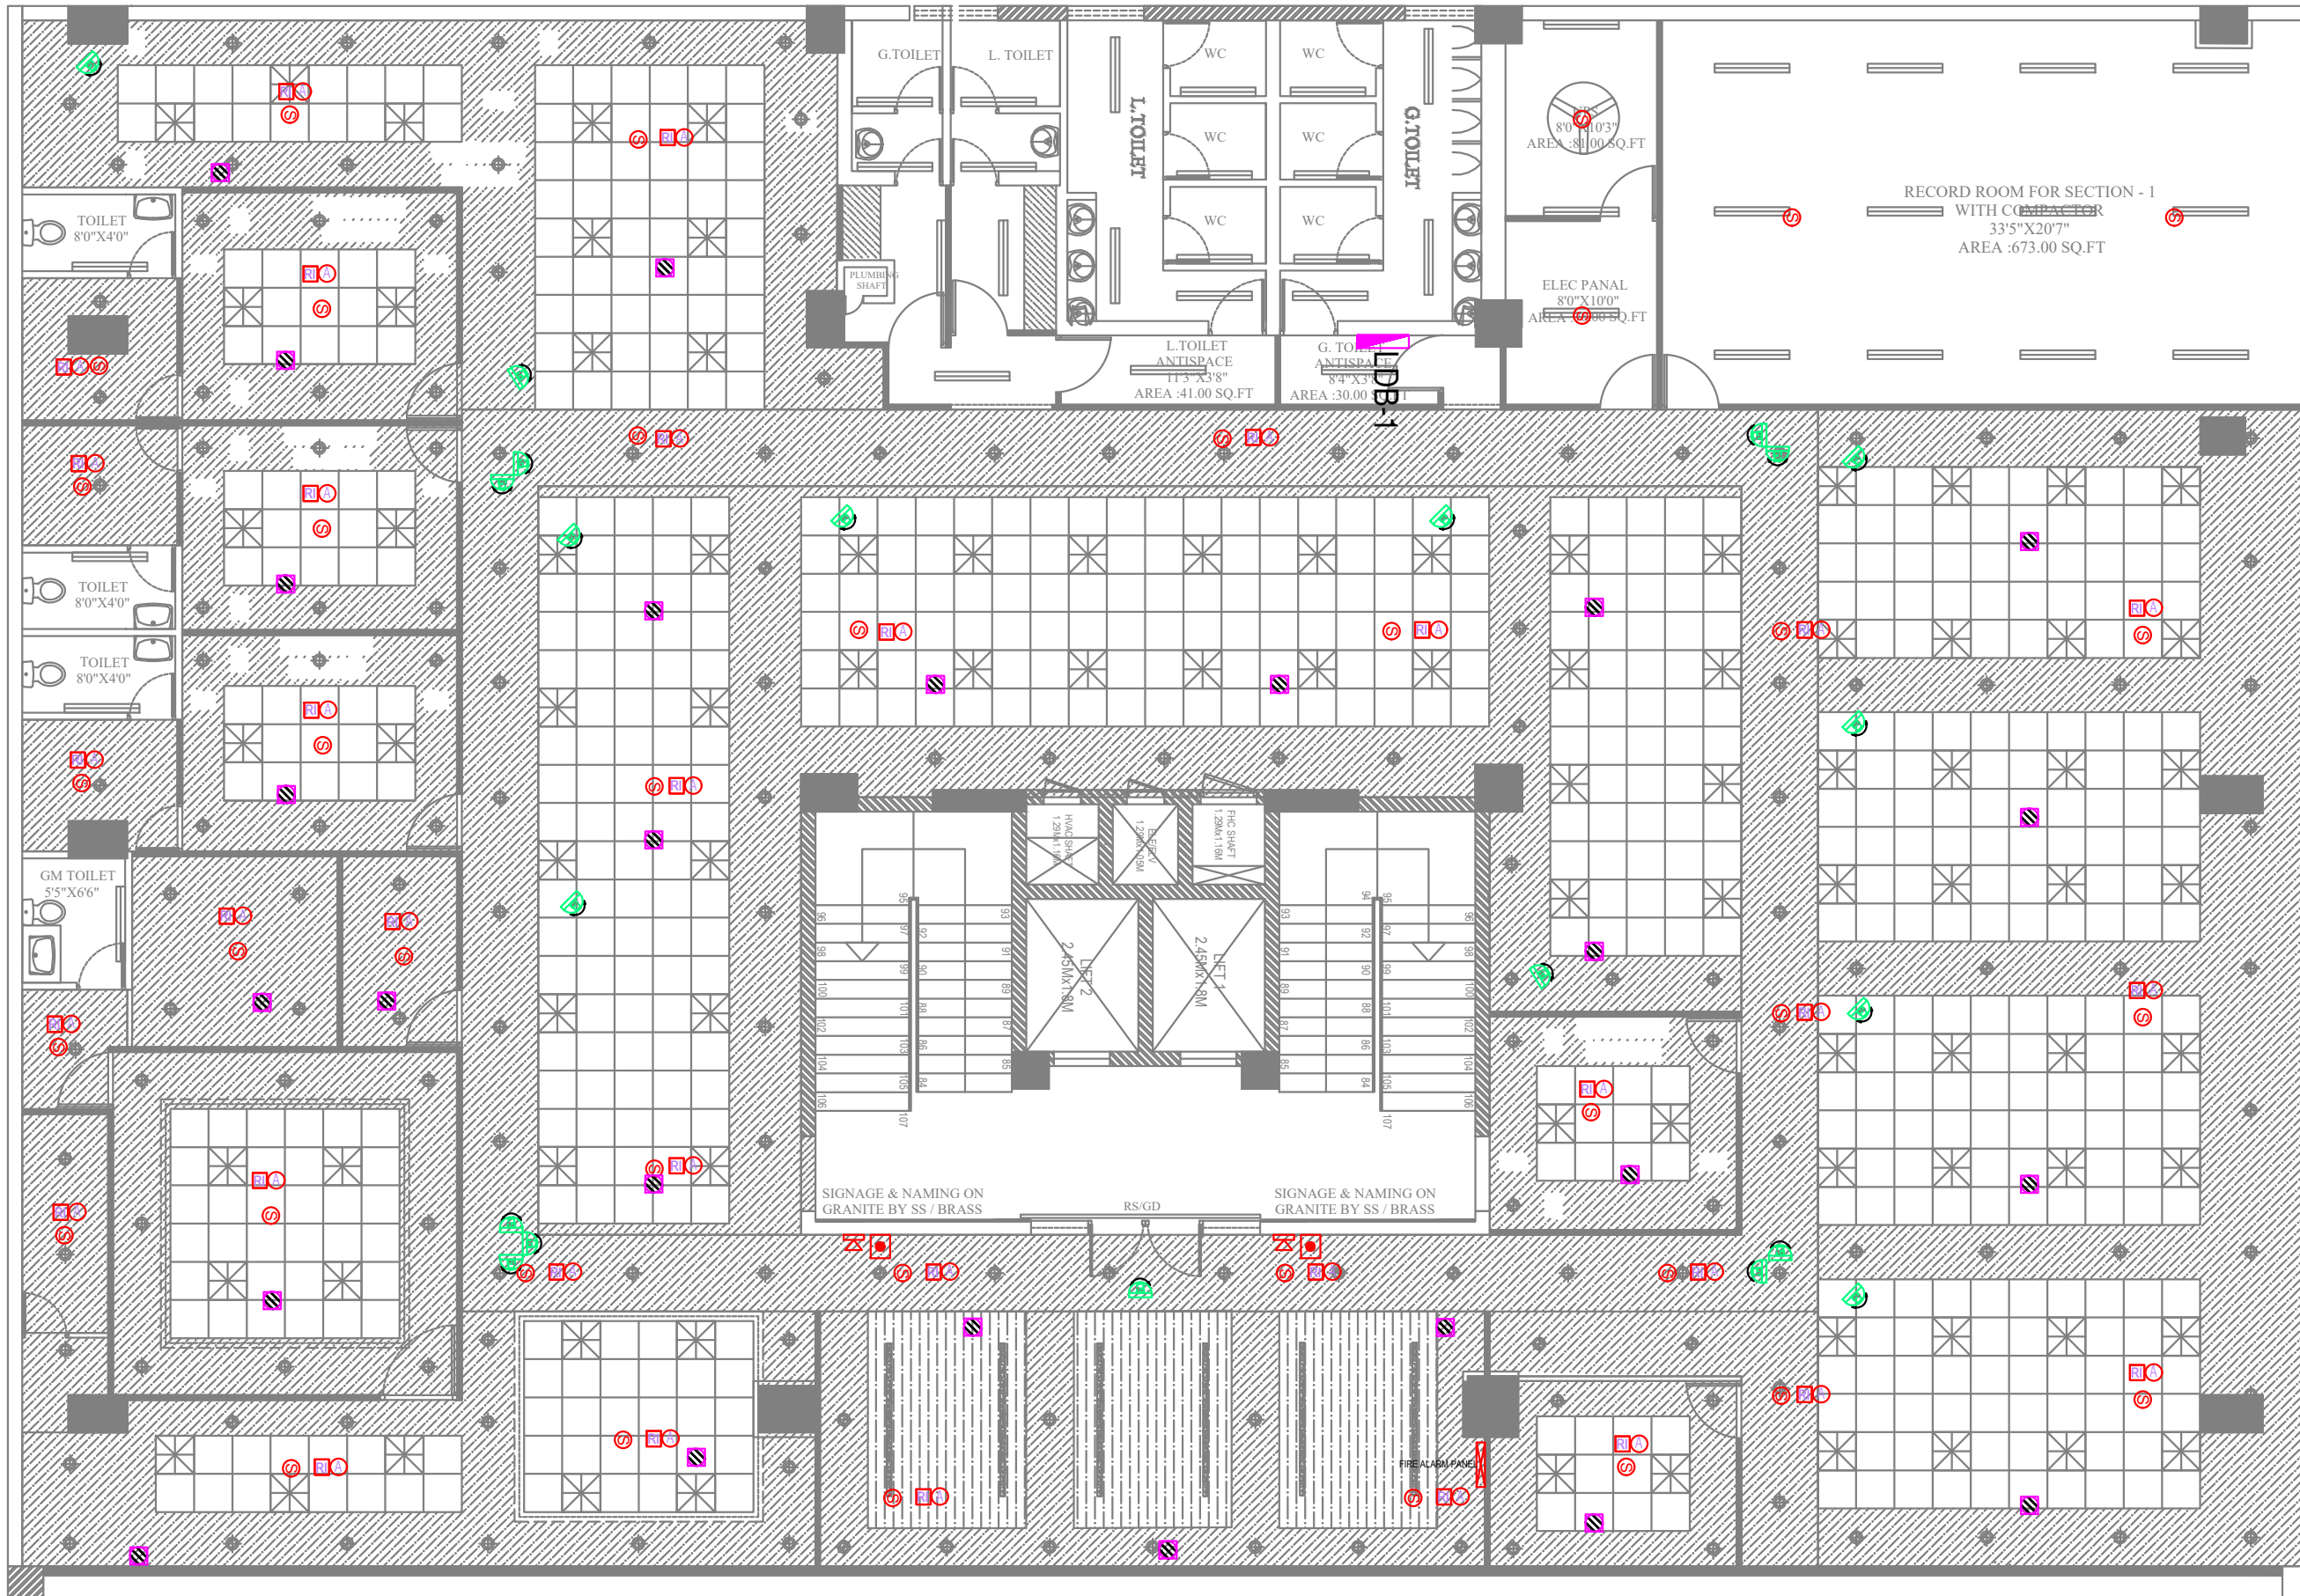


LEGEND	
	SMOKE DETECTOR
	HOOTER
	MANUAL CALL POINT
	CEILING SPEAKER
	HEAT DETECTOR
	ABOVE SMOKE DETECTOR
	RESPONSE INDICATOR
	CAMERA

JOB NO 1739	PROJECT TITLE : PROPOSED INTERIOR DESIGN FOR CANARA BANK CIRCLE OFFICE SAMBAKULAM ROAD, MADURAI.	DRAWING TITLE :	FIRE ALARM LAYOUT - THIRD FLOOR	DESIGN STAGE	SCHEME LEVEL	SCALE	N.T.S	REV NO	REV - 01	ORIENTATION	ARCHITECTS TSO DESIGN COMMUNE PVT. LTD. Architects ■ Planners ■ Interior designers NEW NO.16,(OLD NO.42), Ground floor, South West Boag Road, T.Nagar, Chennai - 600017. Ph : 044 - 4212 9252 Telefax : 044 - 2435 0493 E-mail : info@tdc.com
		DRAWING TYPE :	SCHEMATIC DRAWING		FINAL COPY	DATE	29-04-2025	DRN	HARI G		
						R.DATE	06.09.2025	CHKD	G.G		

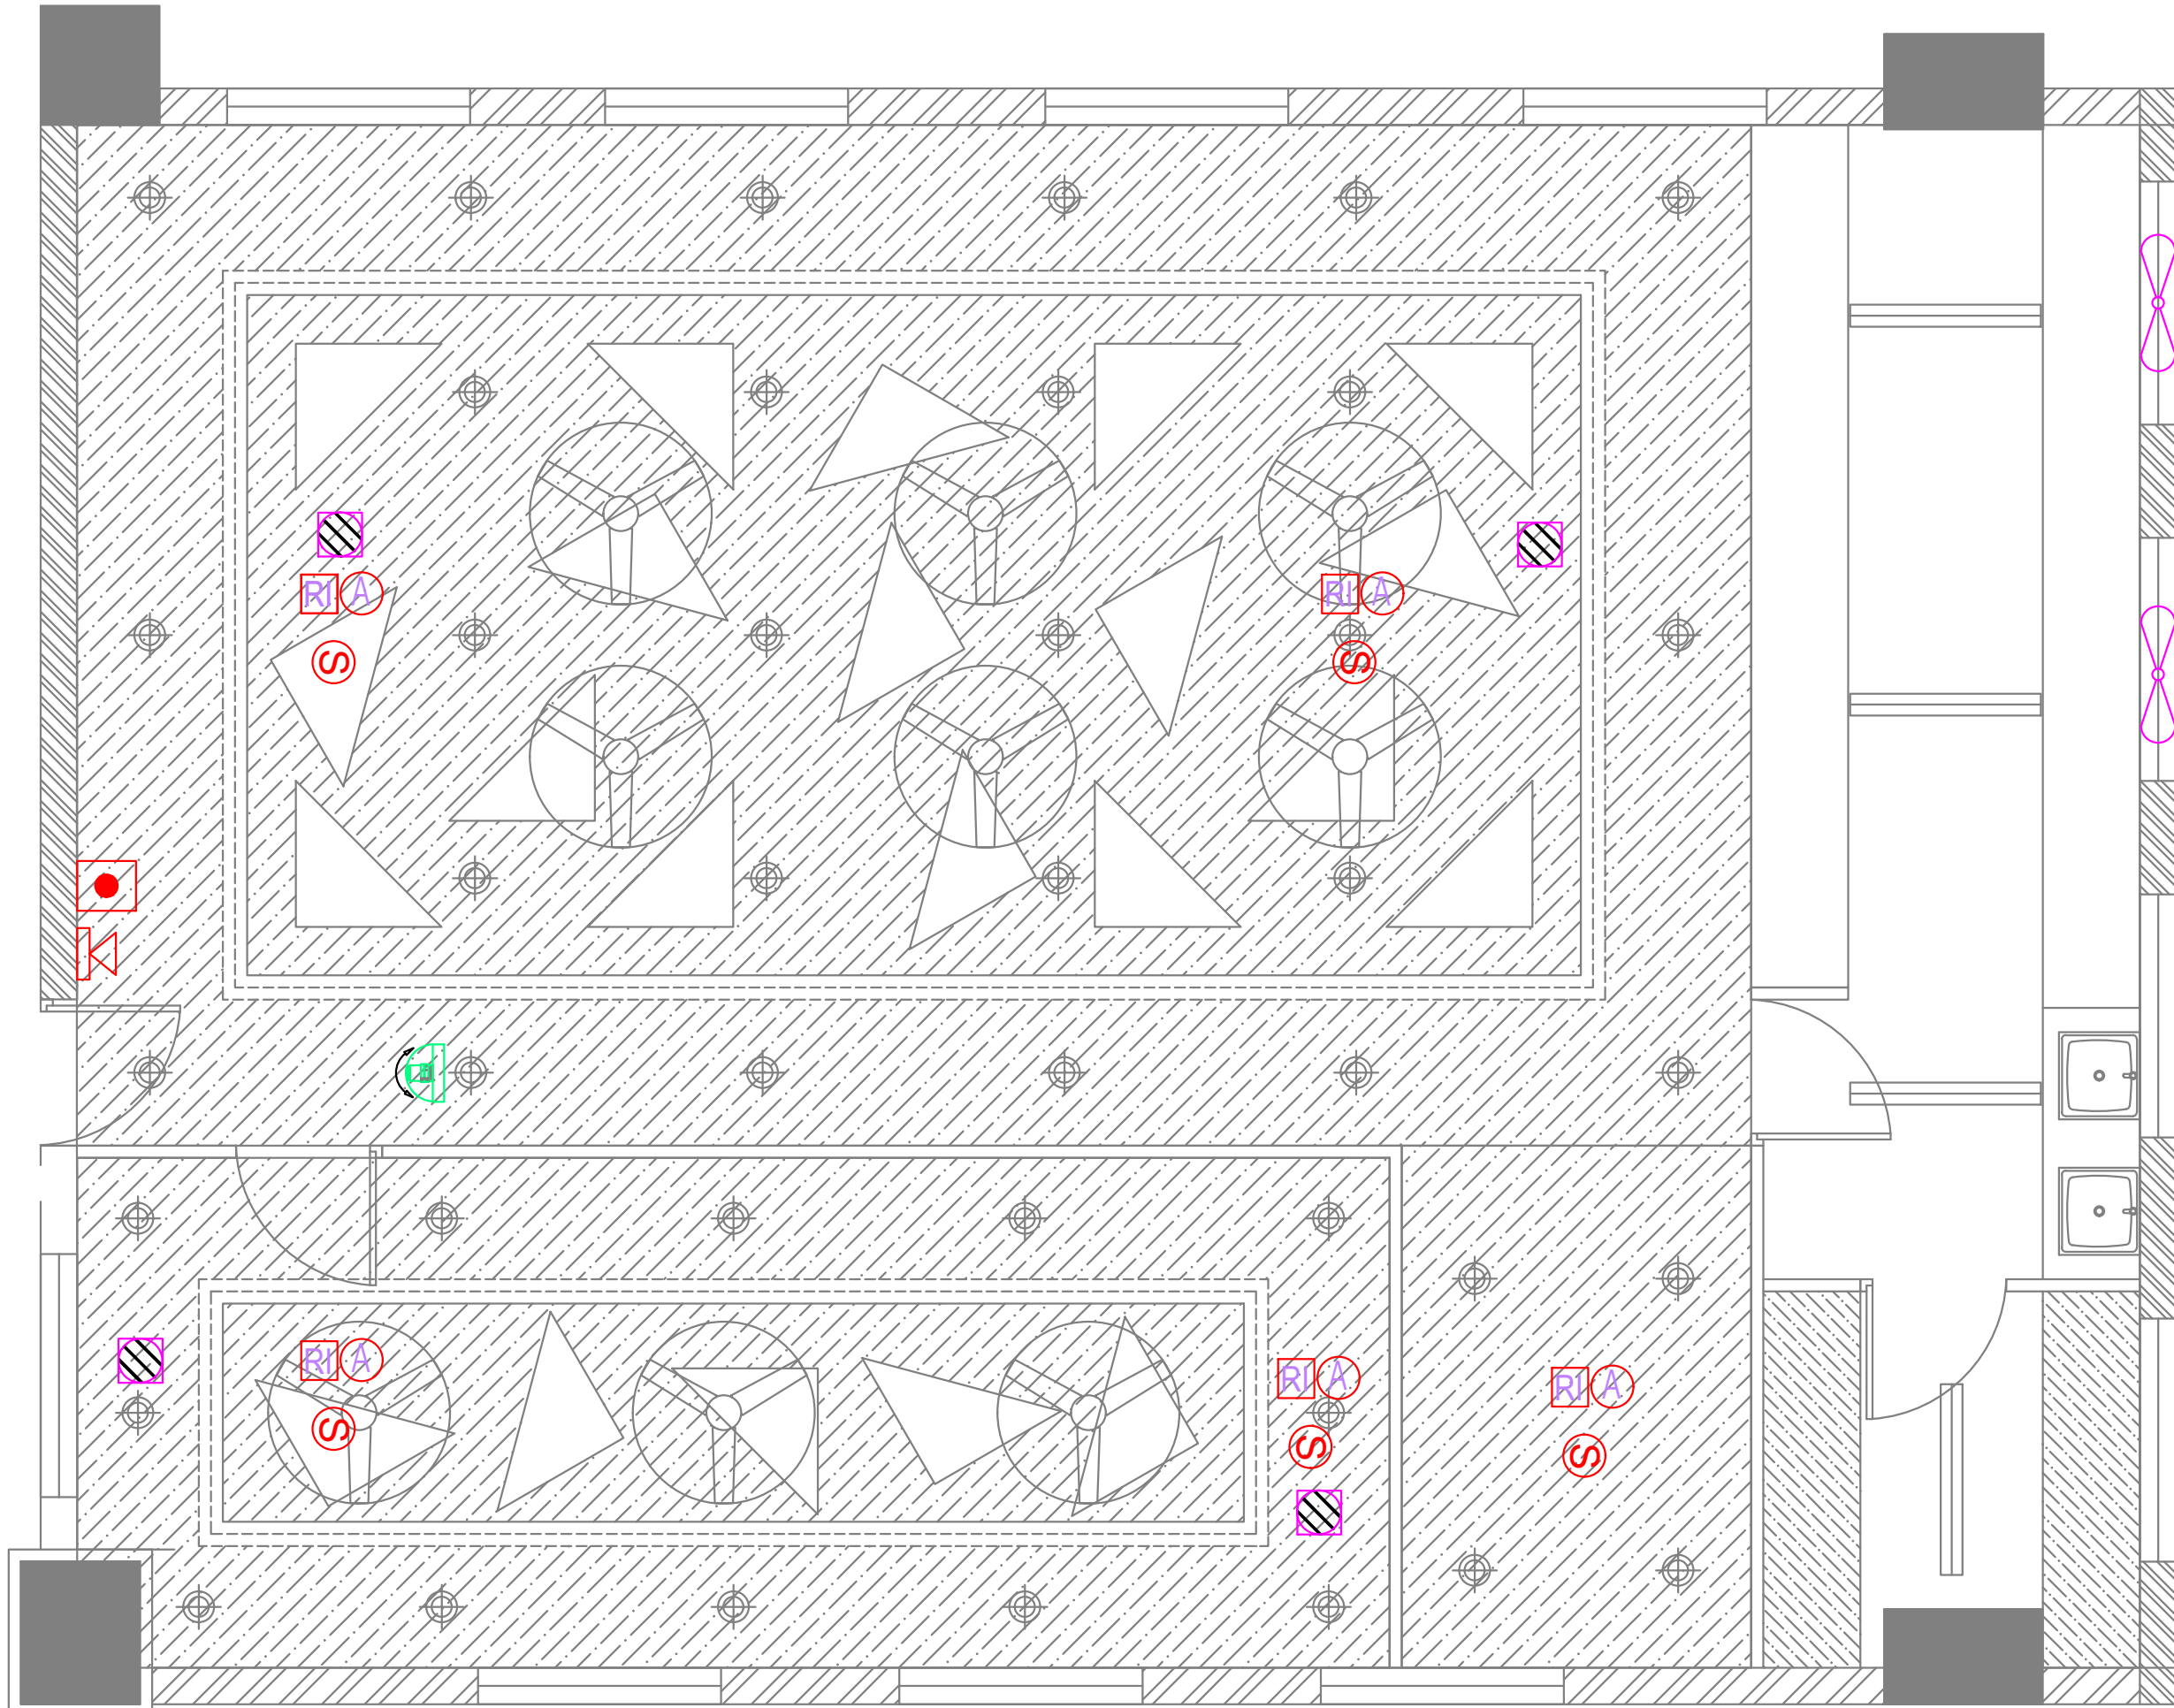

LEGEND	
	SMOKE DETECTOR
	HOOTER
	MANUAL CALL POINT
	CEILING SPEAKER
	HEAT DETECTOR
	ABOVE SMOKE DETECTOR
	RESPONSE INDICATOR
	CAMERA

JOB NO 1739	PROJECT TITLE : PROPOSED INTERIOR DESIGN FOR CANARA BANK CIRCLE OFFICE SAMBAKULAM ROAD, MADURAI.	DRAWING TITLE : FIRE ALARM LAYOUT TERRACE FLOOR	DESIGN STAGE Scheme Level	SCALE N.T.S	DATE 29-04-2025	REV NO 01	ORIENTATION 	ARCHITECTS TSO DESIGN COMMUNE PVT. LTD. Architects ■ Planners ■ Interior designers NEW NO.16,(OLD NO.42), Ground floor, South West Boag Road, T.Nagar, Chennai - 600017. Ph : 044 - 4212 9252 Telefax : 044 - 2435 0493 E-mail : info@tsodc.com
		DRAWING TYPE : SCHEMATIC DRAWING	Final Copy	R.DATE 06.09.2025	DRN HARI G	CHKD G.G		

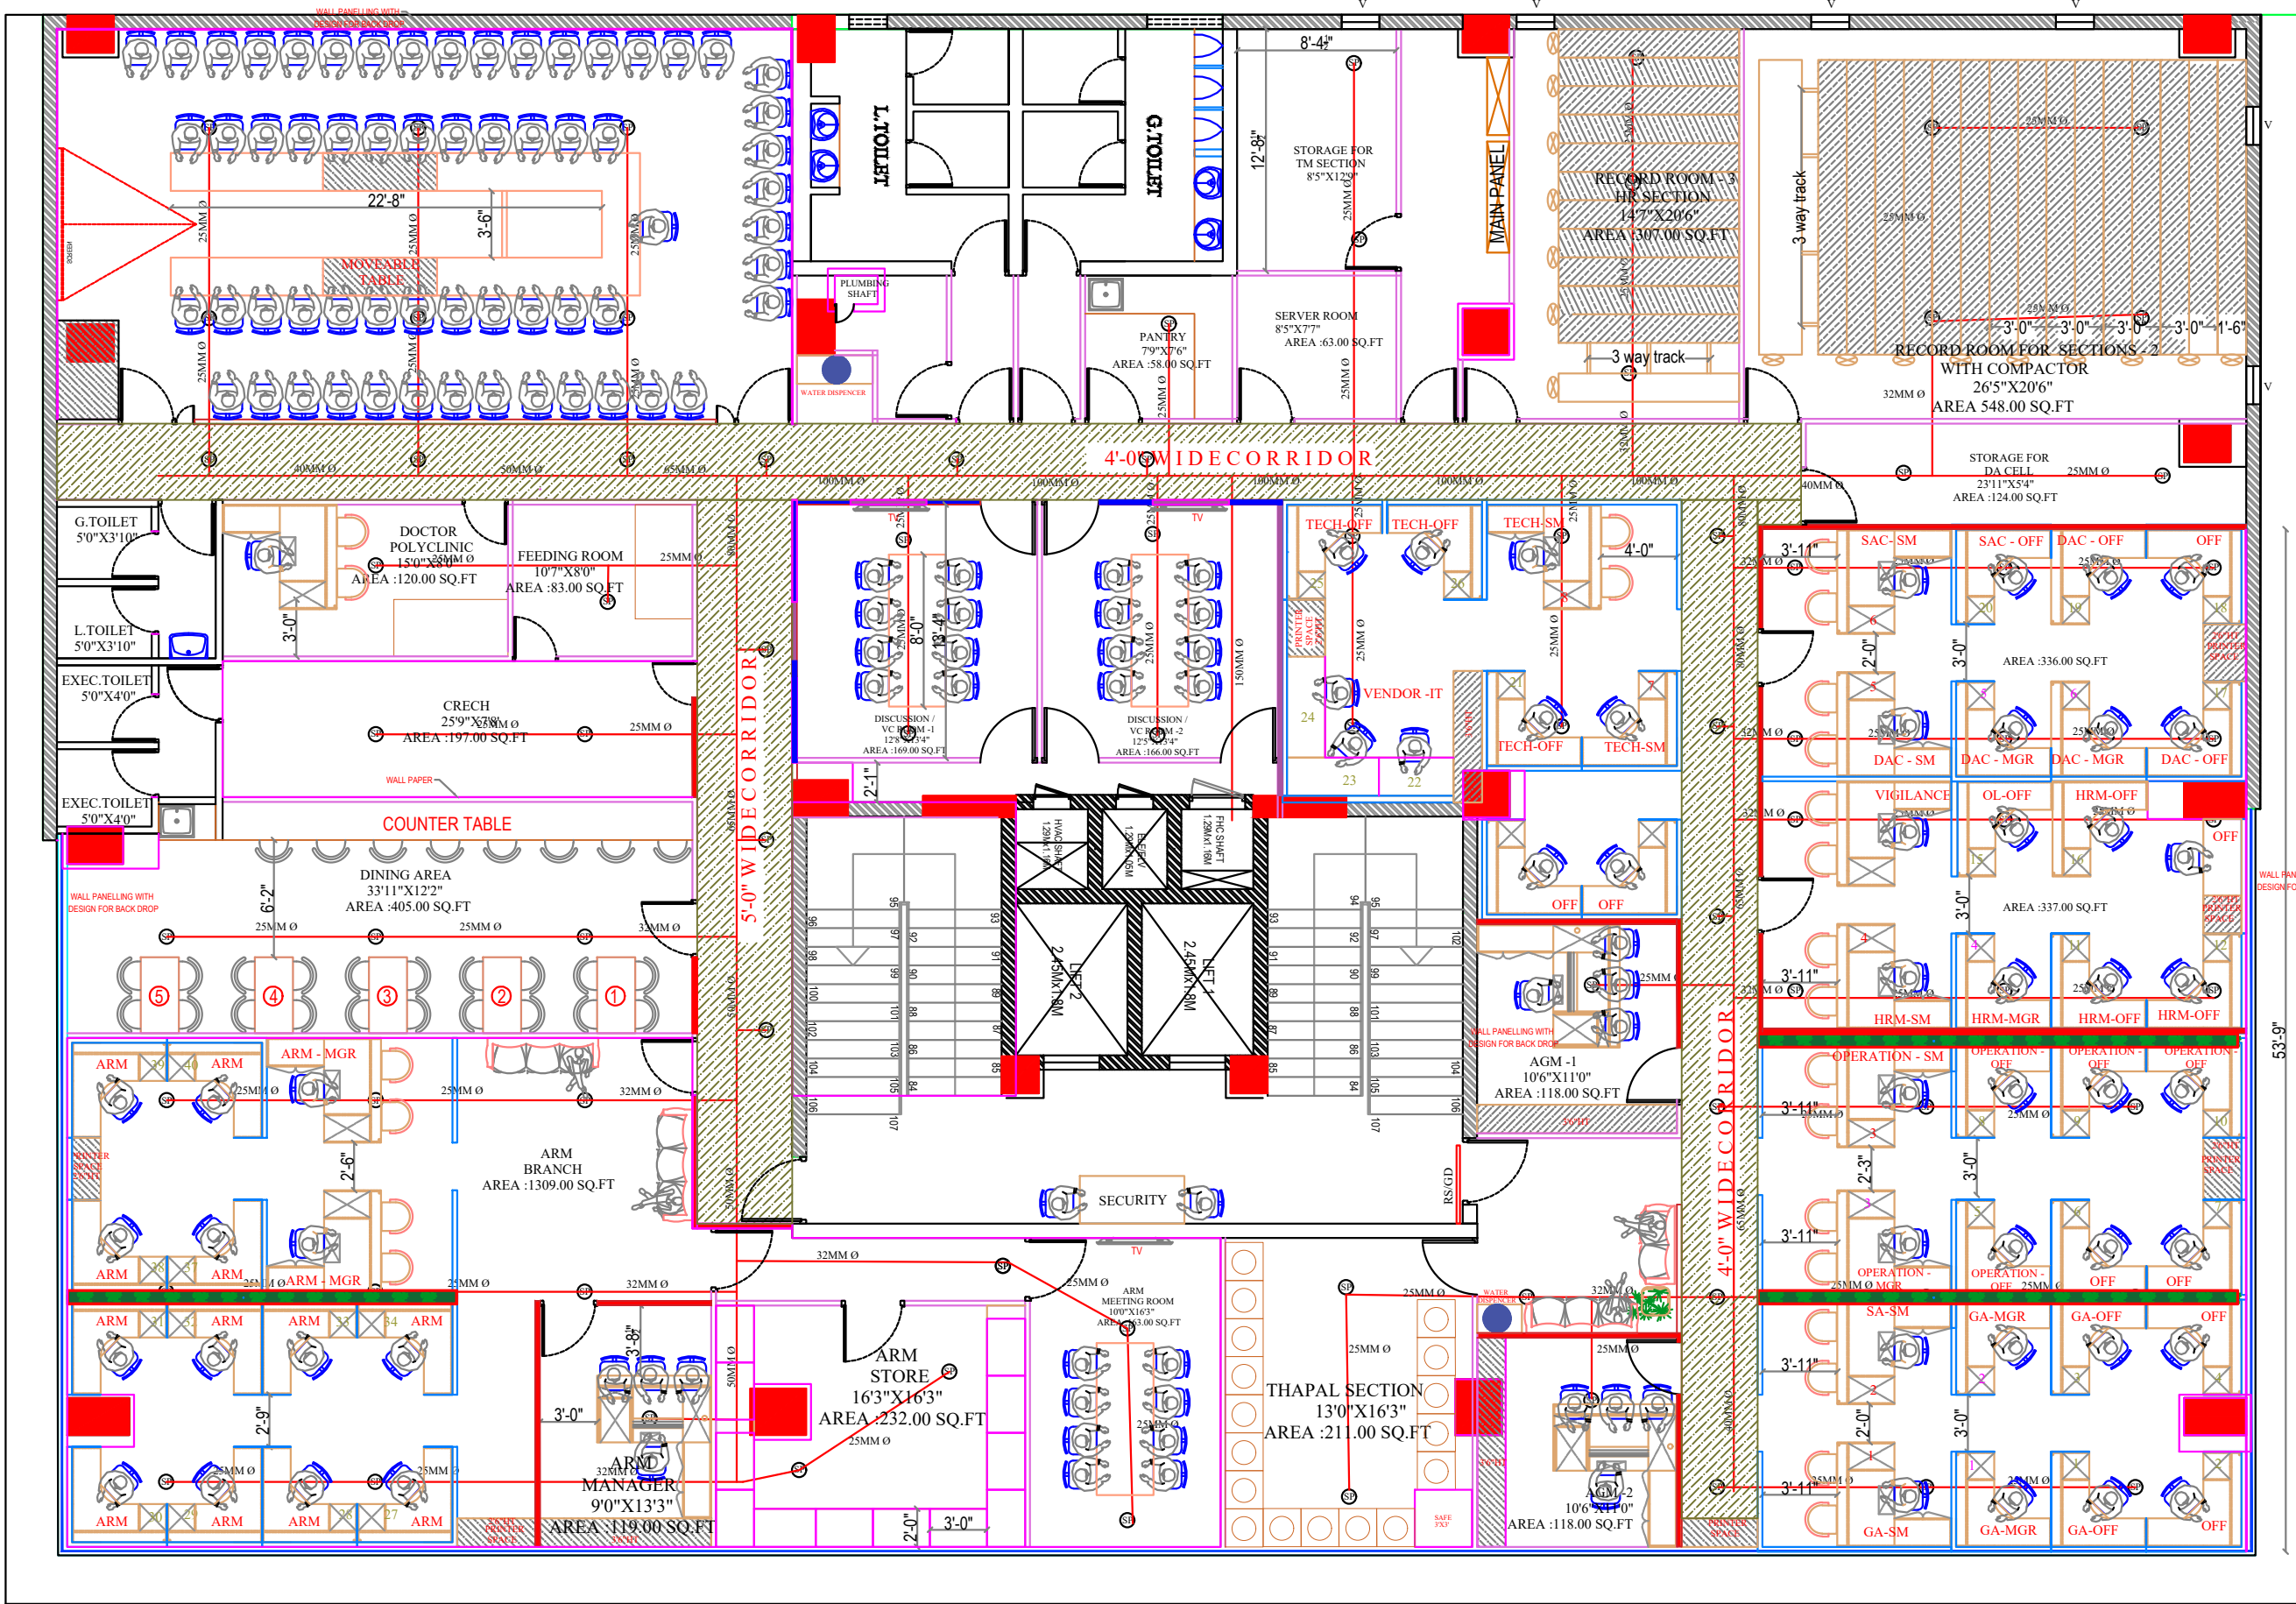


- SEMI GLAZED PARTITION
- LOW HEIGHT PARTITION
- FULL GLAZED PARTITION
- FULL HEIGHT SOLID PARTITION

- ARM MGR - 1
- AGM - 2
- SM - 8
- MGR - 8
- OFFICER - 43

CARPET AREA
 SECOND FLOOR - 7845.10 SQ.FT
 THIRD FLOOR - 8129.10 SQ.FT
 TOTAL AREA - 15974.20 SQ.FT
 (EXCLUDED TOILET & STAIRCASE)

JOB NO	PROJECT TITLE :	PROPOSED INTERIOR DESIGN FOR CANARA BANK CIRCLE OFFICE SAMBAKULAM ROAD, MADURAI.	DRAWING TITLE :	SPRINKLER LAYOUT -SECOND FLOOR	DESIGN STAGE	SCALE	N.T.S	REV NO	REV - 19	ORIENTATION	ARCHITECTS
1739					Confidential					N	TSO DESIGN COMMUNE PVT. LTD. Architects ■ Planners ■ Interior designers
			DRAWING TYPE :	SCHEMATIC DRAWING		DATE	29-04-2025	DRN	K.D		
					■ FINAL COPY	R.DATE	25.10.2025	CHKD	K.S		NEW NO.16,(OLD NO.42), Ground floor, South West Boag Road, T.Nagar, Chennai - 600017. Ph : 044 - 4212 9252 Telefax : 044 - 2435 0490 E-mail : info@tsodc.com

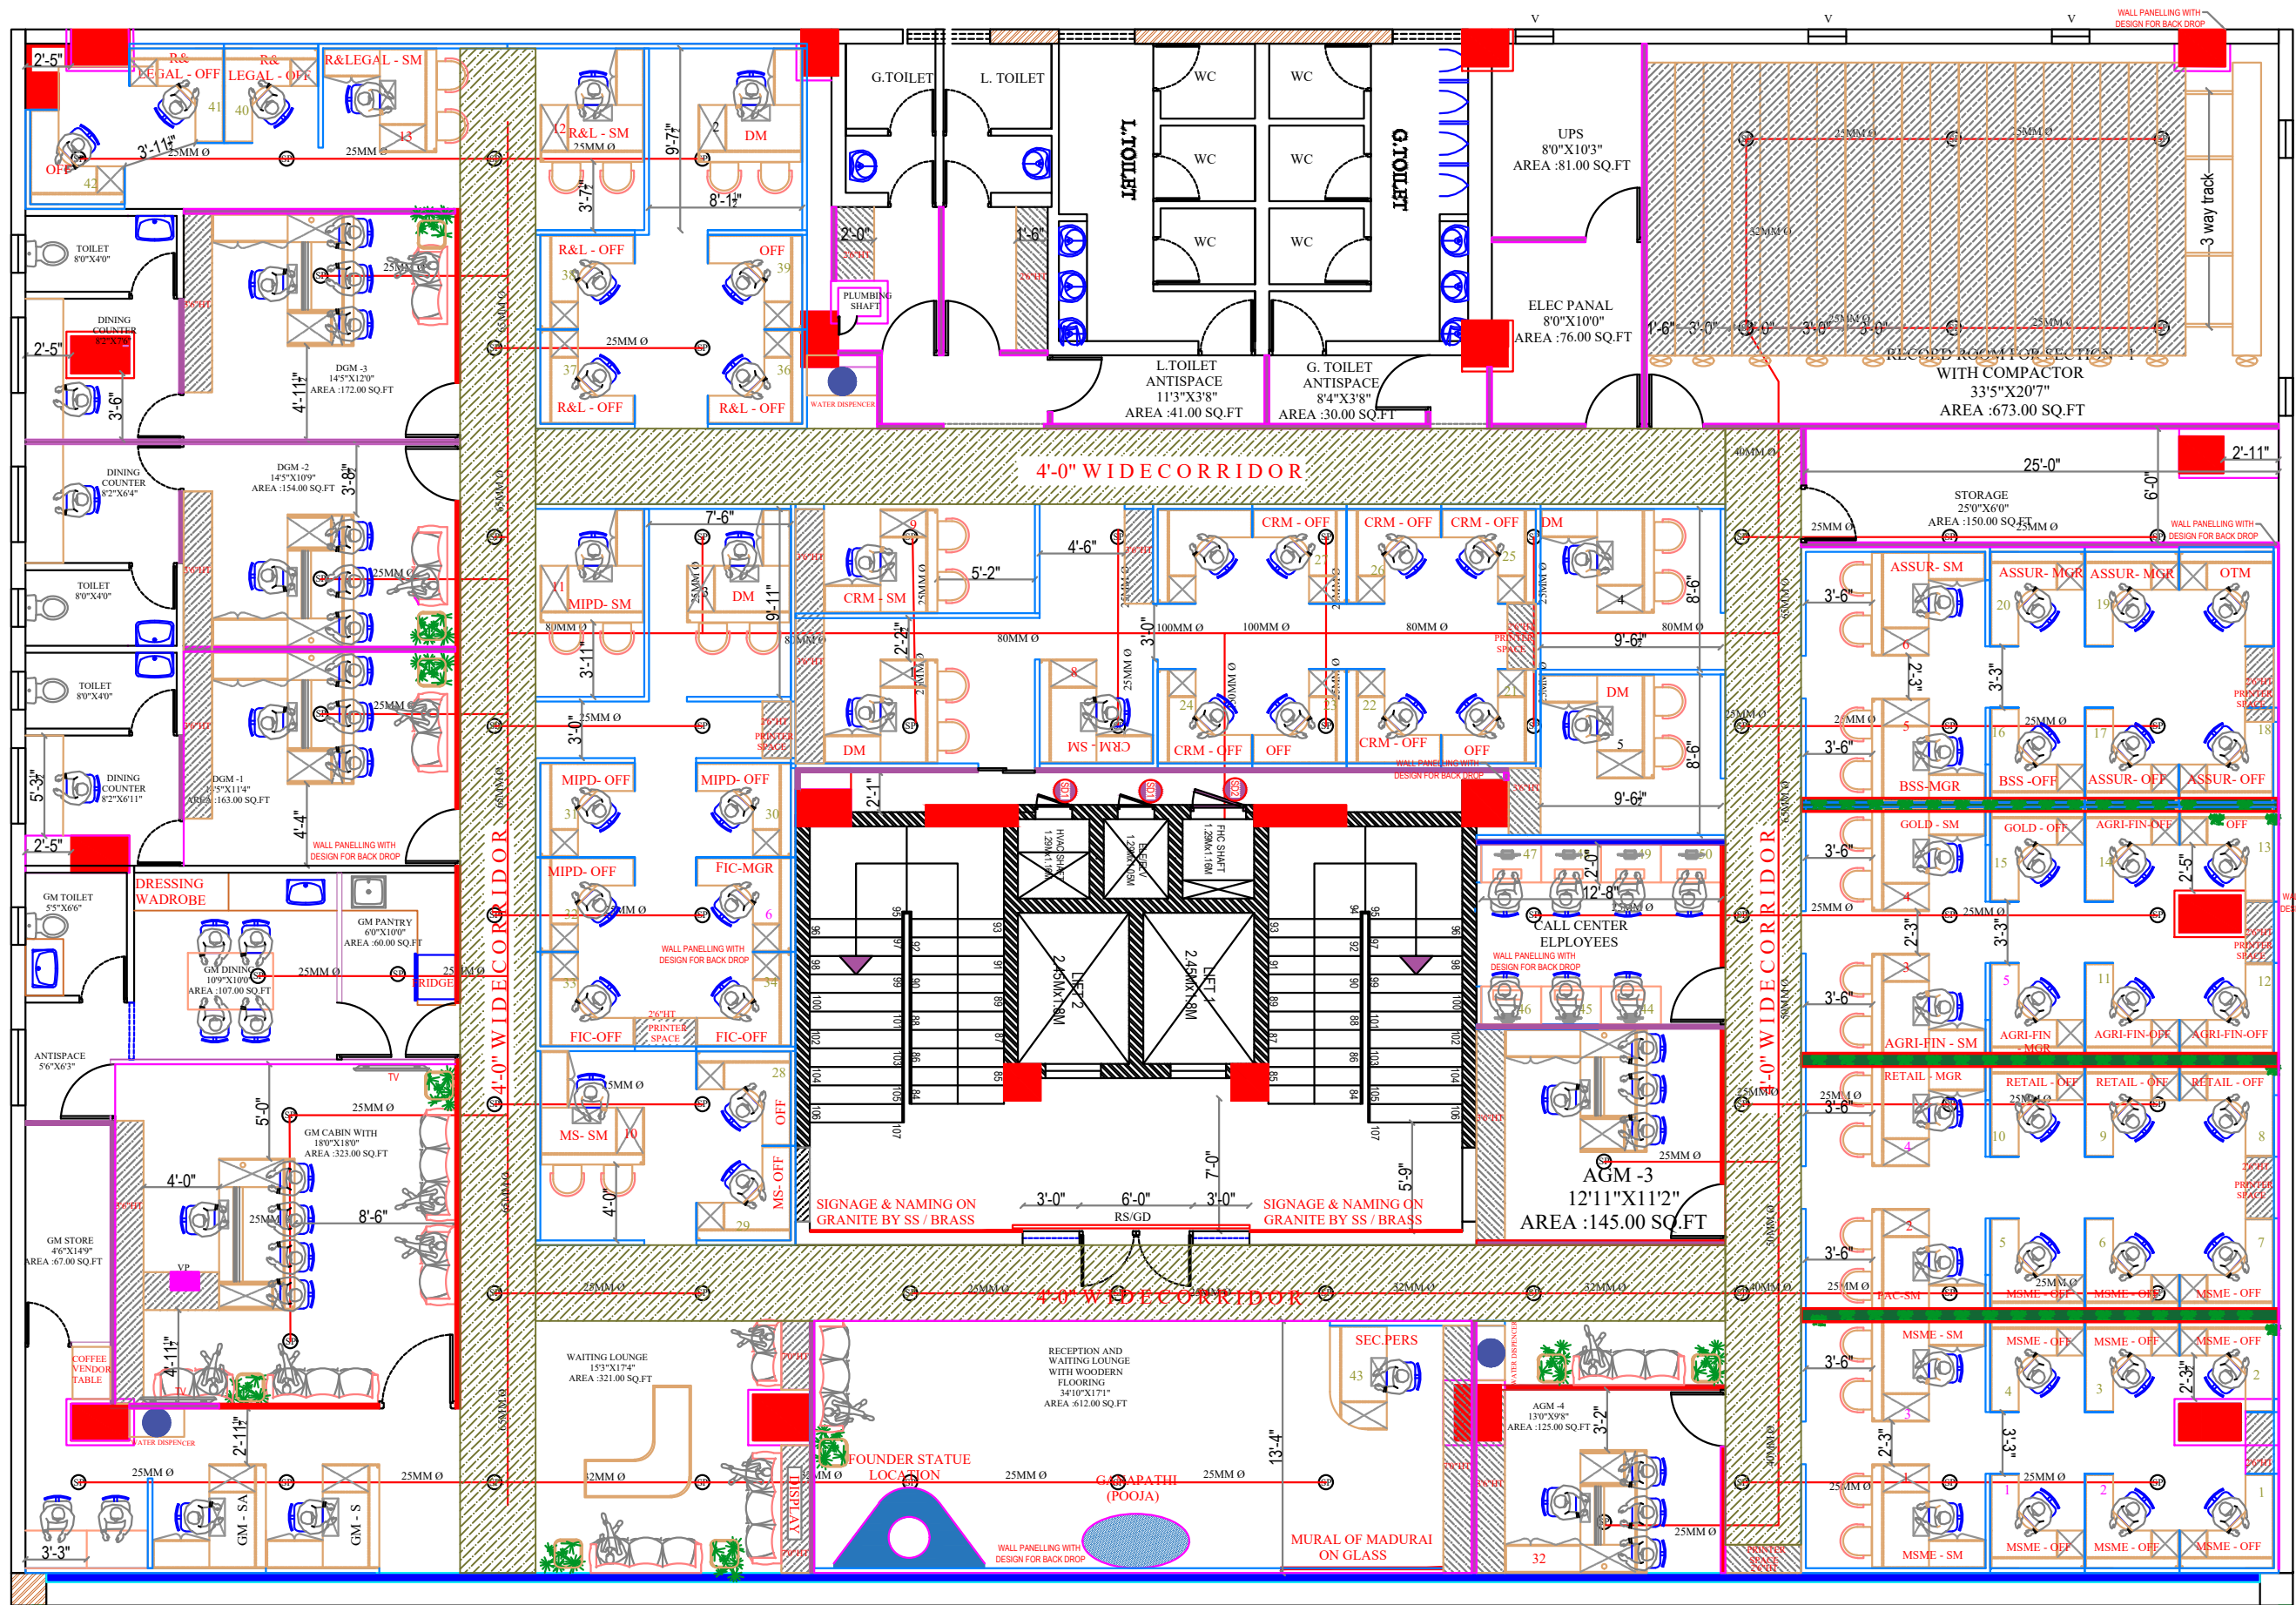

- SEMI GLAZED PARTITION
 - LOW HEIGHT PARTITION
 - FULL GLAZED PARTITION
 - FULL HEIGHT SOLID PARTITION
- | | |
|---------|------|
| GM | - 1 |
| DGM | - 3 |
| DM | - 5 |
| AGM | - 2 |
| SM | - 12 |
| MGR | - 6 |
| OFFICER | - 52 |

CARPET AREA
 SECOND FLOOR - 7845.10SQ.FT
 THIRD FLOOR - 8129.10 SQ.FT
 TOTAL AREA - 15974.20 SQ.FT
 (EXCLUDED TOILET & STAIRCASE)

1739	PROJECT TITLE :	PROPOSED INTERIOR DESIGN FOR		DRAWING TITLE :	SPRINKLER LAYOUT -THIRD FLOOR		DESIGN STAGE	SCHEME LEVEL		SCALE	N.T.S		REV NO	REV - 19		ORIENTATION	ARCHITECTS
		CANARA BANK CIRCLE OFFICE			SAMBAKULAM ROAD, MADURAI.			Schematic Drawing			Final Copy			DATE			
<p style="font-size: small;">TSO DESIGN COMMUNE PVT. LTD. Architects ■ Planners ■ Interior designers NEW NO.16,(OLD NO.42), Ground floor, South West Boag Road, T.Nagar, Chennai - 600017. Ph : 044 - 4212 9252 Telefax : 044 - 2435 0490 E-mail : info@tsodc.com</p>																	