


Note :-  
 \* This drawing is property of **FVC** it must not be retained, copied reproduced in any form without written permission of **FVC**.  
 \* Use architectural drawing for detail dimensions.  
 \* In case of any discrepancy in this drawing or difficulty at site this office should be referred.  
 \* Position of power and light points should be compared with the position of geyser and basin from p.h.e. drawing.  
 \* Diameter of sub main conduit is 1" and remaining are of 0.75".

LEGEND		
SYMBOL	DESCRIPTION	HEIGHT
	CEILING FAN	CEILING
	1X4'-40W FLUORESCENT FIXTURE	7'-0"
	WALL FAN POINT(5/16 5 PIN SOCKET)	ON WALL
	WALL BRACKETILED	7'-0"
	CEILING LIGHT	CEILING
	CHANDELIER	CEILING
	36 WATT LED PANEL LIGHT	CEILING
	SWITCH BOARD WITH 5 AMP SOCKET	4'-6"
	SWITCH BOARD	4'-6"
	5 PIN 5A PLUG WITH SWITCH	1'6"/5'6"
	5 PIN 15A POWER PLUG	1'6"/4'6"
	F/M FOR FREEZE & W/M FOR WASHING	1'6"/4'6"
	25A A.C. POWER PLUG	1'6"
	CALL BELL PUSH SWITCH	4'6"
	CALL BELL BUZER	7'-0"
	EXHAUST FAN	7'-0"
	DECORATIVE CEILING LIGHT FOR DRAWING	
	DECORATIVE WALL LIGHT	ON WALL
	T.V. OUTLET	1'6"
	NETWORKING HUB	
	CALL BELL	ON WALL
	TELEPHONE OUTLET	1'6"
	FIRE DETECTION SYSTEM	CEILING
	E.P.A.B.X (TELEPHONE HUB)	ON WALL
	DISTRIBUTION BOX	6' 0"
	UPS PRIMARY & SECONDRY PANEL	ON WALL
	T.V. JUNCTION BOX	CEILING
	JUNCTION BOX	CEILING
	L.T. MAIN CONTROL PANEL	ON WALL
	WAY FOR T.V. & TELEPHONE WIRING.	
	WAY FOR POINT WIRING. (25mm dia pipe)	
	WAY FOR POINT WIRING (19mm dia pipe)	
	WAY FOR SUB MAIN WIRING.	
	WAY FOR POWER POINT WIRING.	
	WAY FOR CIRCUIT WIRING.	
	WAY FOR NETWORKING & TELEPHONE.	
	WAY FOR RAW POWER WIRING.	
	WAY FOR UPS POWER WIRING.	

PROJECT	
ELECTRICAL LAYOUT OF RSTC BRANCH AT ,PATNA	
CLIENT	
CANARA BANK	
DRAWN BY	NORTH
AR. FARHEEN HAQUE	
CHECKED BY	
SCALE	DATE
	28-07-2025

Architects :-

**ARTCON DESIGN CONSULTANTS**  
 ARCHITECTS ENGINEERS  
 INTERIOR DESIGNERS COMPUTER AIDED DESIGN  
 305, B-Block, Capitol Tower, Fraser Road, Patna-1  
 +91 9931723771 amikumar73@gmail.com  
 +91 9386717726 artcondesignconsultants.com

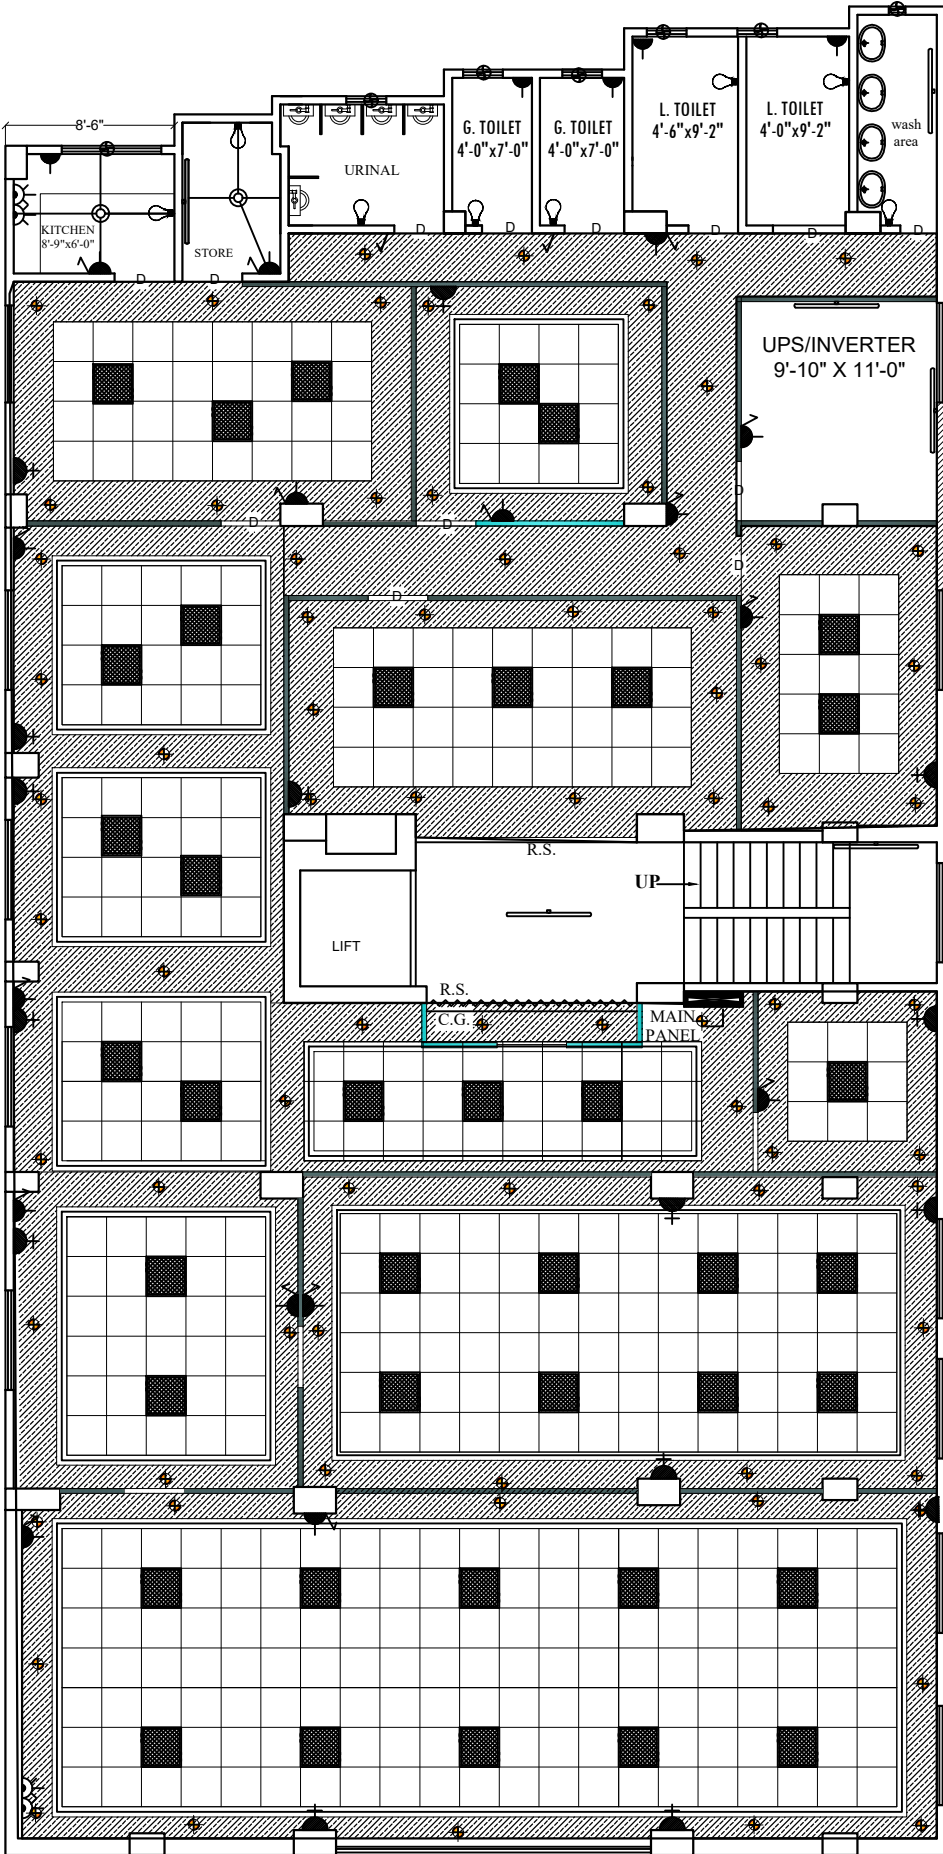

THIRD FLOOR PLAN

Internal