

CLIENTS:  
 CANARA BANK  
 MAIN ROAD  
 NAGARGAON, RAIPUR

DEALT:  
 M.J.


DATE:  
 22.11.2025

DRG. NO.  
 02 R/2

SCALE:  
 NTS

TITLE :  
 INTERIOR LAYOUT

NICON INDIA  
 34,GURUKUL COMPLEX, KALIBADI ROAD  
 RAIPUR. (C.G.)  
 TEL : 2225408

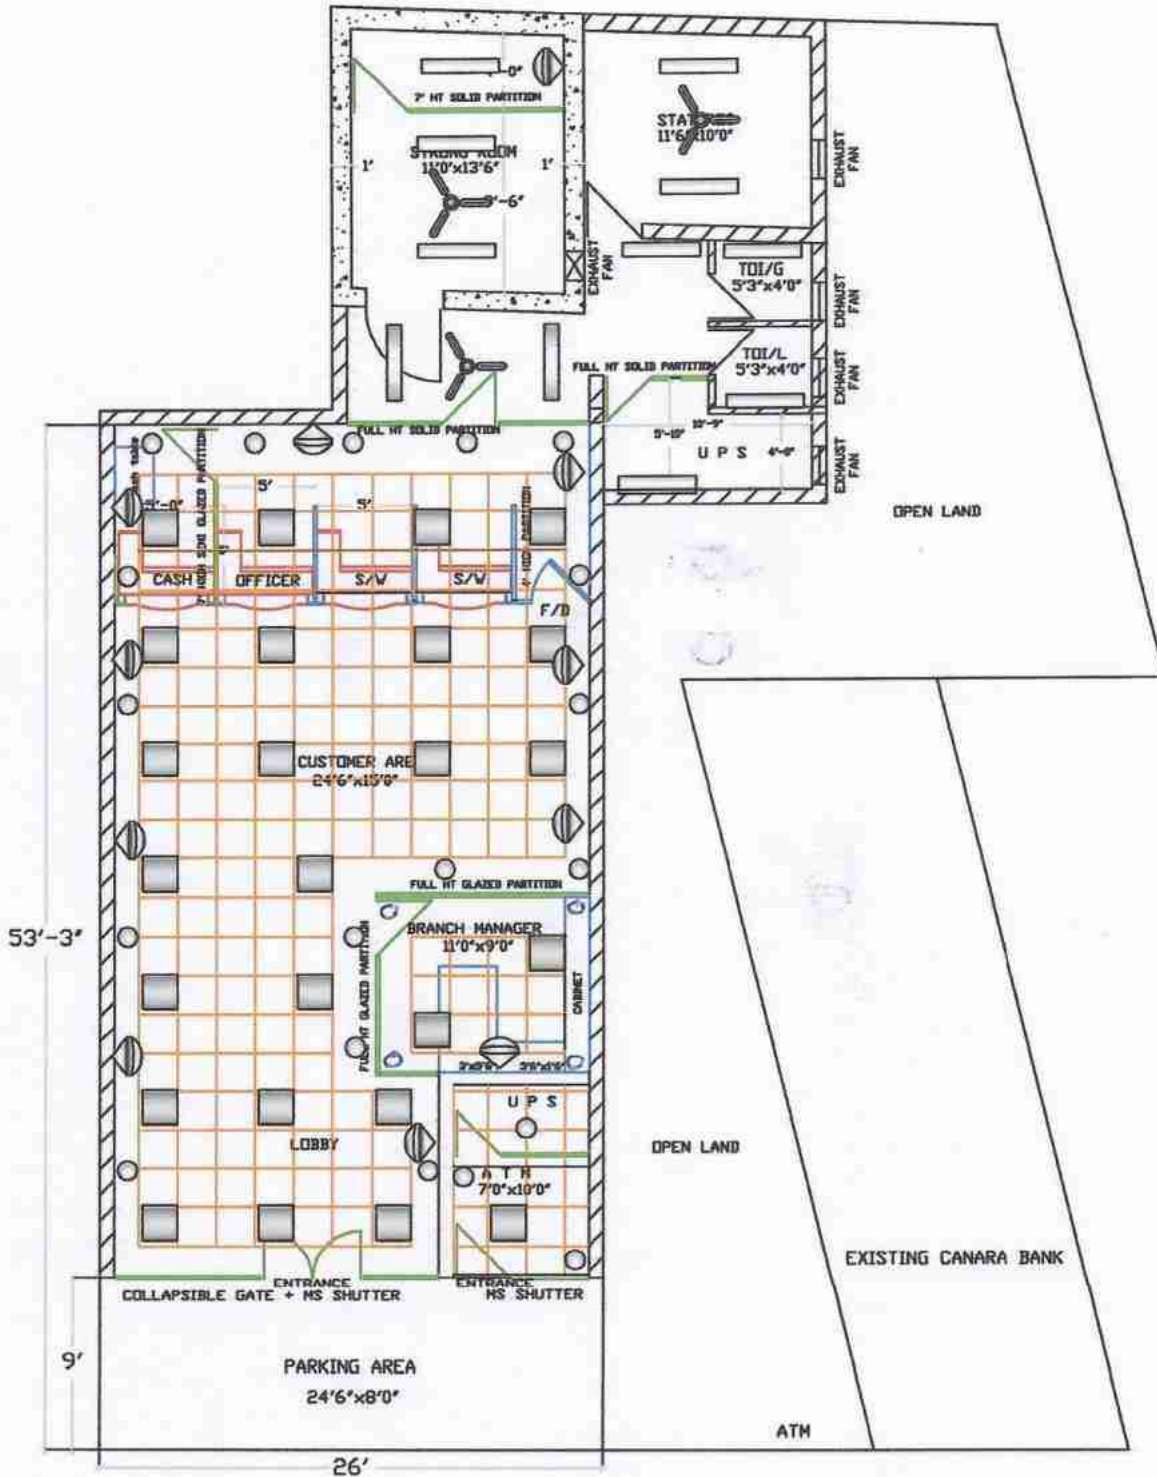


CLIENTS:  
CANARA BANK  
MAIN ROAD  
NAGARGADIN, RAIPUR

DEALT:  
M.J.  
DATE:  
22.11.2025

DRG. NO.  
04  
SCALE:  
NTS

TITLE :  
ELECTRICAL LAYOUT

NICON INDIA  
34, GURUKUL COMPLEX, KALIBADI ROAD  
RAIPUR. (C.G.)  
TEL : 2225408

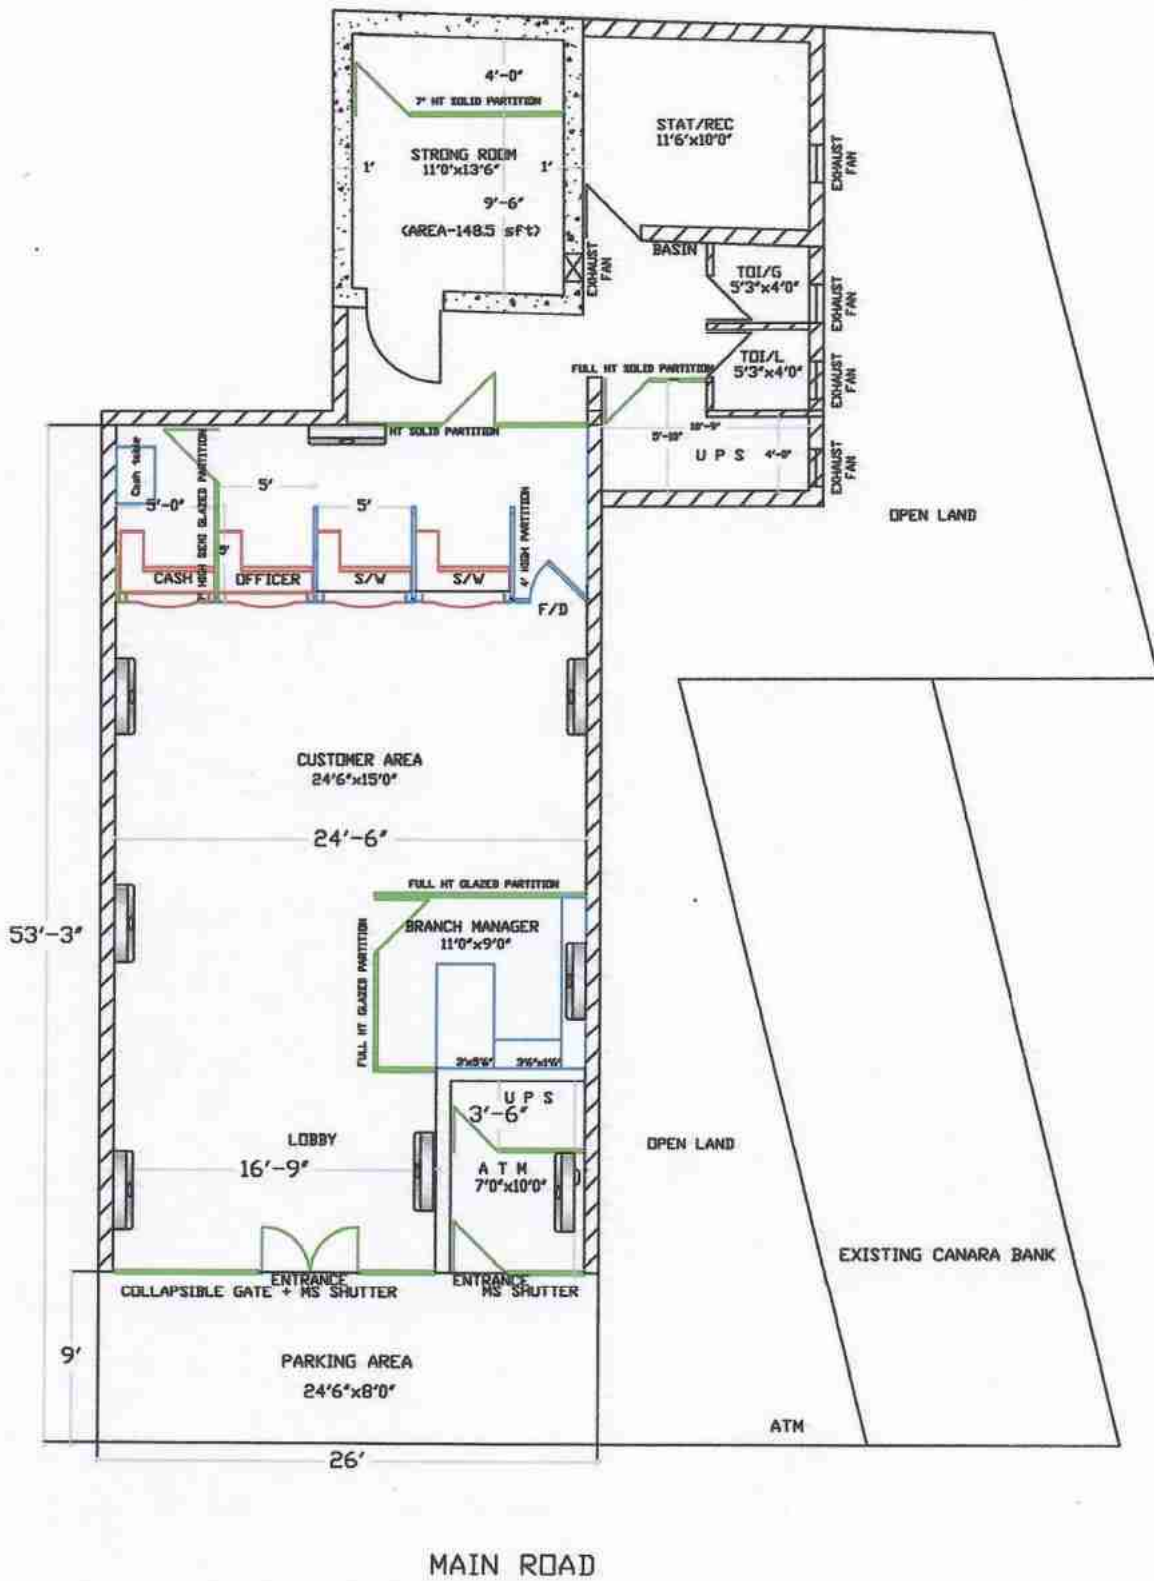

CLIENTS:  
CANARA BANK  
MAIN ROAD  
NAGARGADN, RAIPUR

DEALT:  
M.J.


DATE:  
22.11.2025

DRG. NO.  
05

SCALE:  
NTS

TITLE :  
AC LAYOUT

NICON INDIA  
34, GURUKUL COMPLEX, KALIBADI ROAD  
RAIPUR. (C.G.)  
TEL : 2225408

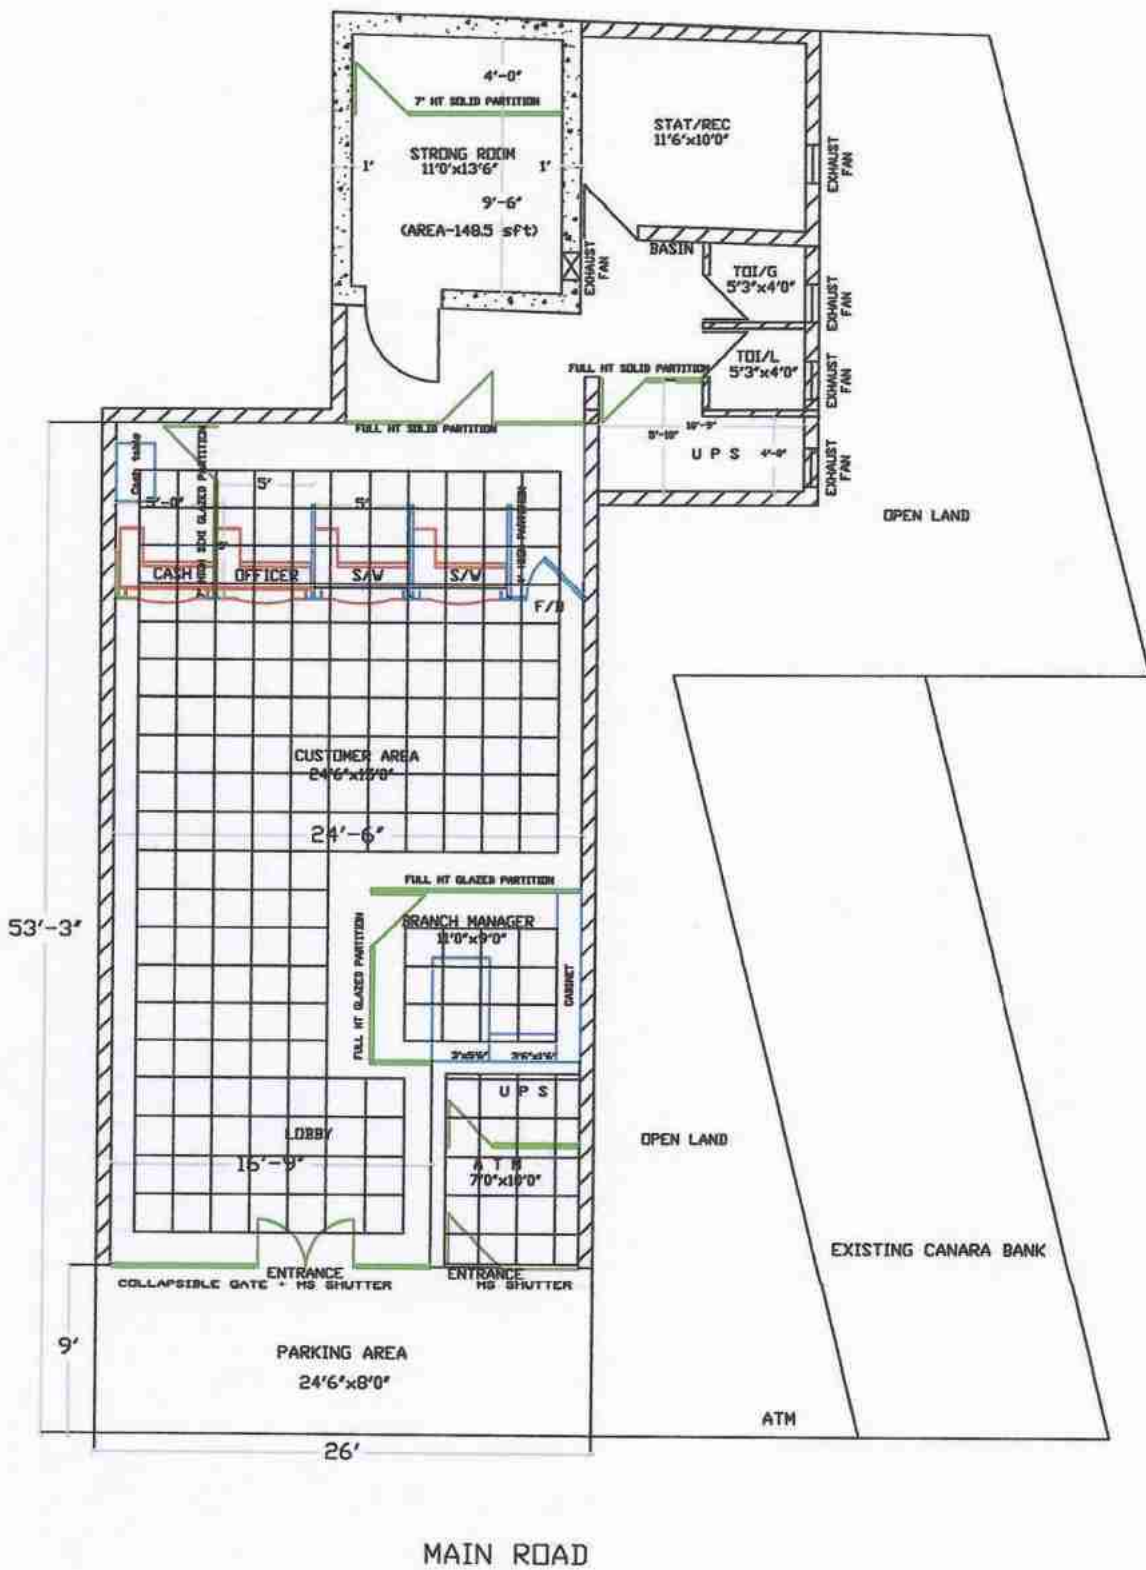

CLIENTS:  
CANARA BANK  
MAIN ROAD  
NAGARGAON, RAIPUR

DEAL T:  
M.J.

DATE:  
22.11.2025

DRG. NO.  
03

SCALE:  
NTS

TITLE :  
FALSE CEILING LAYOUT

NICON INDIA  
34, GURUKUL COMPLEX, KALIBADI ROAD  
RAIPUR, (C.G.)  
TEL : 2225408